 



C1 PLUMBING PLAN - LOWER LEVEL

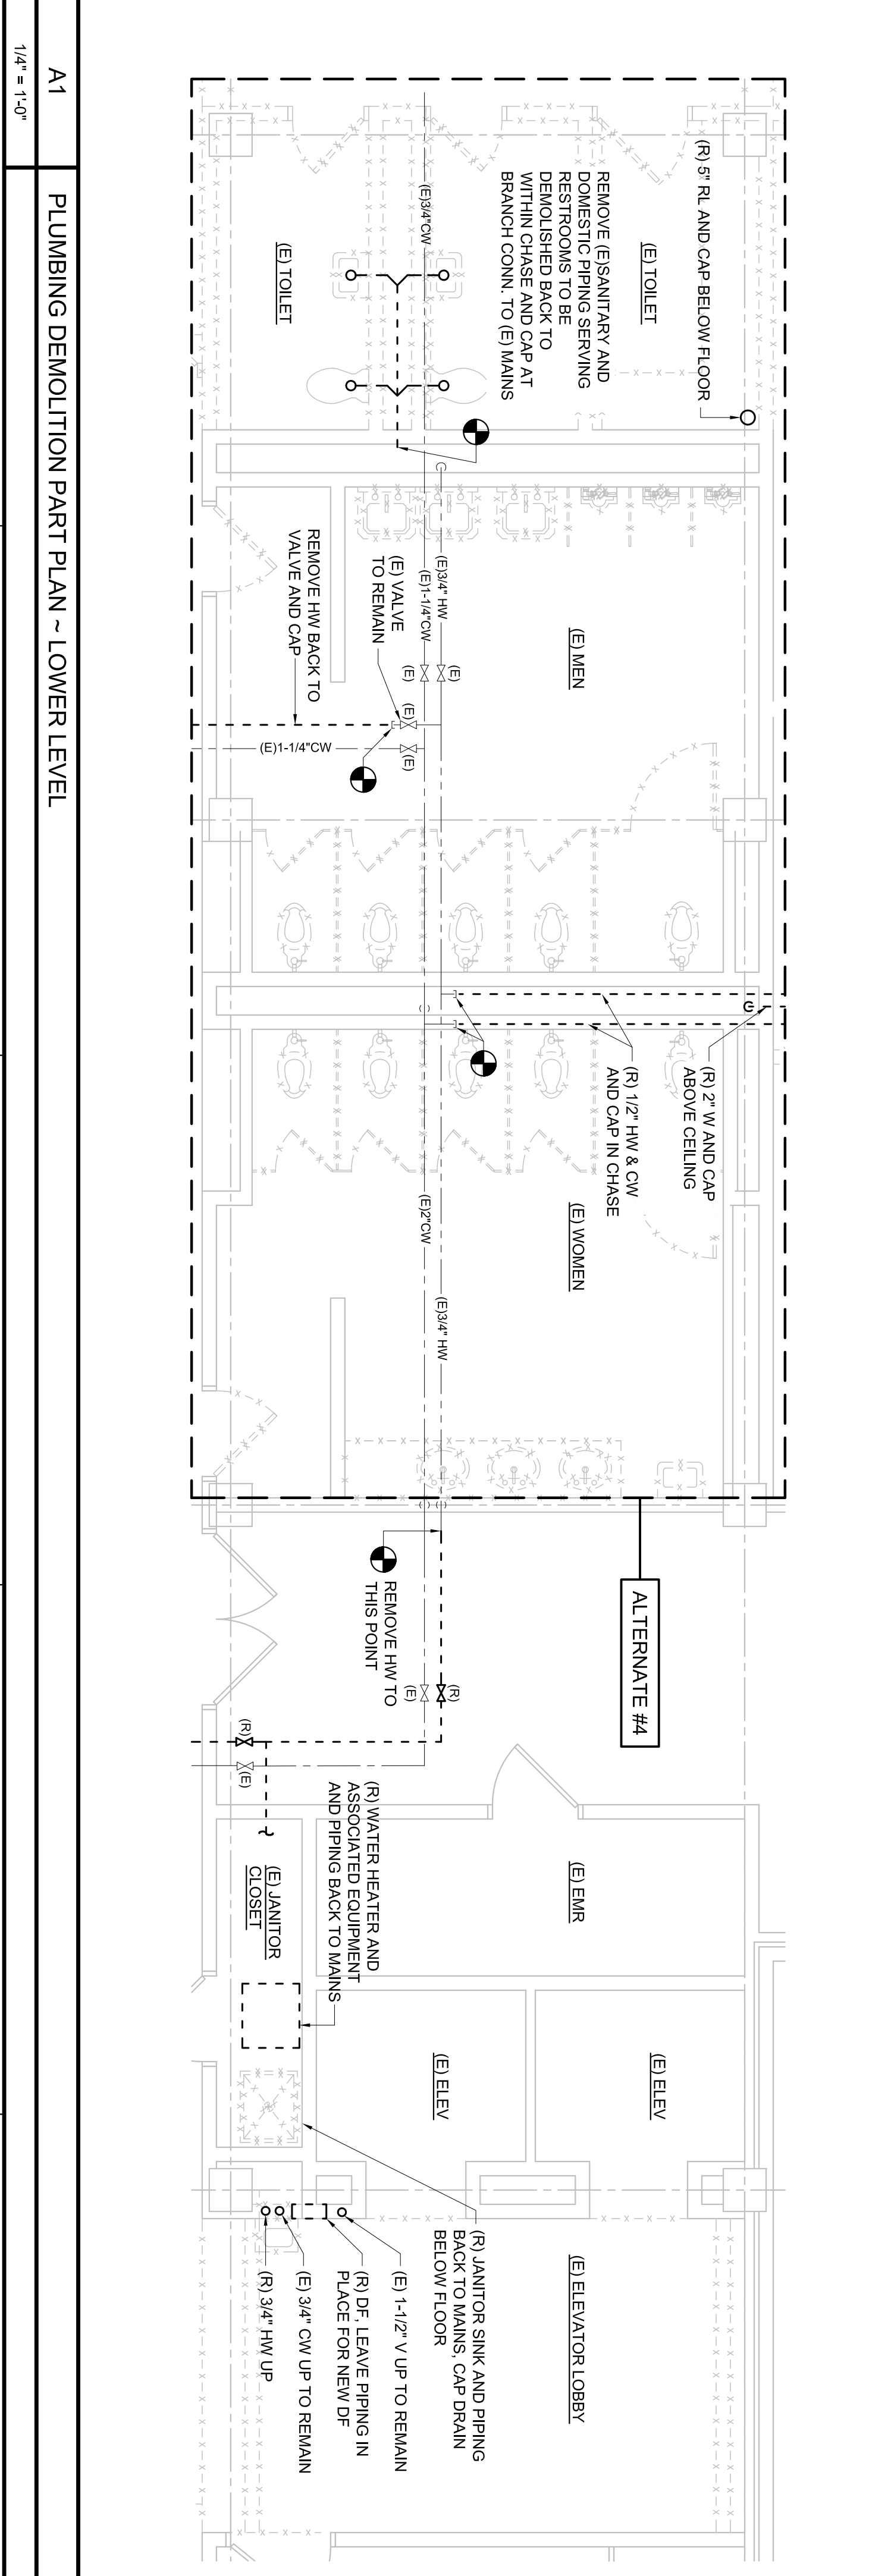

<p>PROJECT Portland Public Library Renovation PORTLAND, ME</p>		<p>TITLE PIPING DEMOLITION PLAN LOWER LEVEL</p>	
<p>STATUS: Issued for Bidding</p>		<p>DATE: 02/02/09 SCALE: REVISION DATE:</p>	
<p>PROJECT NO.: 2008-0030 DRAWN BY: DATE:</p>		<p>PROJECT NO.: 2008-0030 DRAWN BY: DATE:</p>	
<p>DWG NO.: PD-100</p>		<p>DWG NO.: PD-100</p>	

<p>KEY NOTES</p>	
<p>THIS DRAWING IS THE PROPERTY OF ALLIED ENGINEERING AND SHOULD NOT BE COPIED OR REPRODUCED IN PART OR WHOLE.</p>	

Allied Engineering
161 Yamada Street
Portland, ME 04103
Tel: 207.221.1246
Fax: 207.221.1246
www.allied-eng.com

SSS
Scott Simon, A.C.E. #118411
Professional Engineer
161 Yamada Street
Portland, ME 04103
Tel: 207.221.1246
Fax: 207.221.1246
www.sss-engineering.com

STATE OF MAINE
REGISTERED PROFESSIONAL ENGINEER
SCOTT SIMON
No. 118411
EXPIRES 12/31/10

PLAN NORTH