
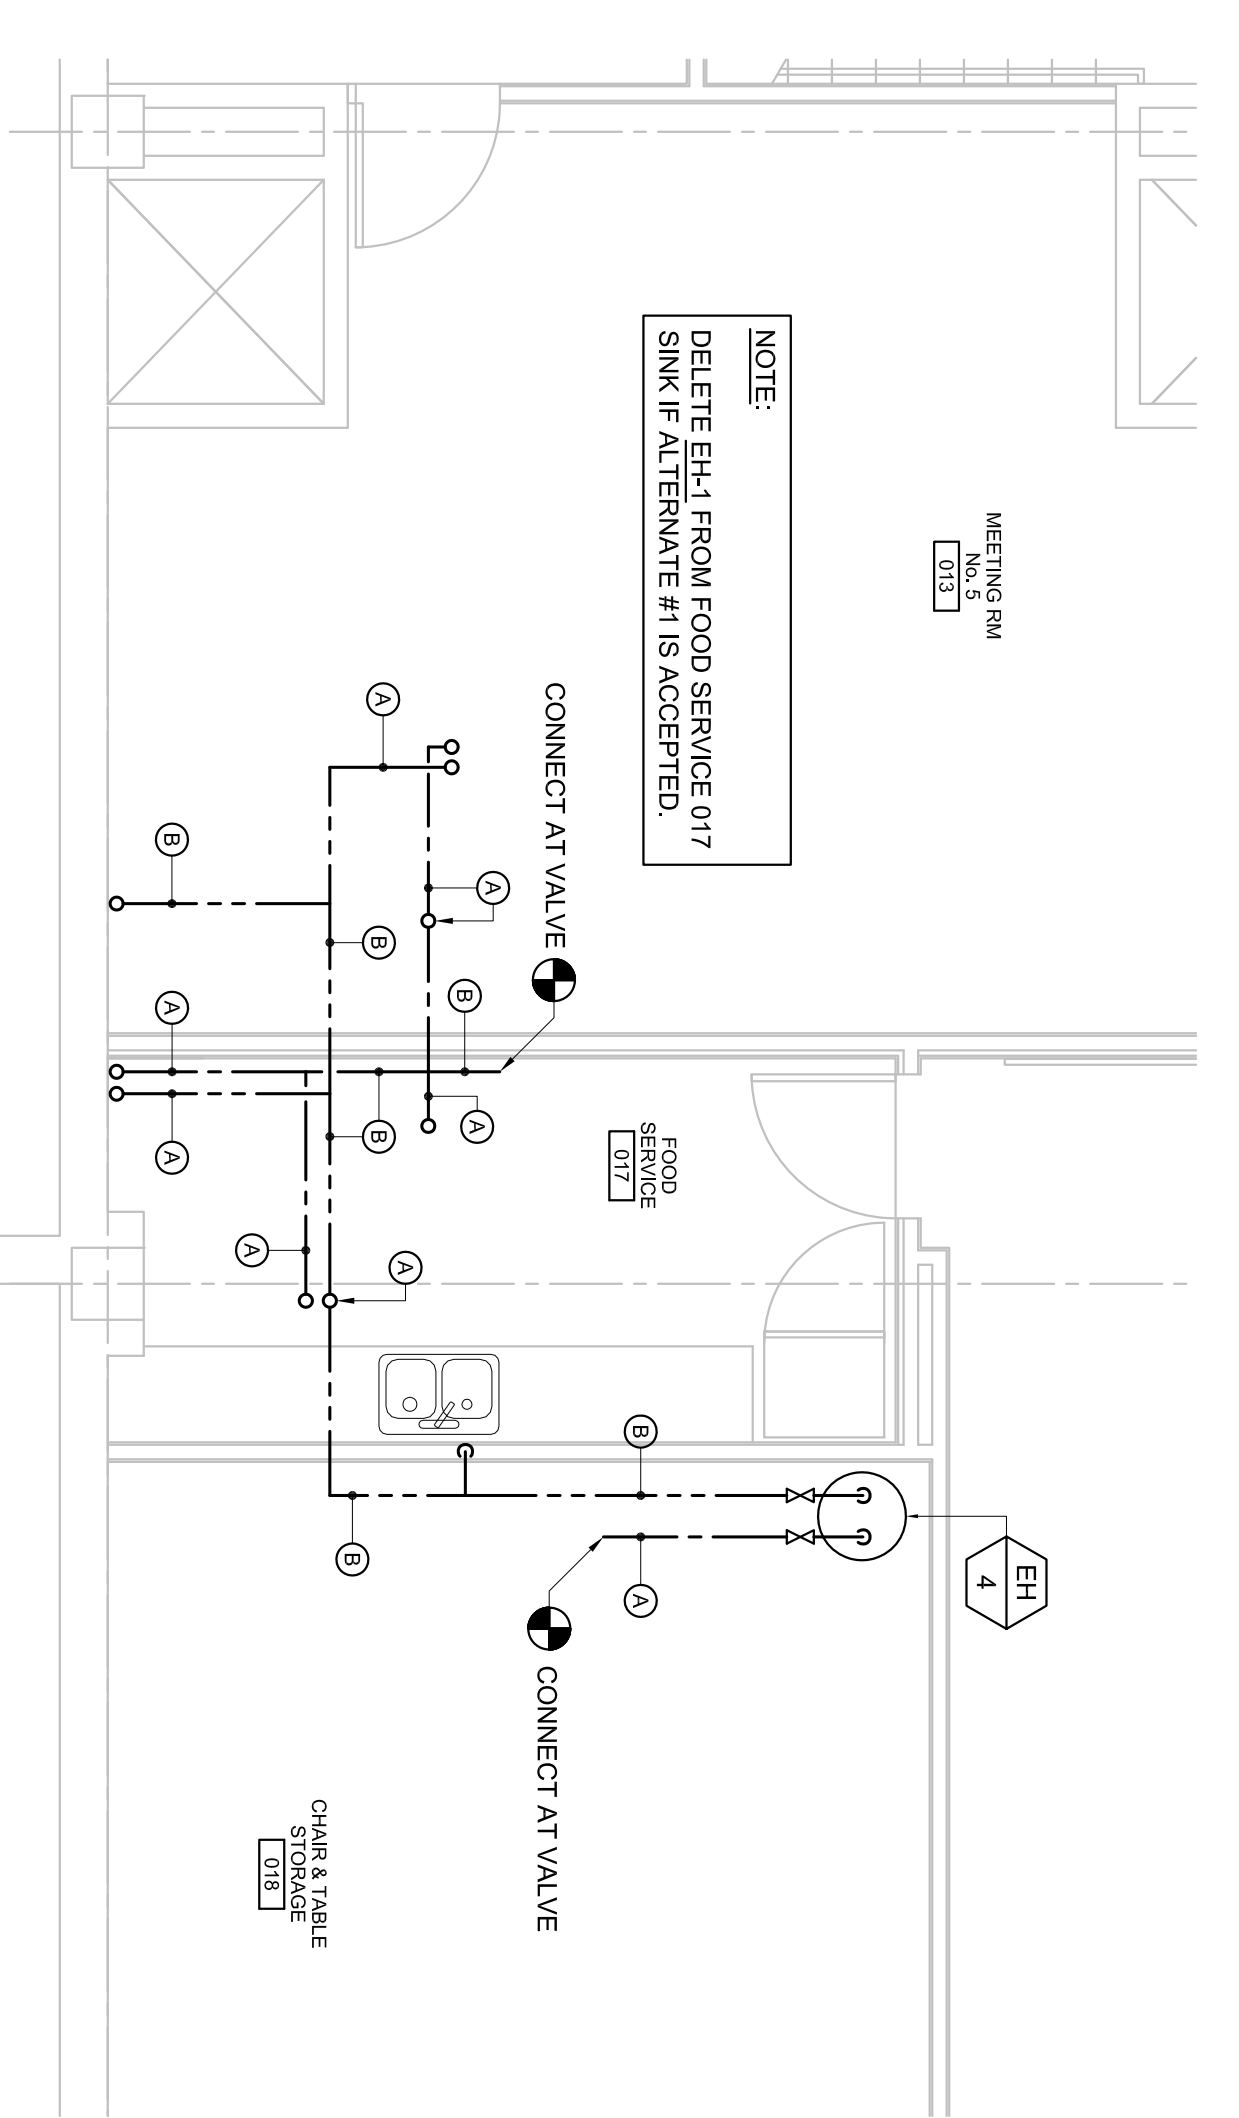


C1 DOMESTIC PIPING PLAN - LOWER LEVEL

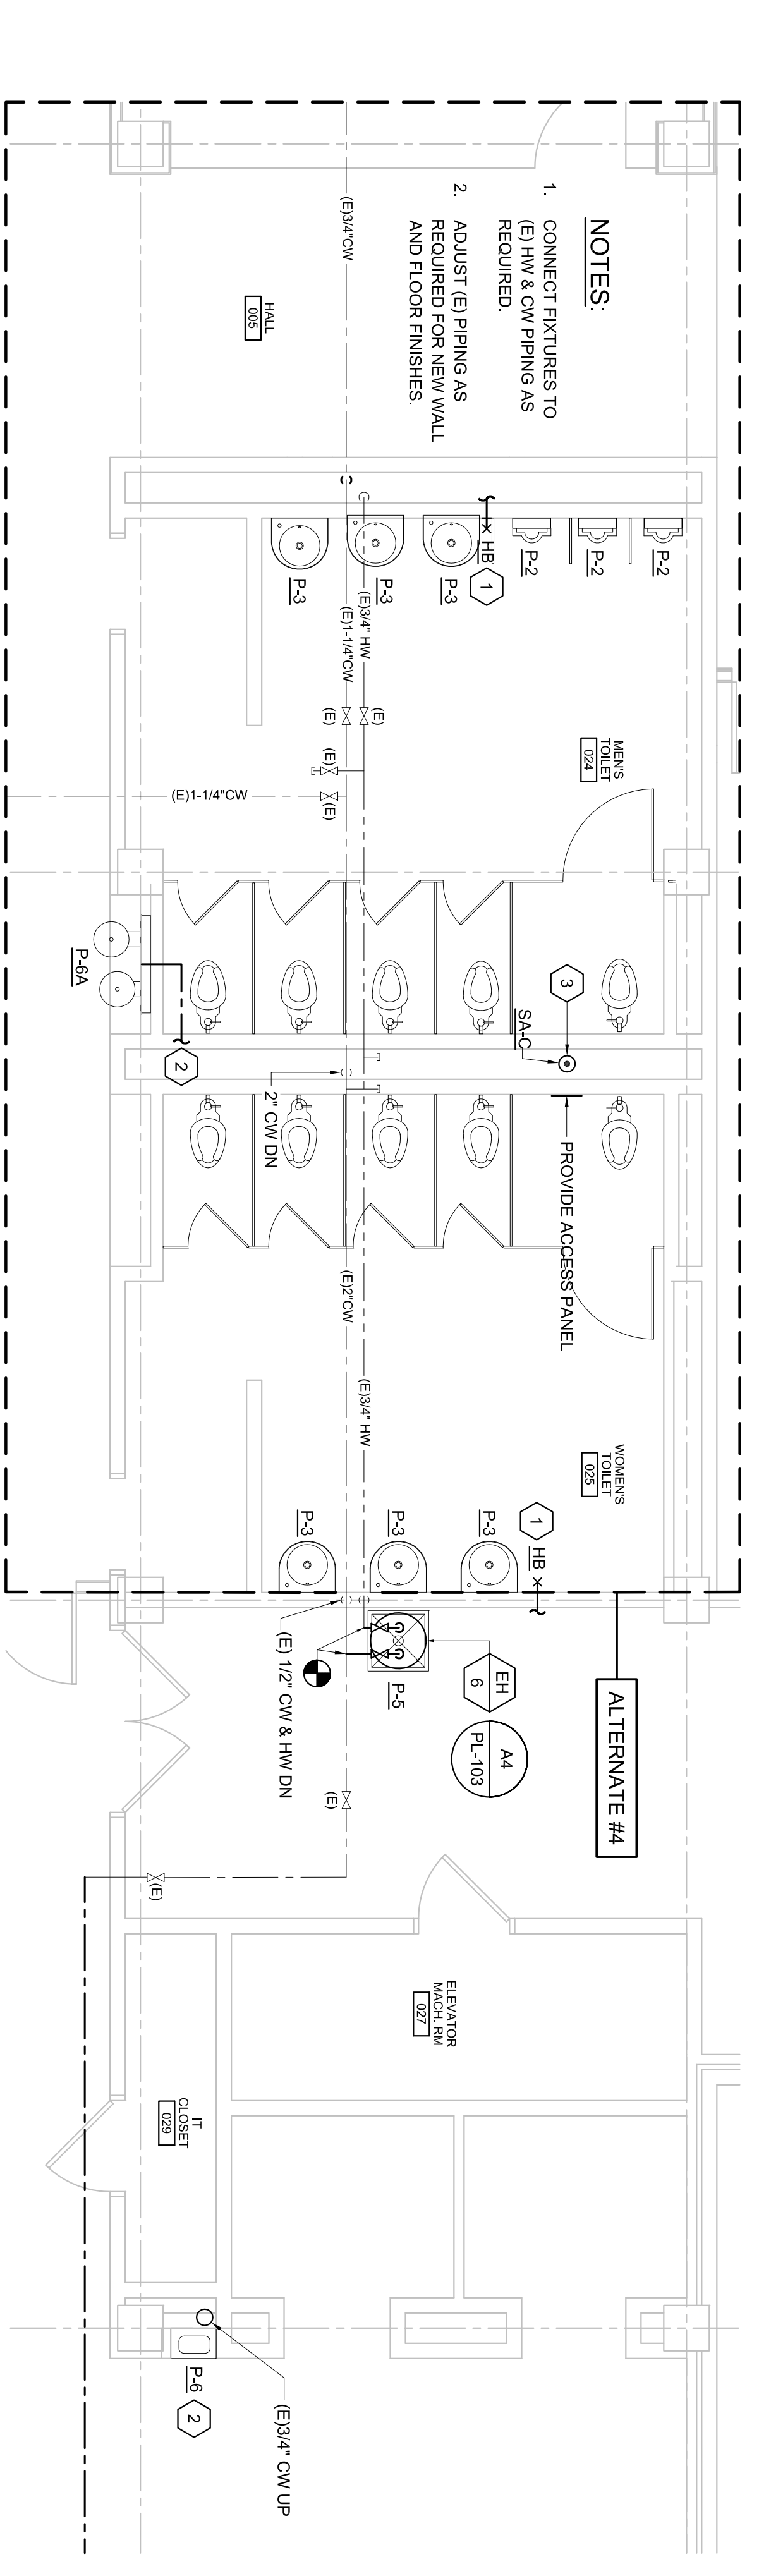

A1 DOMESTIC PLUMBING PART PLAN AND ALTERNATE #4

A6 DOMESTIC PLUMBING PART PLAN - ALTERNATE #1

<p>PROJECT</p> <p>Portland Public Library Renovation</p> <p>PORTLAND, ME</p>		<p>DATE: 02/26/09</p> <p>PROJECT NO: 2008-0030</p> <p>DRAWN BY: [Signature]</p> <p>DATE: 02/26/09</p> <p>PROJECT NO: 2008-0030</p> <p>DRAWN BY: [Signature]</p>							
<p>STATUS:</p> <p>Issued for Bidding</p>		<p>THIS DRAWING IS THE PROPERTY OF [Firm Name] AND IS NOT TO BE COPIED OR REPRODUCED IN WHOLE OR IN PART.</p>							
<p>KEY NOTES</p> <ol style="list-style-type: none"> CONNECT 1/2" USE 888 PIPING TO EXISTING CV PIPING IN WALL OR CHASE CONNECT DRINKING FOUNTAIN TO IE/CV PIPING IN CHASE PROVIDE WATER HAMMER ARRESTER ON COLD WATER LINE SERVING WATER CLOSETS. SIZE AS INDICATED. PROVIDE ACCESS PANEL FOR MAINTENANCE. SEE A6P-L100 FOR ALTERNATE #1 CONTINUATION. 		<p>COIL PIPE SIZES</p> <table border="1"> <tr><td>1/2"</td><td>3/4"</td></tr> <tr><td>1"</td><td>1 1/4"</td></tr> <tr><td>1 1/2"</td><td>2"</td></tr> </table>		1/2"	3/4"	1"	1 1/4"	1 1/2"	2"
1/2"	3/4"								
1"	1 1/4"								
1 1/2"	2"								
<p>PROJECT NO: 2008-0030</p> <p>DATE: 02/26/09</p> <p>PROJECT NO: 2008-0030</p> <p>DRAWN BY: [Signature]</p>		<p>PROJECT NO: 2008-0030</p> <p>DATE: 02/26/09</p> <p>PROJECT NO: 2008-0030</p> <p>DRAWN BY: [Signature]</p>							