
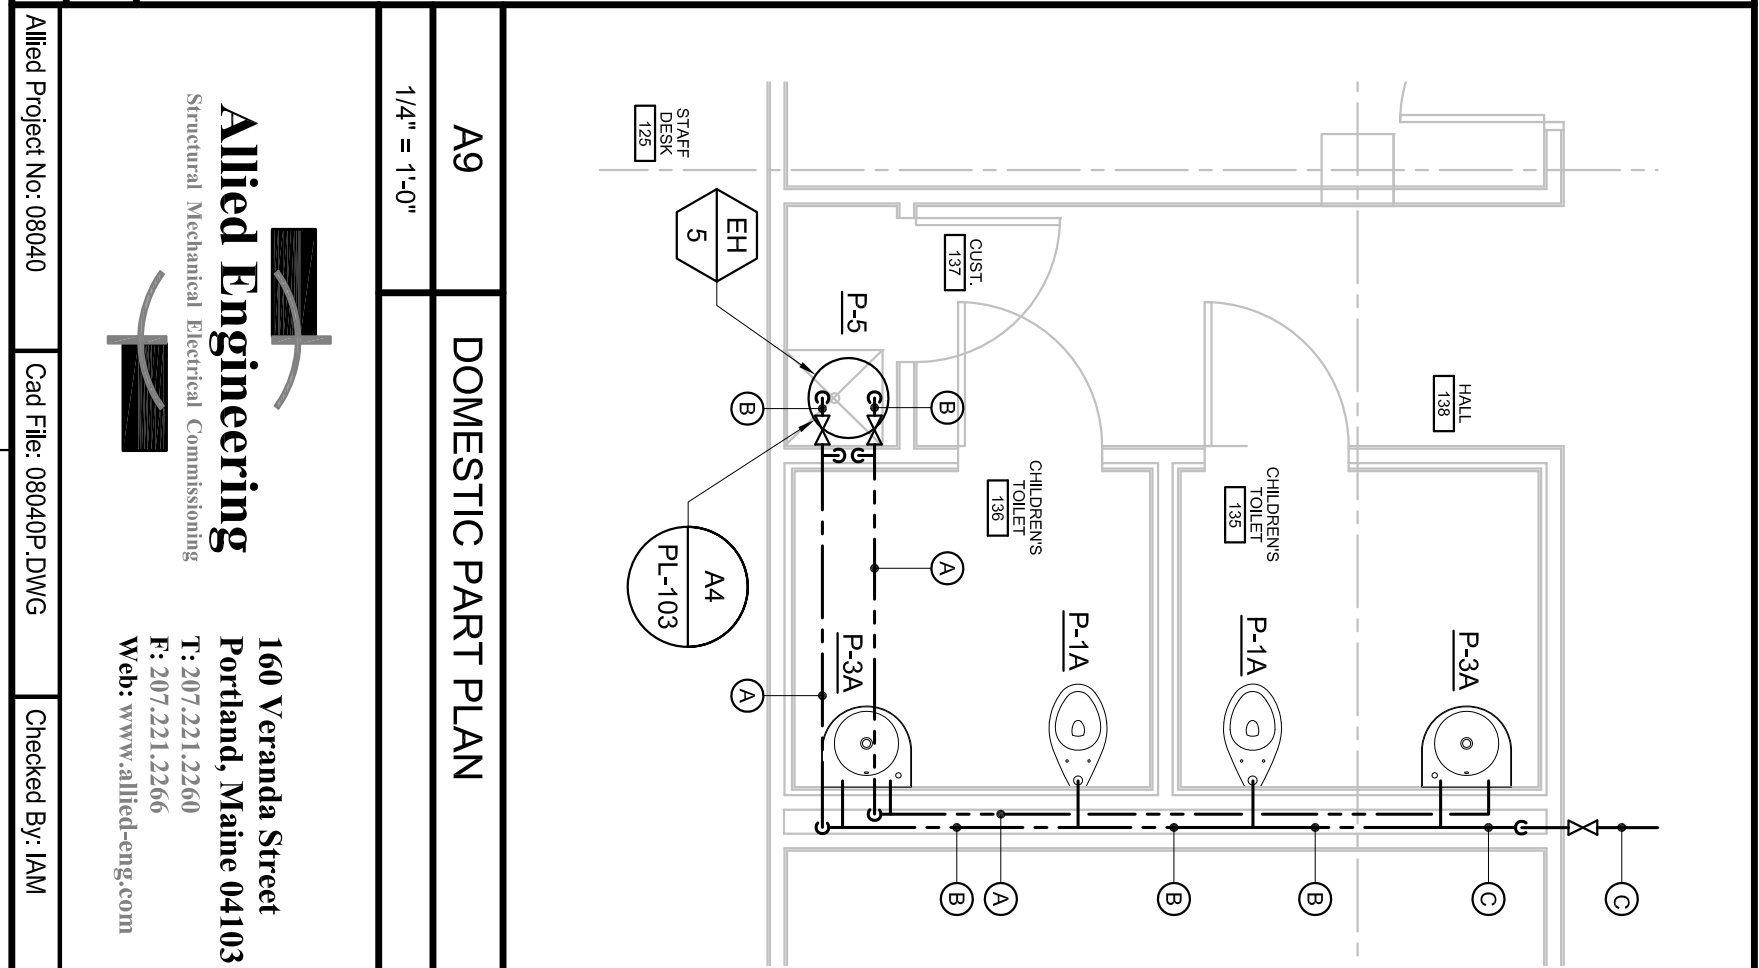
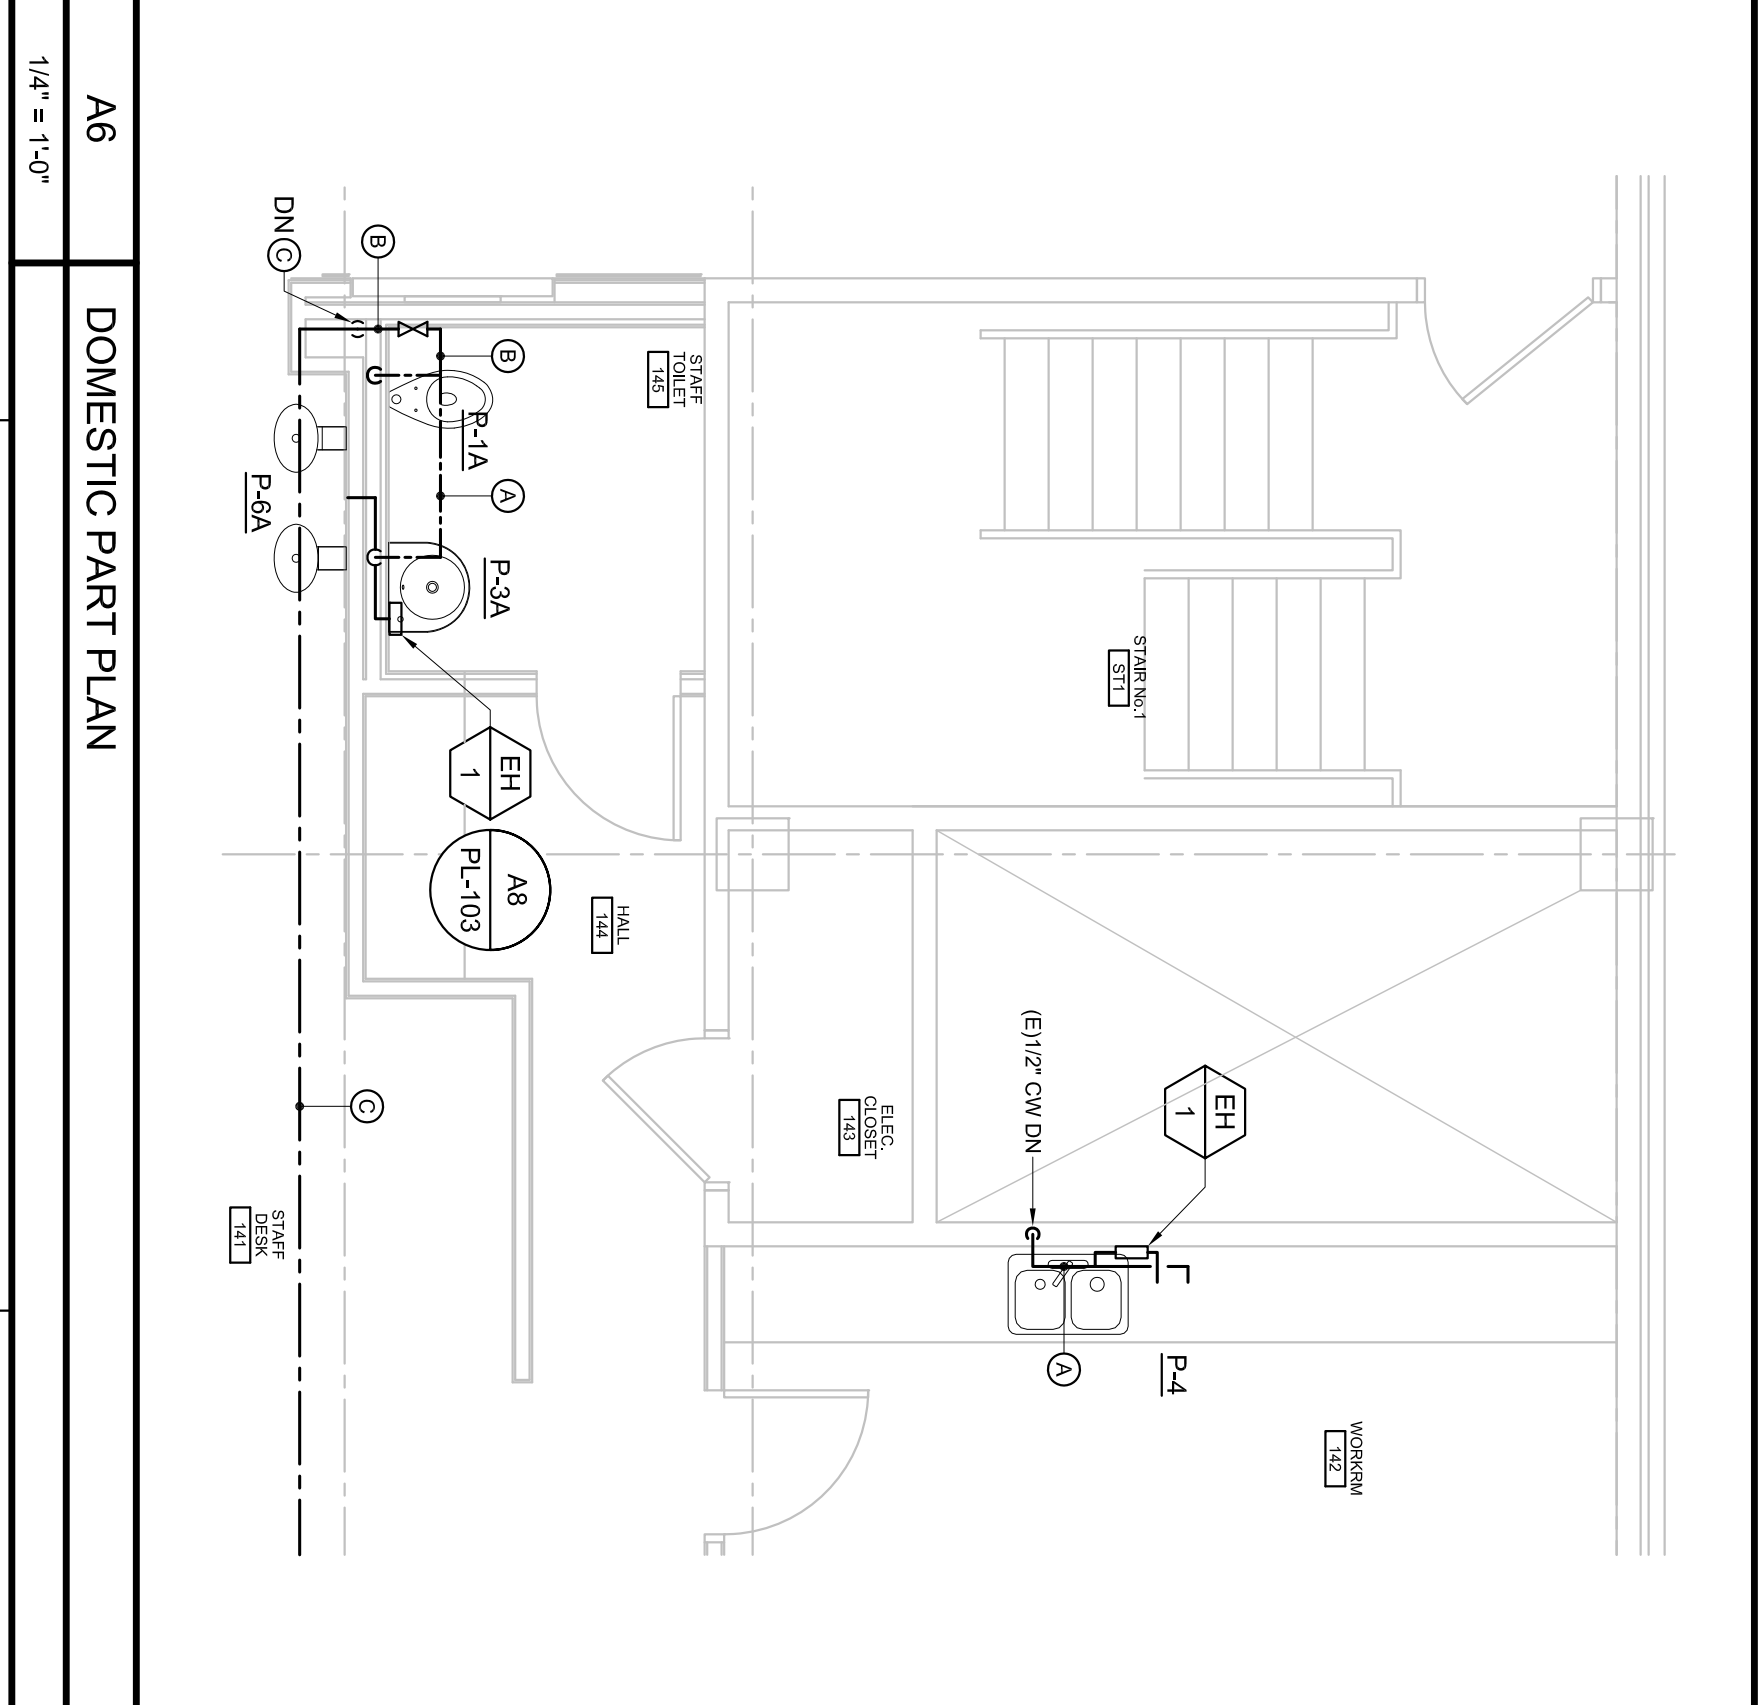
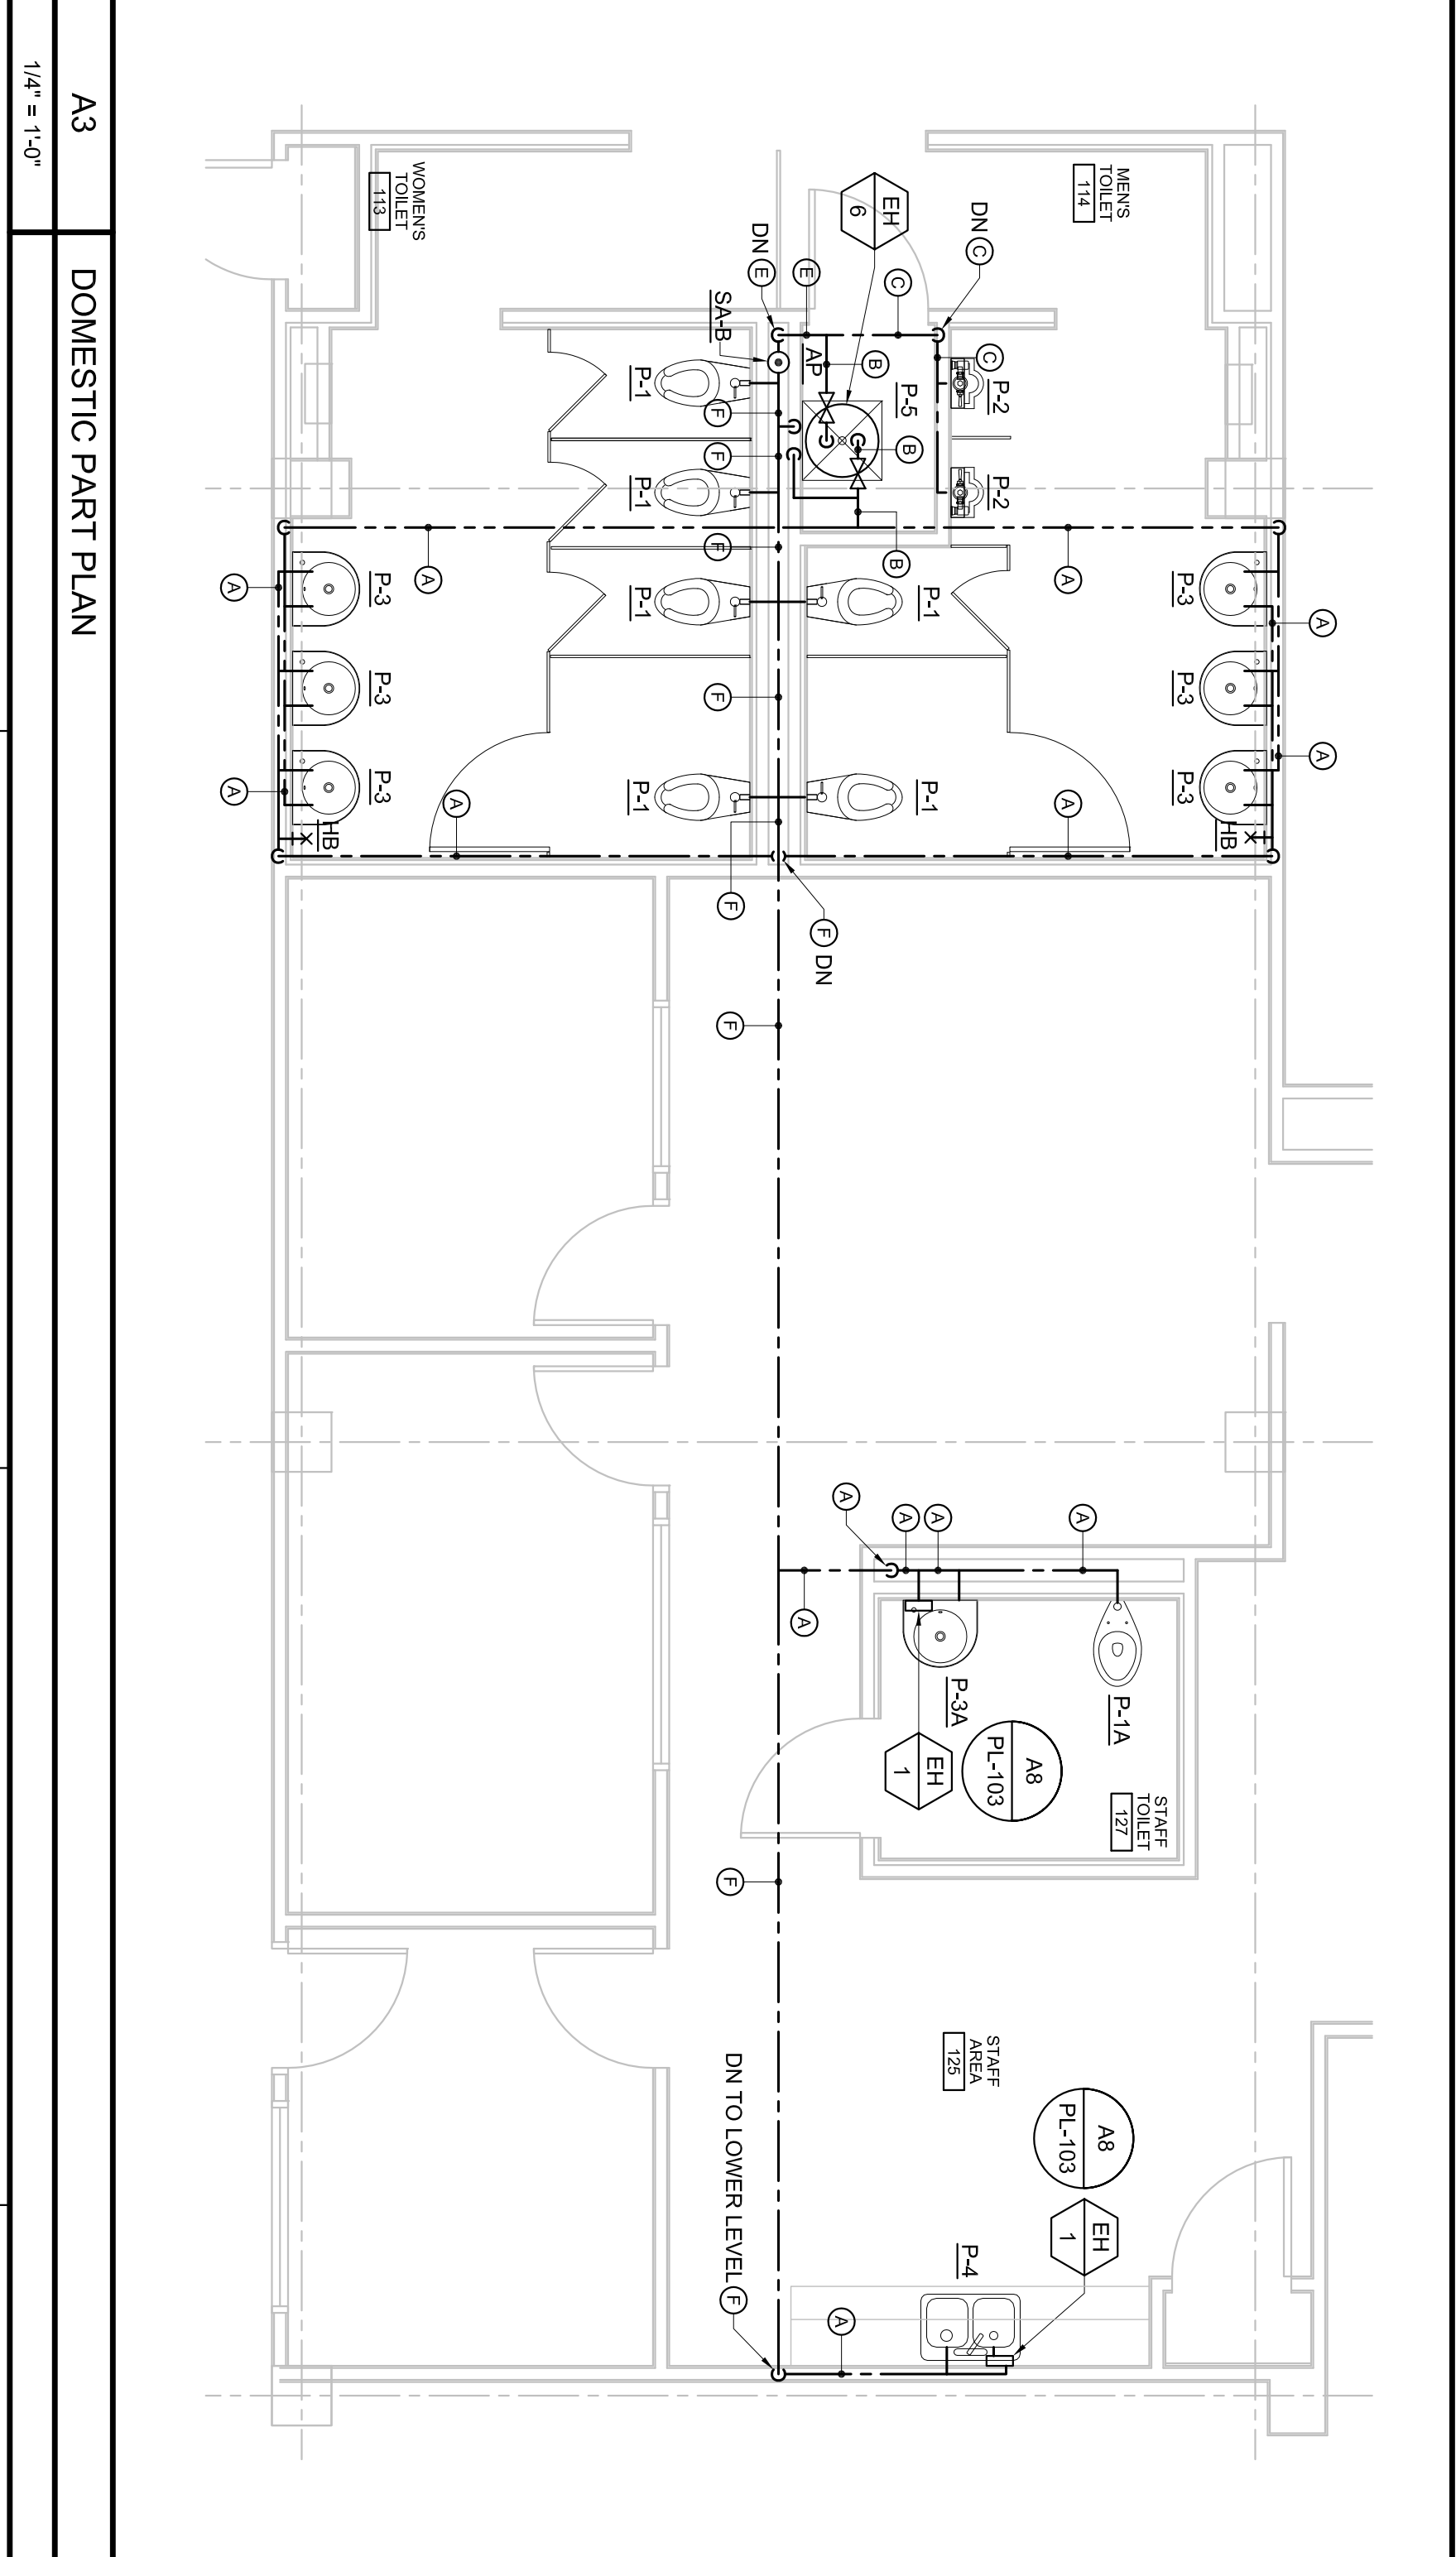


C1 DOMESTIC PIPING PLAN - MAIN LEVEL

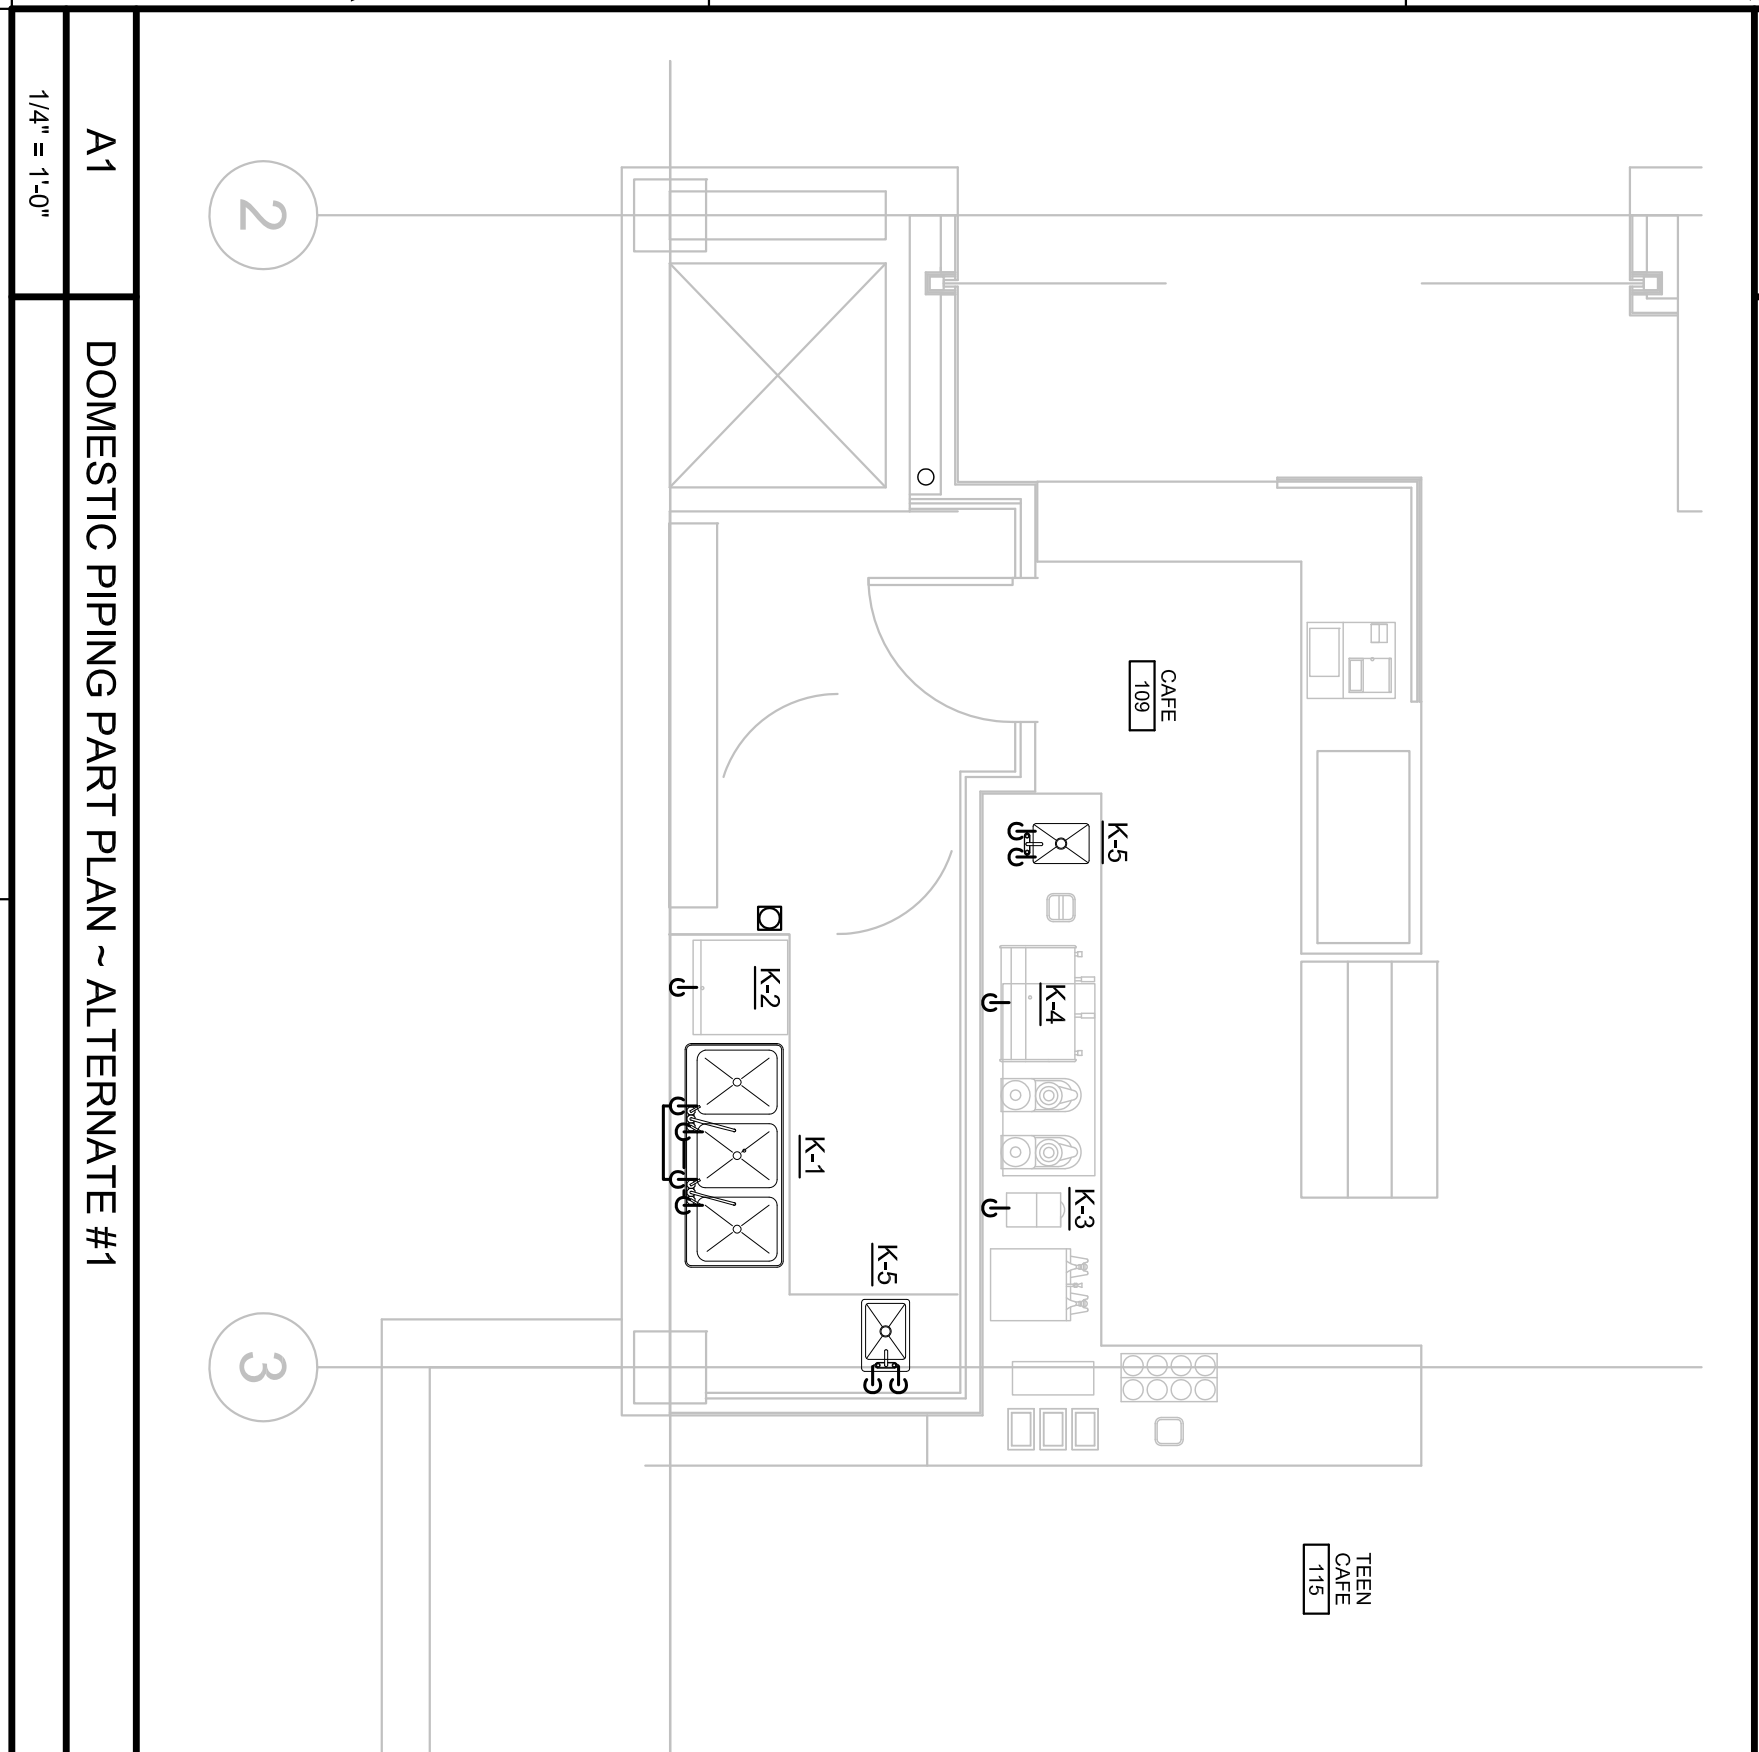

PROJECT
Portland Public Library
Renovation
PORTLAND, ME

TITLE
DOMESTIC PIPING
PLANS
MAIN LEVEL

STATUS:
Issued for Bidding

DATE: 02-13-2009
SCALE:
REVISION DATE:

PROJECT NO.: 08040
DWG NO.: PL-101

DESIGNED BY: [Signature]
CHECKED BY: [Signature]
DRAWN BY: [Signature]

ALLIED ENGINEERING
160 Veranda Street
Portland, Maine 04103
Tel: 207.721.1250
Web: www.allied-eng.com

SSR
Scott Skyles A/E/C/IT/1
7750 State Avenue 04101
Portland, Maine 04101
Tel: 207.627.4800
Web: www.ssrarchitects.com

THIS DRAWING IS THE PROPERTY OF
SCOTT SKYLES ARCHITECTS
REPRODUCED IN PART OR WHOLE