
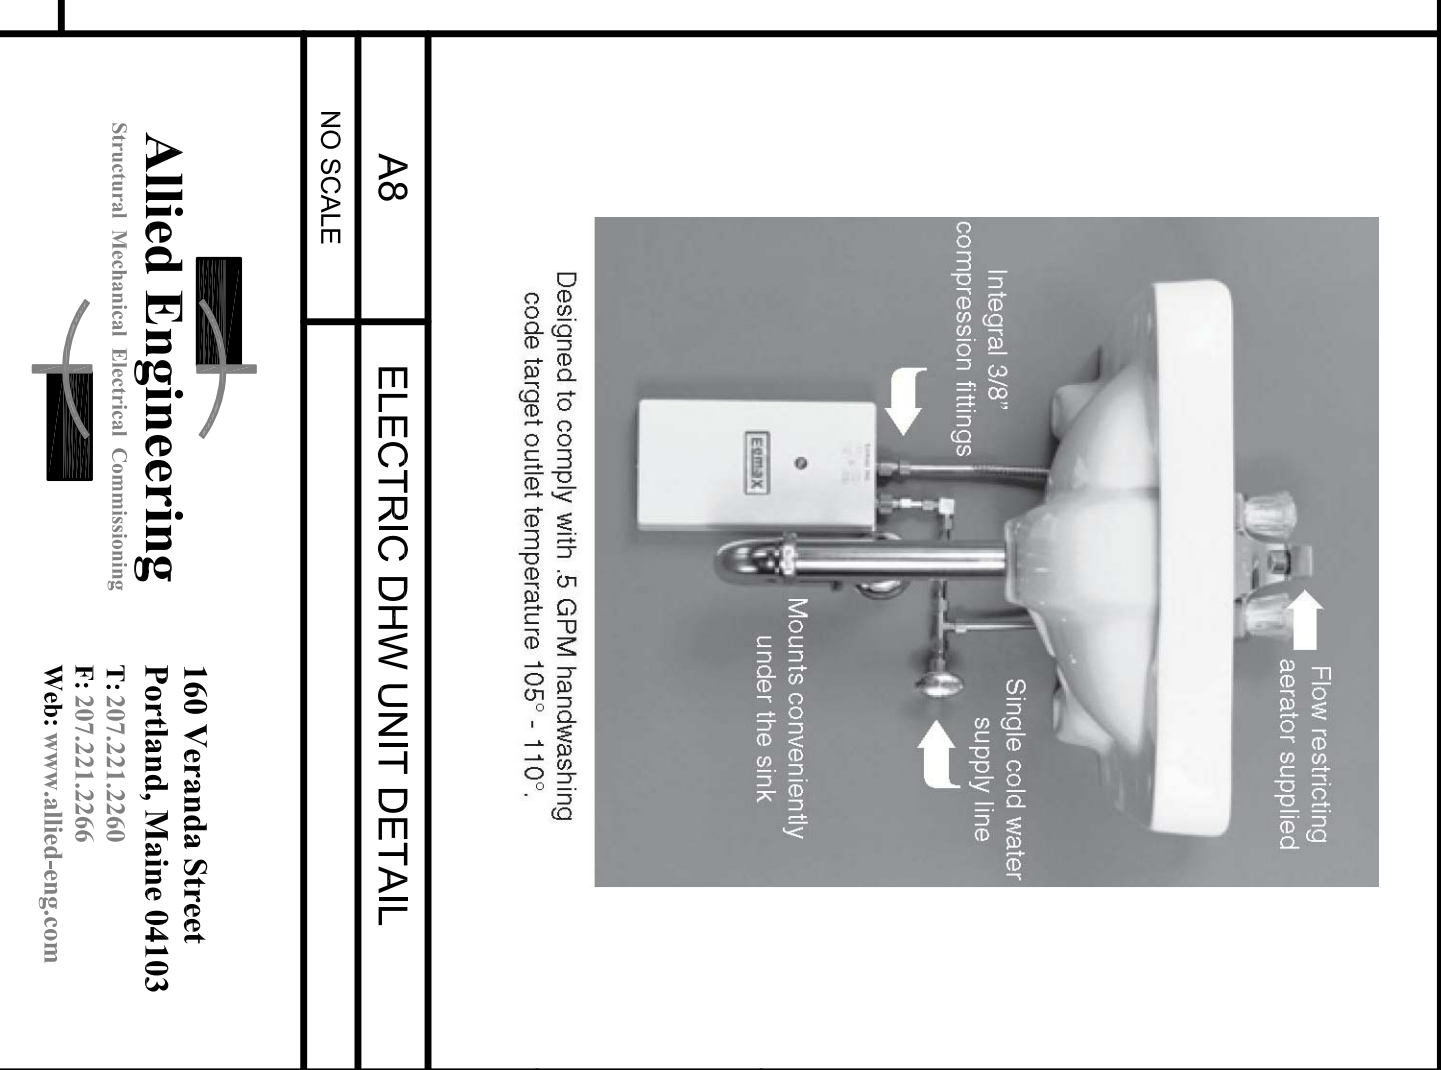
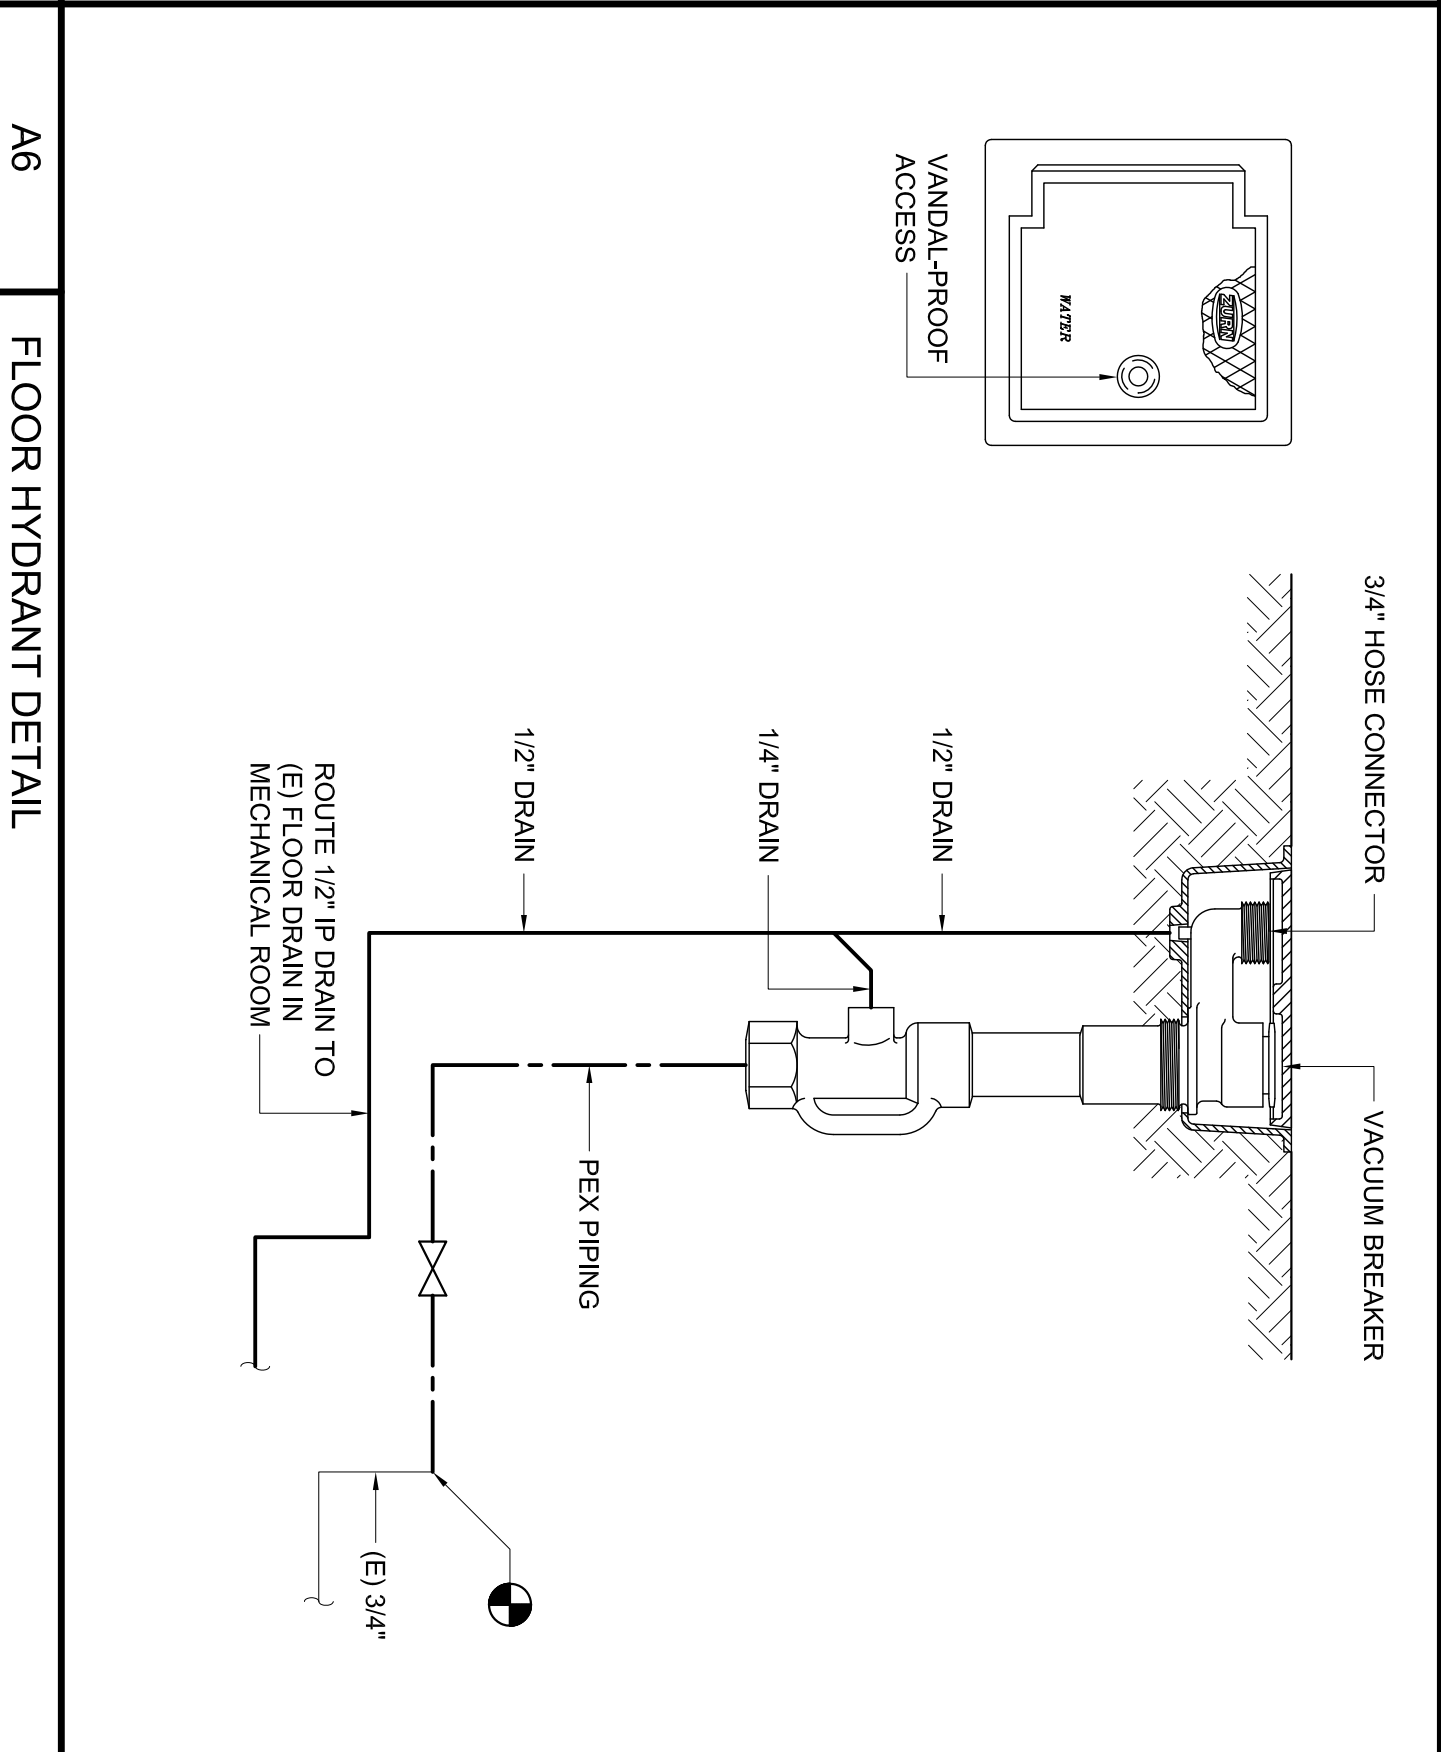
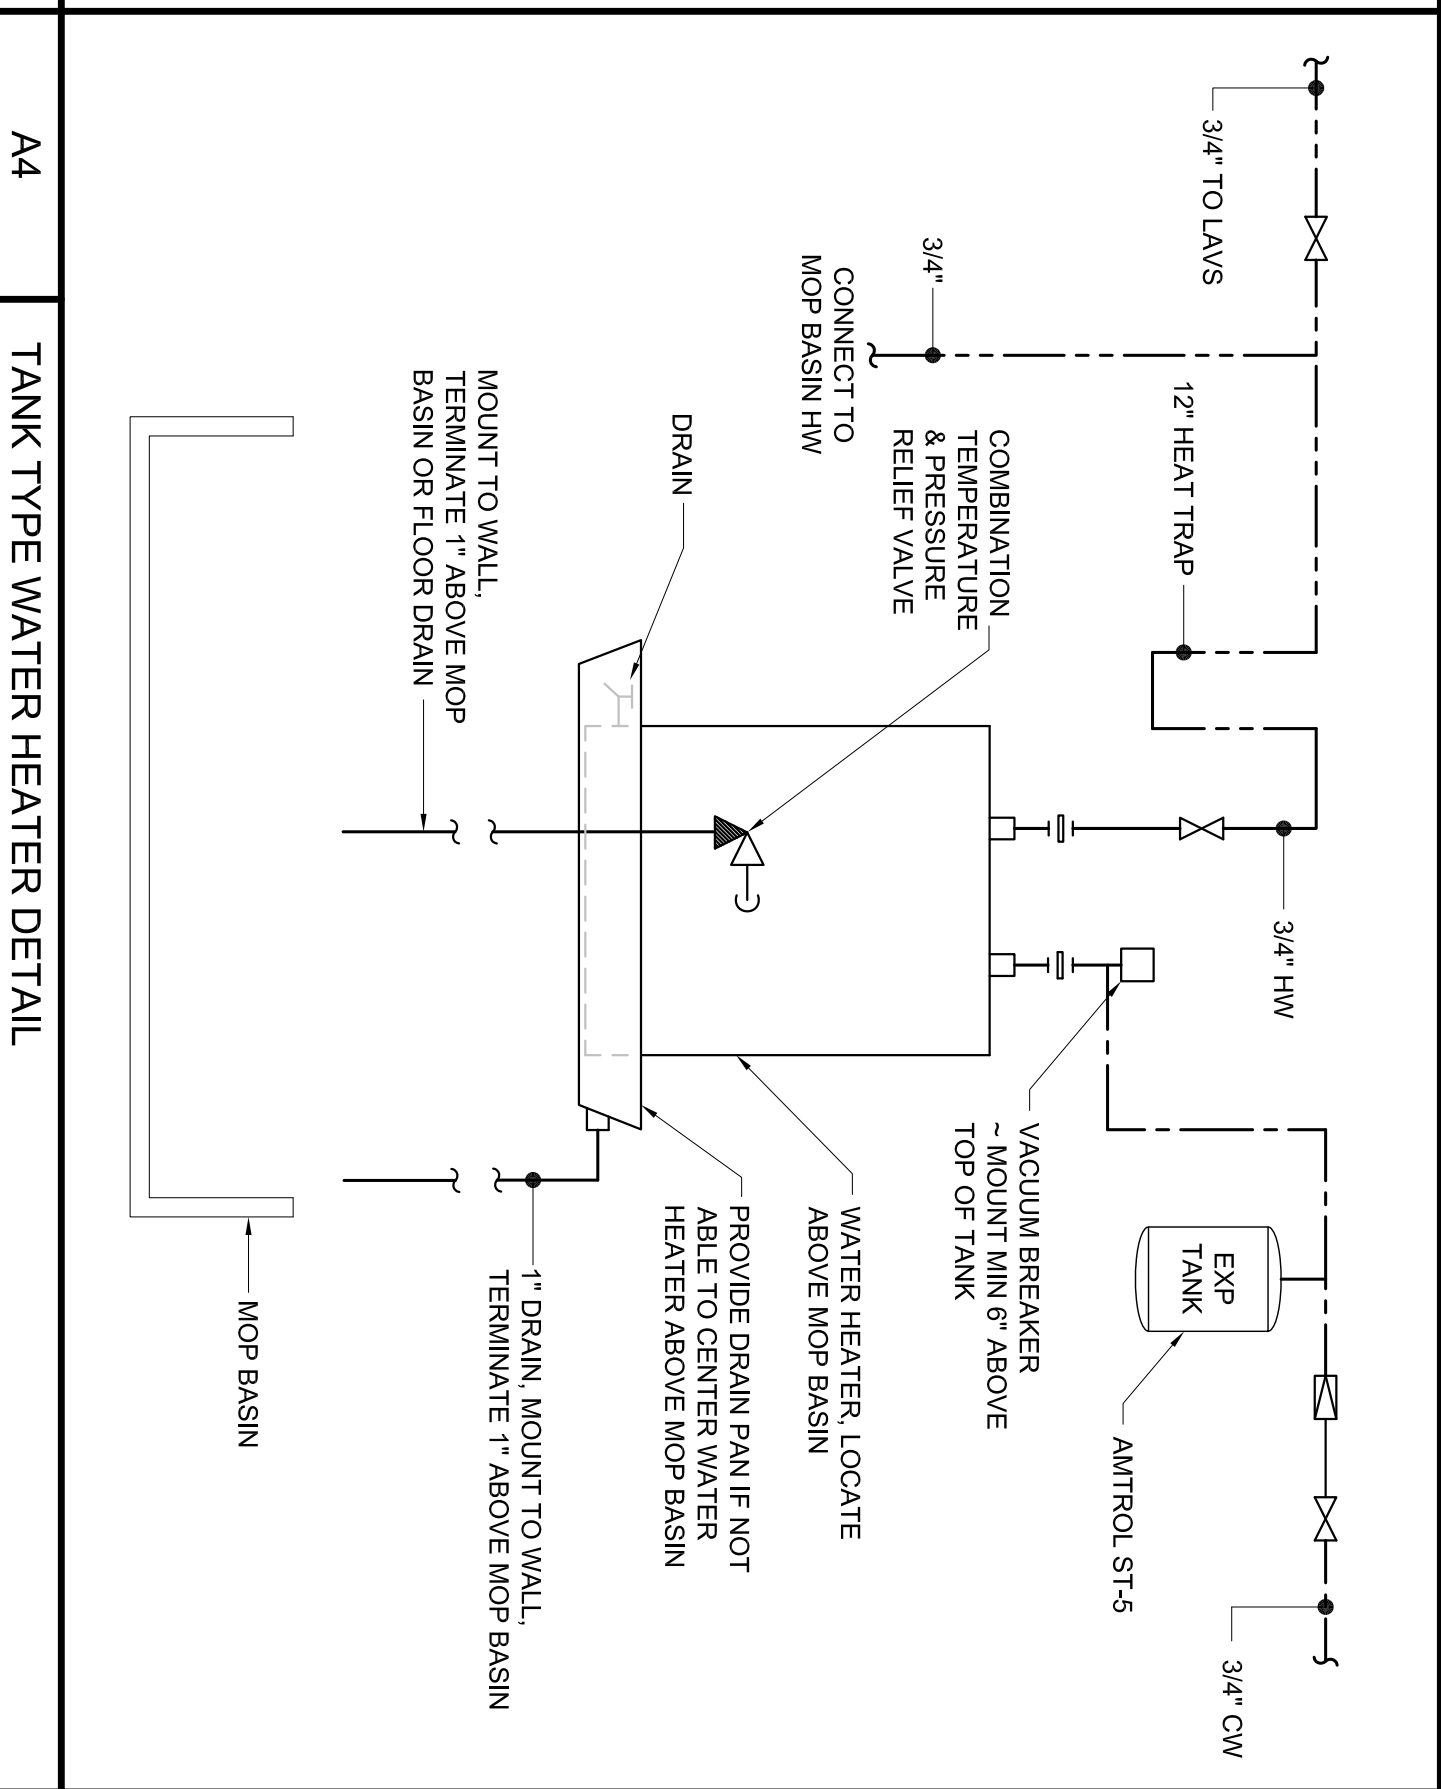
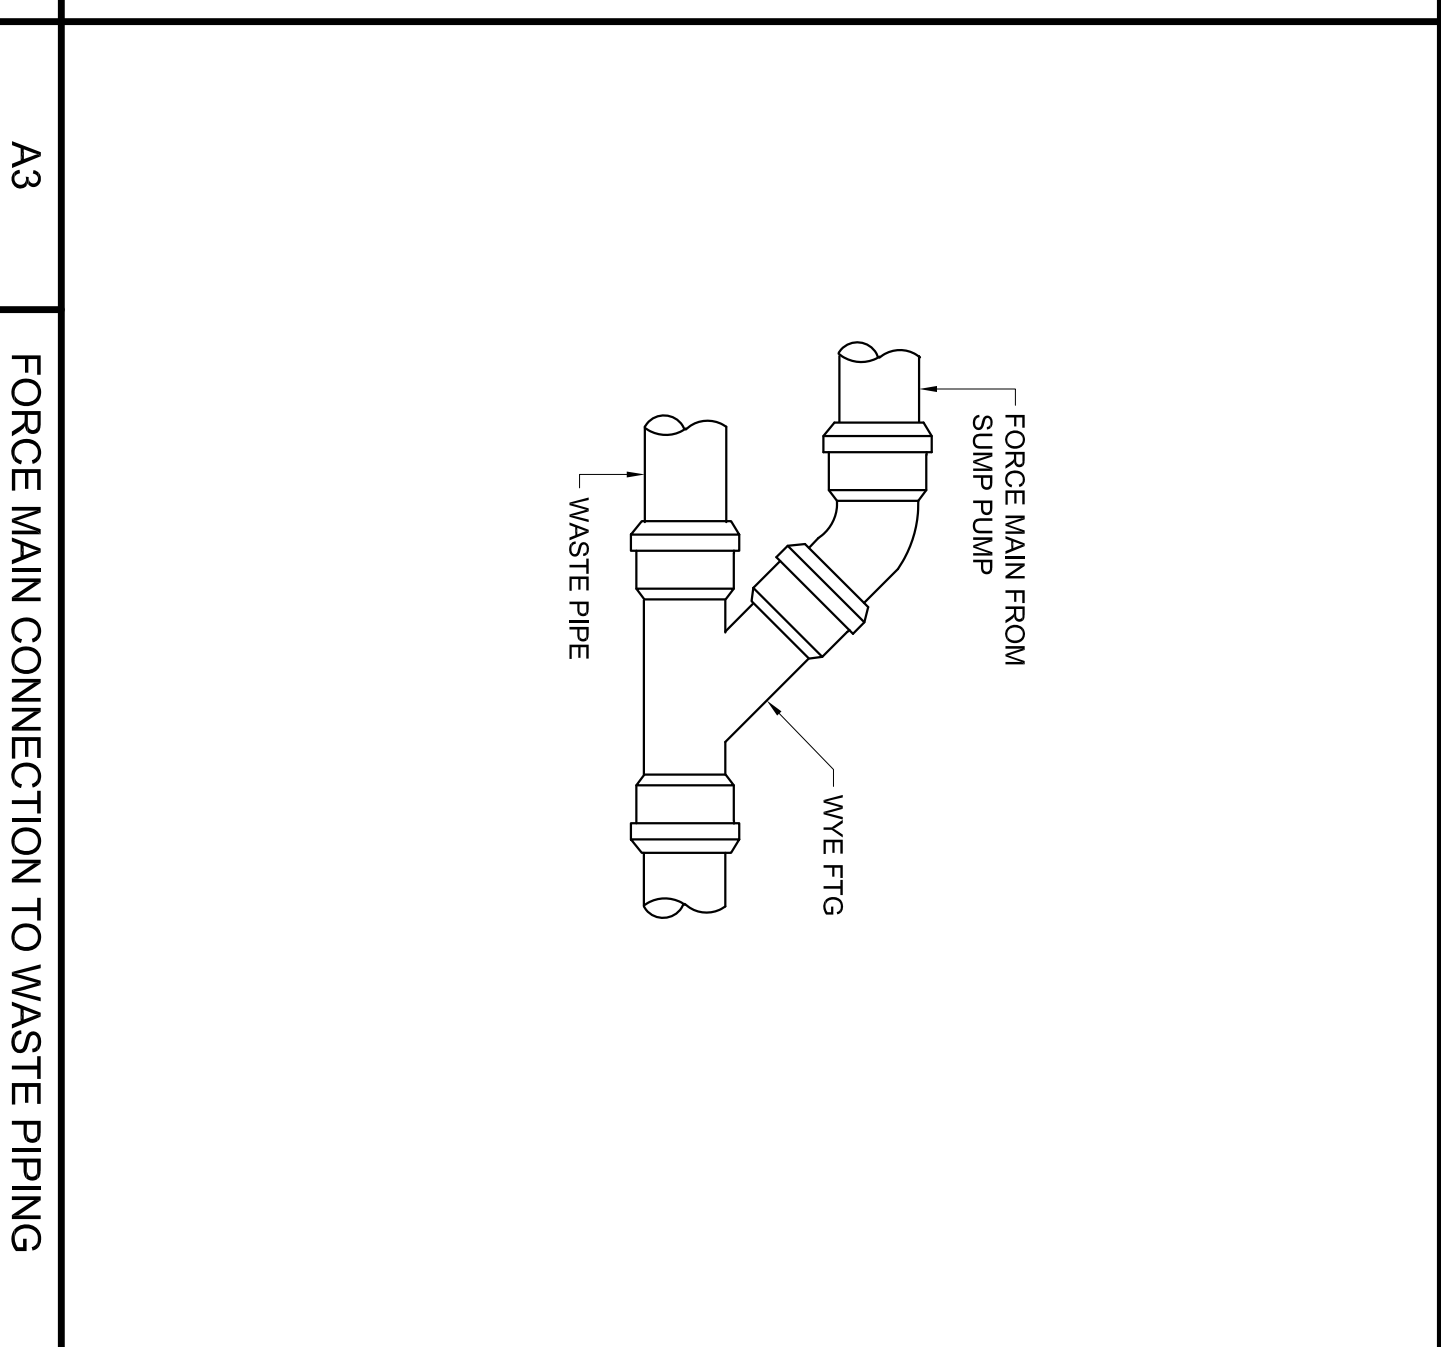


C1 PLUMBING PART PLAN - LEVEL 3

1/8" = 1'-0"

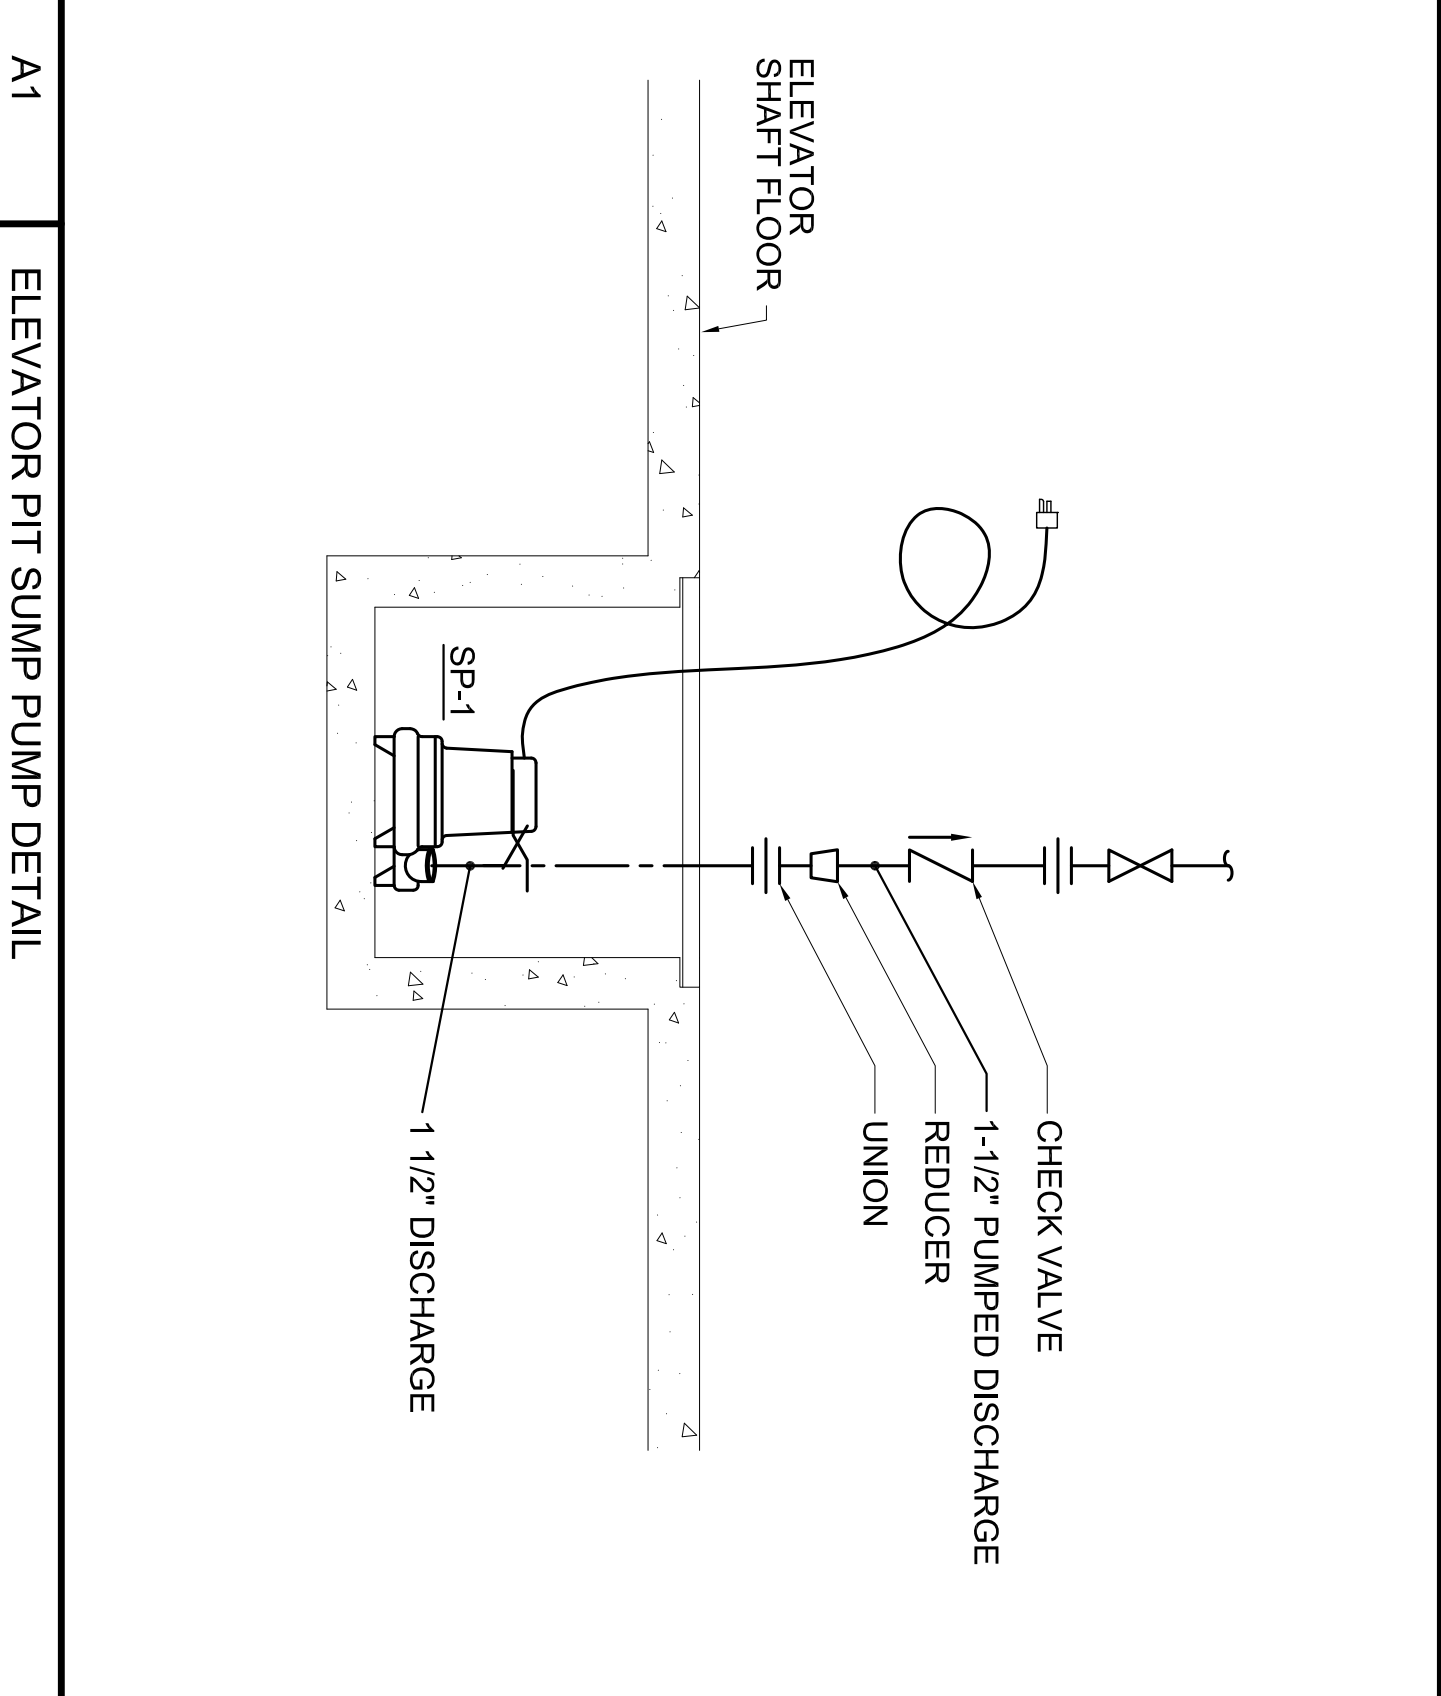

PROJECT: Portland Public Library Renovation, PORTLAND, ME

TITLE: PLUMBING PLAN LEVEL 3 AND DETAILS

STATUS: Issued for Bidding

DATE: 02-13-2009  
SCALE: AS SHOWN  
DRAWN BY: [Signature]  
CHECKED BY: [Signature]

ALLIED ENGINEERING  
160 Veranda Street  
Portland, Maine 04103  
Tel: 207.721.1244  
Web: www.allied-eng.com

SCOTT SMITH ARCHITECTS  
77 South Street  
Portland, Maine 04101  
Tel: 207.622.4888  
Web: www.scottsmitharchitects.com

DWG NO: PL-103

C8 ROOF DRAIN DETAIL

NO SCALE

