



C1 PLUMBING PLAN - LOWER LEVEL

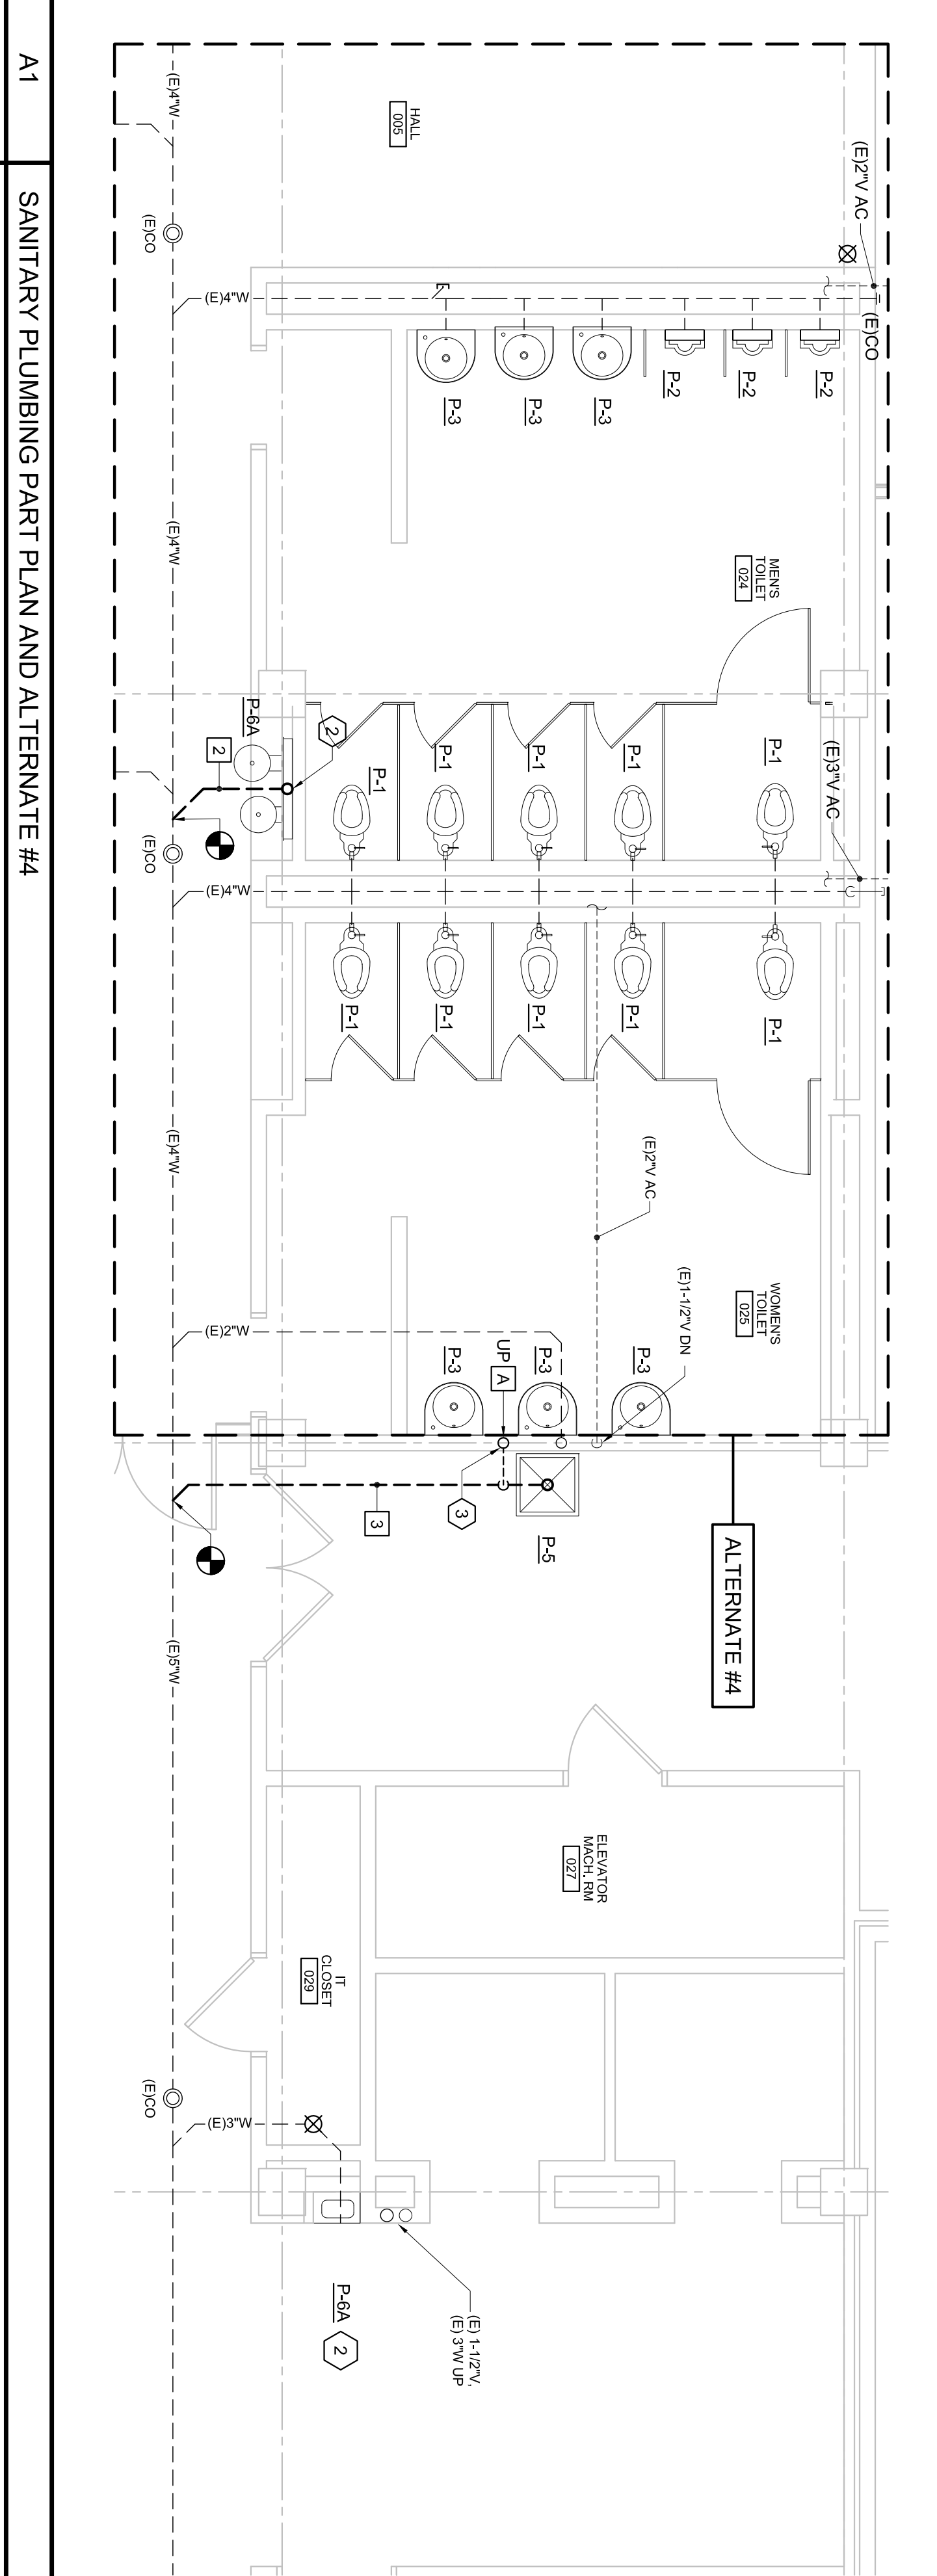

- NOTES:**
1. CONNECT FIXTURES TO (E) WASTE AND VENT PIPING.
  2. PROVIDE CARRIERS FOR URINALS AND WATER CLOSETS AS REQUIRED.
  3. ADJUST (E) PIPING AS REQUIRED FOR NEW WALL AND FLOOR FINISHES.

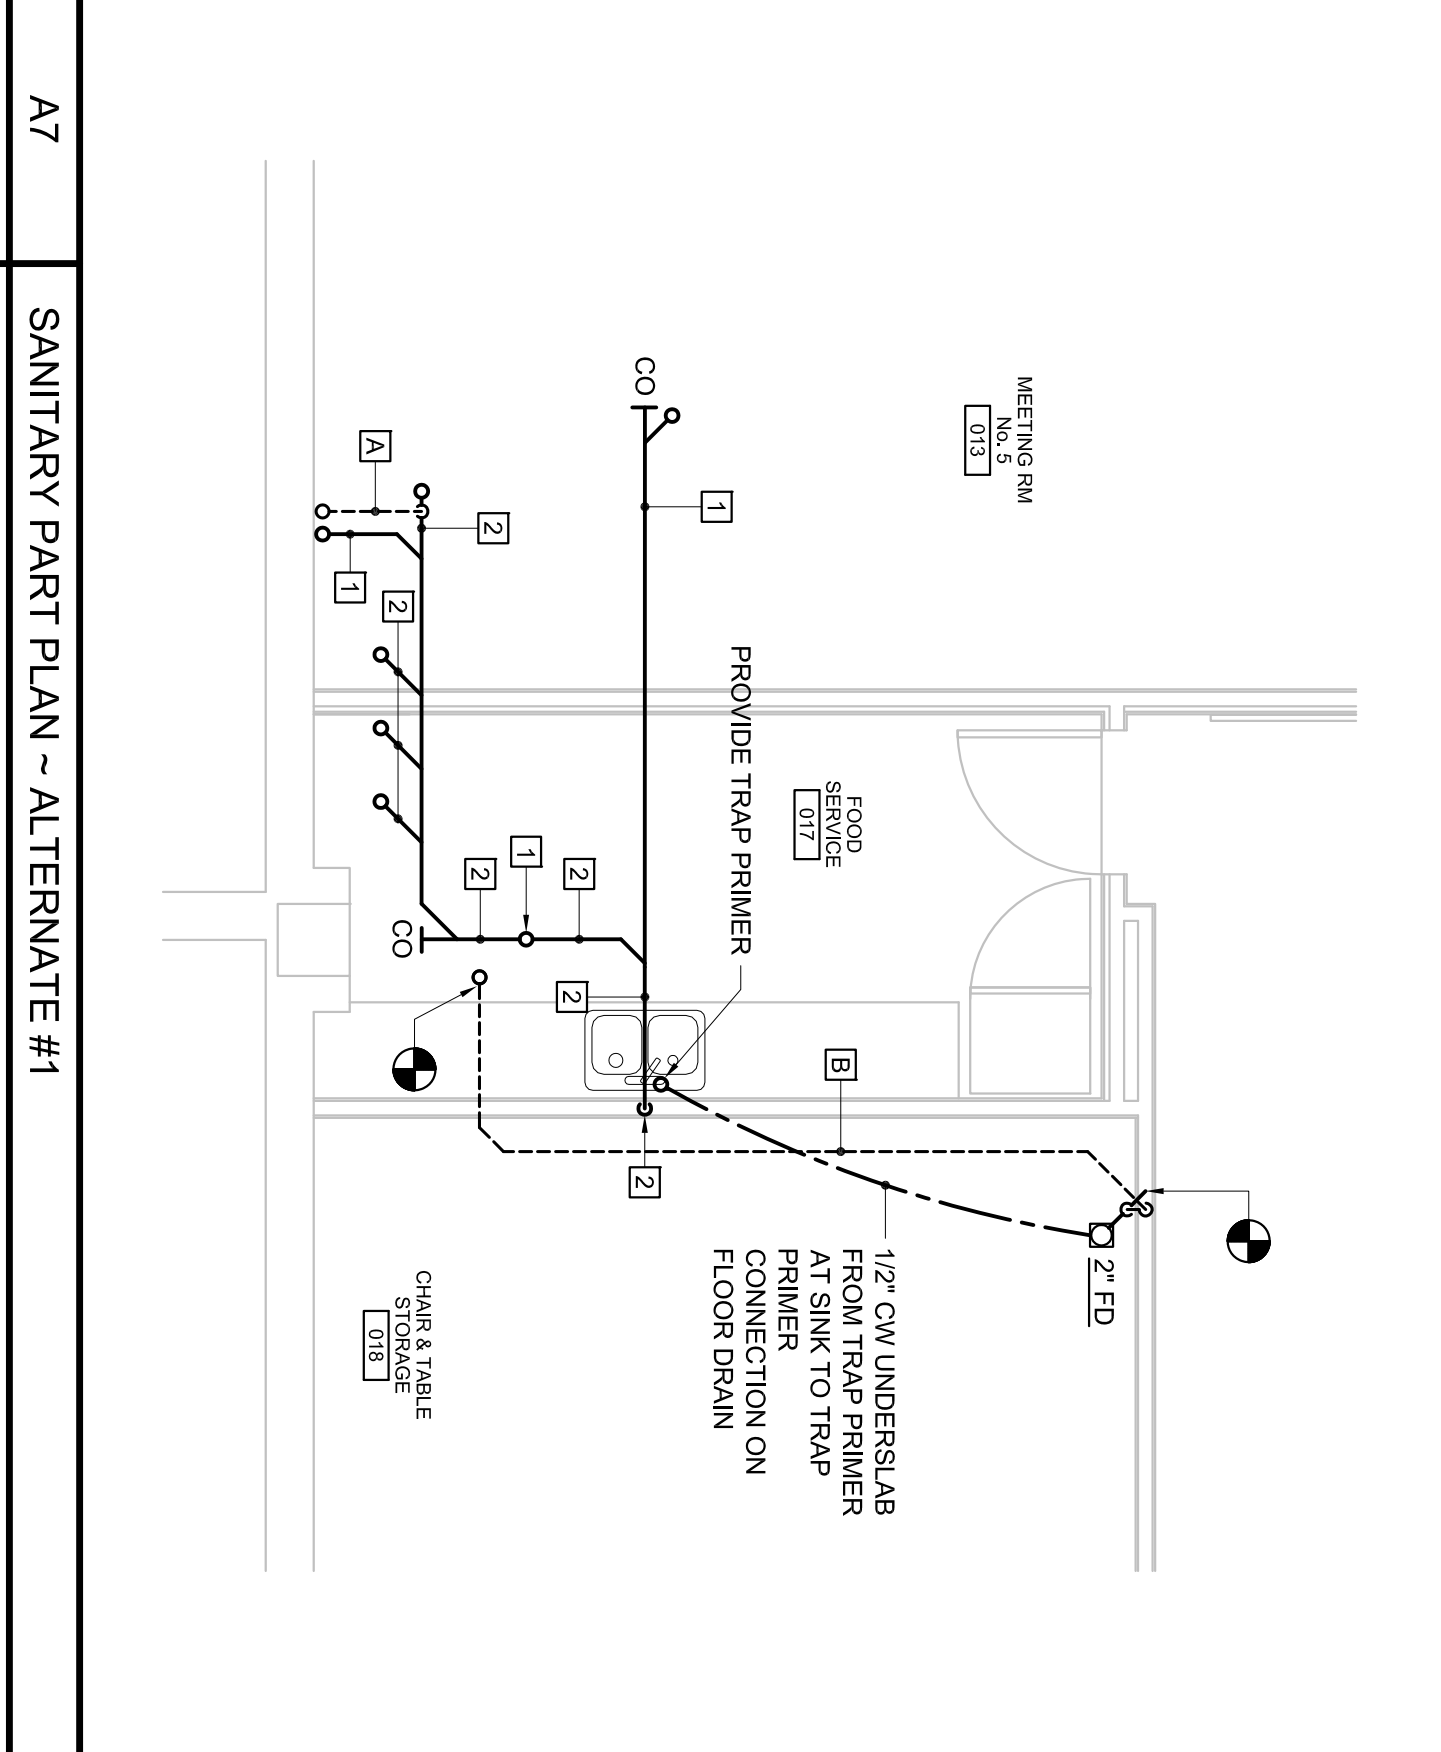

<p><b>PROJECT</b> Portland Public Library Renovation PORTLAND, ME</p>		<p><b>STATUS:</b> Issued for Bidding</p>																					
<p><b>TITLE</b> SANITARY PIPING PLANS LOWER LEVEL</p>		<p><b>DATE:</b> 02-13-2009</p> <p><b>SCALE:</b> AS SHOWN</p> <p><b>DESIGNED BY:</b> [Signature]</p> <p><b>DRAWN BY:</b> [Signature]</p> <p><b>DWG NO.:</b> PS-100</p>																					
<p><b>KEY NOTES</b></p> <ol style="list-style-type: none"> <li>1. CONNECT DRINKING FOUNTAIN TO (E) WASTE AND VENT PIPING FROM REMOVED DRINKING FOUNTAIN.</li> <li>2. CONNECT DRINKING FOUNTAIN VENT TO (E) VENT PIPING IN CHASE.</li> <li>3. CONNECT MOP BASIN VENT TO (E) VENT PIPING IN CHASE.</li> </ol>		<p><b>SALE PIPE SIZES:</b></p> <table border="1"> <tr><td>1"</td><td>1 1/2"</td></tr> <tr><td>2"</td><td>3"</td></tr> <tr><td>3"</td><td>4"</td></tr> <tr><td>4"</td><td>6"</td></tr> <tr><td>6"</td><td>8"</td></tr> <tr><td>8"</td><td>10"</td></tr> <tr><td>10"</td><td>12"</td></tr> <tr><td>12"</td><td>18"</td></tr> <tr><td>18"</td><td>24"</td></tr> <tr><td>24"</td><td>30"</td></tr> </table>		1"	1 1/2"	2"	3"	3"	4"	4"	6"	6"	8"	8"	10"	10"	12"	12"	18"	18"	24"	24"	30"
1"	1 1/2"																						
2"	3"																						
3"	4"																						
4"	6"																						
6"	8"																						
8"	10"																						
10"	12"																						
12"	18"																						
18"	24"																						
24"	30"																						
<p><b>ALLIED ENGINEERING</b> 160 Veranda Street Portland, Maine 04103 Tel: 207.733.1234 Web: www.allied-eng.com</p>		<p><b>SSA</b> Scott Skyles Architects 77 York Street, Suite 401 Portland, ME 04101 Tel: 207.622.4699 Web: www.sskyles.com</p>																					