



C1
SANITARY PLAN - MAIN LEVEL

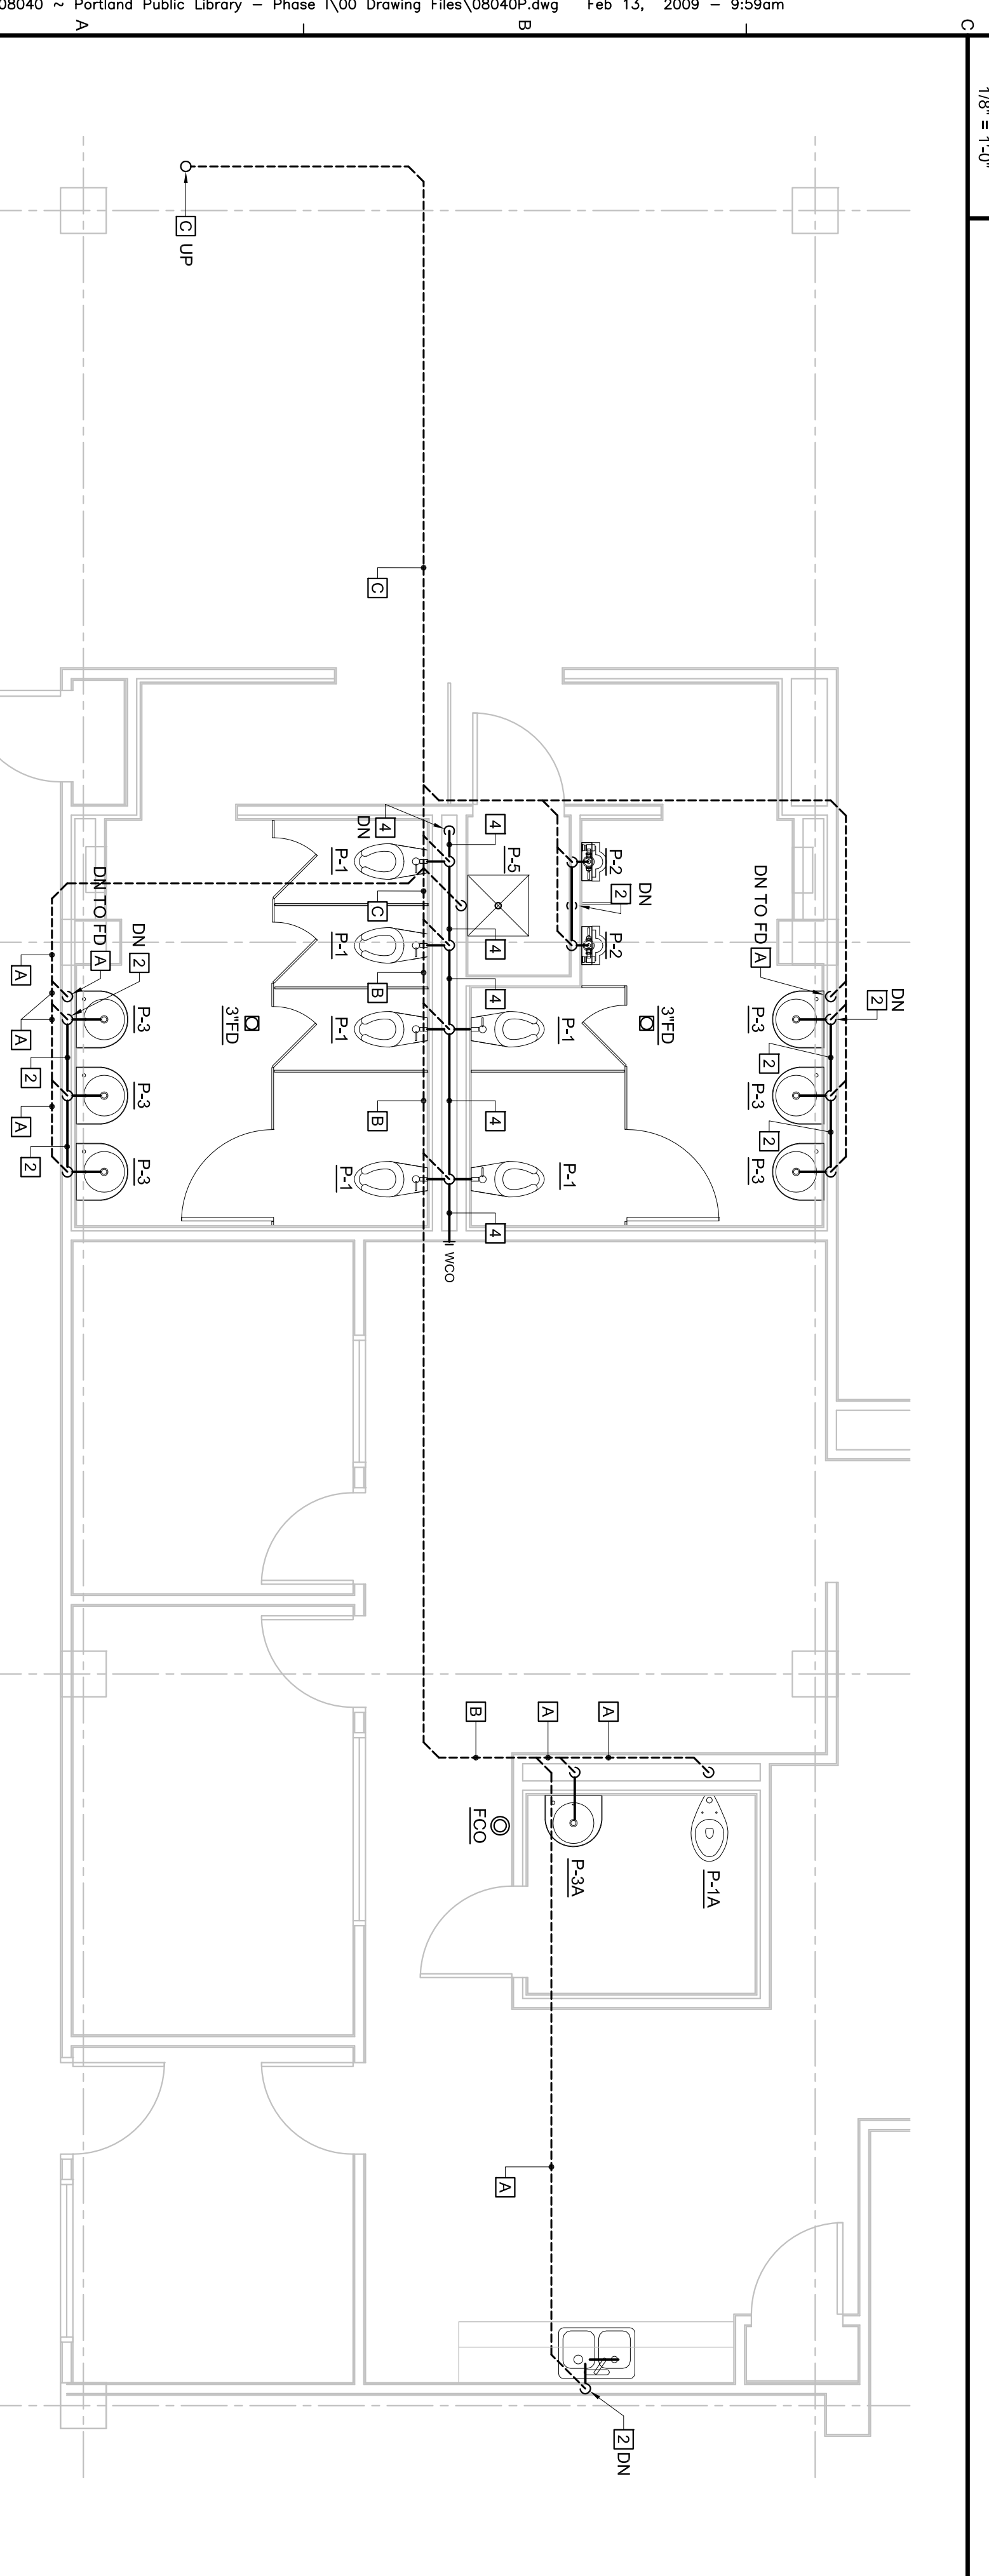

A1
SANITARY PART PLAN - MAIN LEVEL

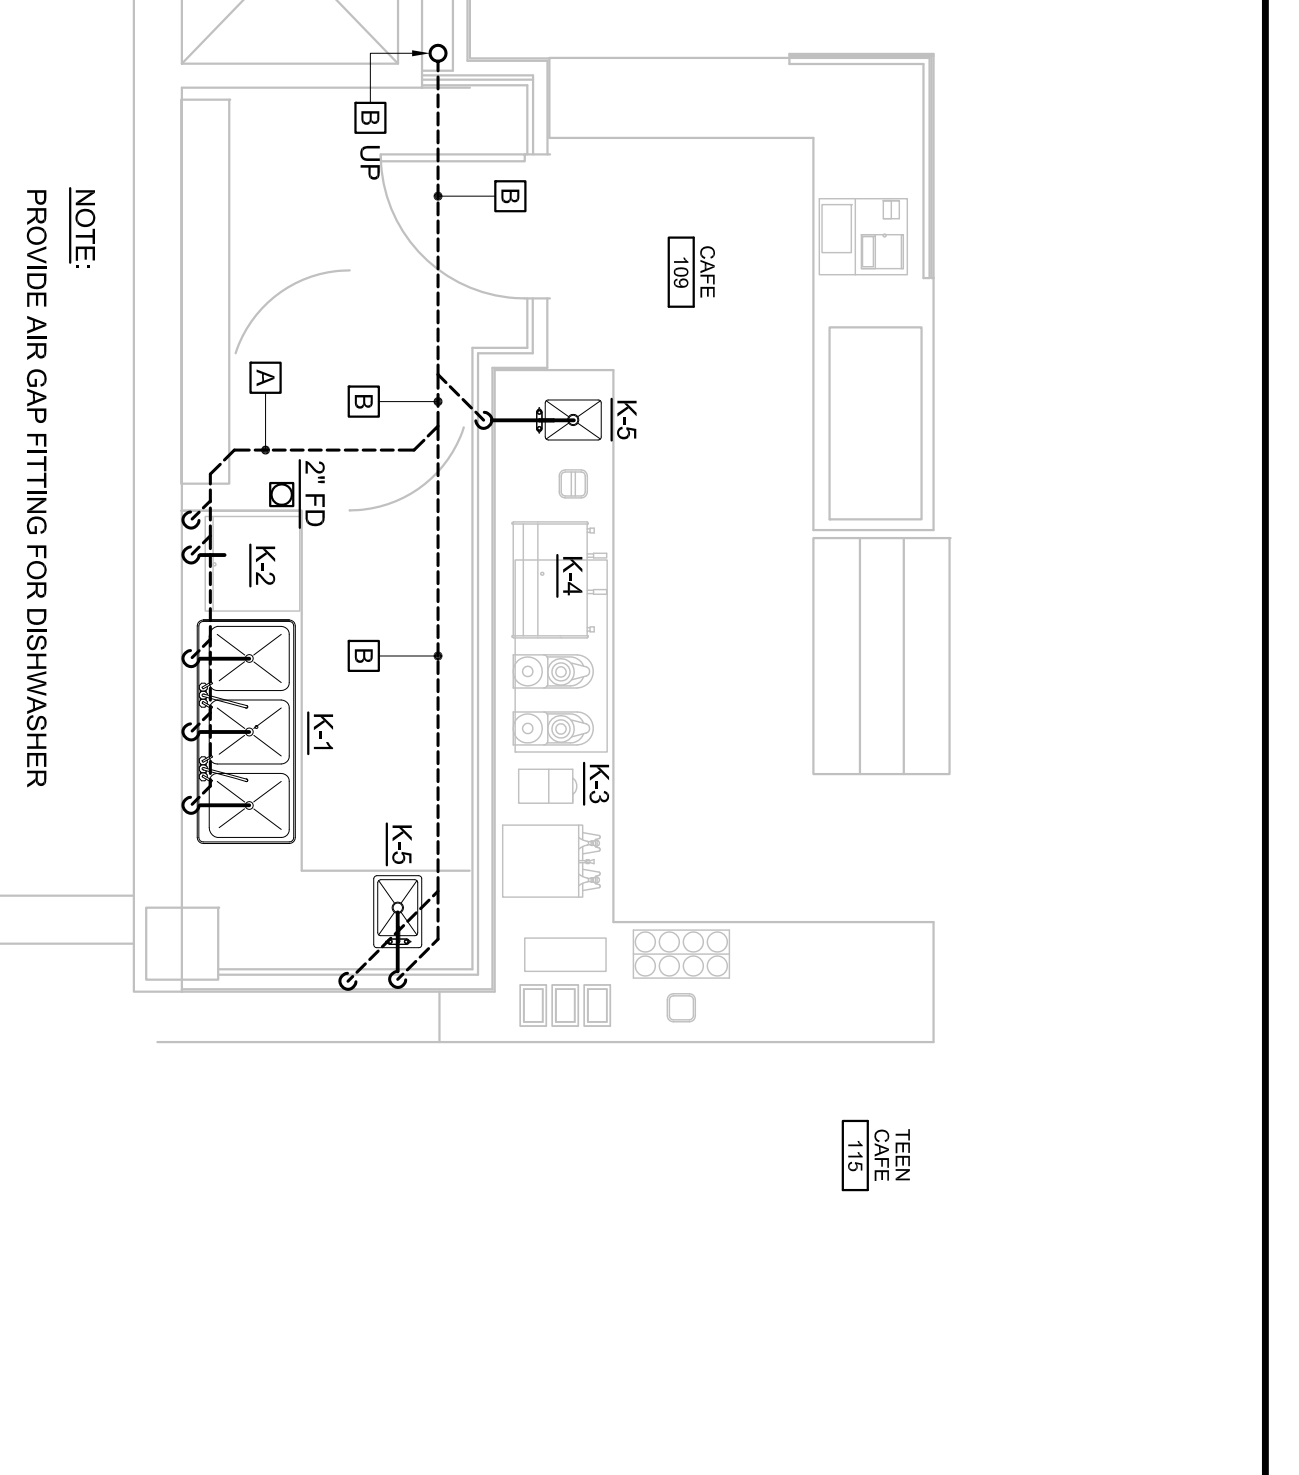

NOTE:
PROVIDE AIR GAP FITTING FOR DISHWASHER

A5
SANITARY PART PLAN - ALTERNATE NO 1

SAN PIPE SIZES		
1	1-1/2"	
2	2"	
3	3"	
4	4"	
5	6"	
6	8"	
7	10"	
8	12"	
9	14"	
10	16"	
11	18"	
12	20"	
13	24"	
14	30"	
15	36"	
16	42"	
17	48"	
18	54"	
19	60"	
20	72"	

PROJECT
Portland Public Library
Renovation
PORTLAND, ME

TITLE
SANITARY PIPING
PLANS
MAIN LEVEL

THIS DRAWING IS THE PROPERTY OF SCOTT SMITH ARCHITECTS. REPRODUCTIONS IN PART OR WHOLE ARE PROHIBITED.

DATE: 02-13-2009
SCALE: AS SHOWN
DRAWN BY: [Name]
CHECKED BY: [Name]
DATE: [Date]

STATUS:
Issued for Bidding

Allied Engineering
160 Veranda Street
Portland, Maine 04103
Tel: 503.733.1254
Web: www.allied-eng.com

Checked By: [Name]

Professional Engineer Seal
Maine State Seal
No. 9898
Scott Smith, PE
7700 South Street
Portland, Maine 04103
Tel: 503.733.1254
Web: www.allied-eng.com

PS-101