
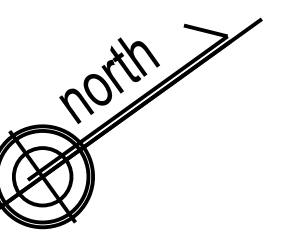


Winton Scott Architects  
 5 Milk Street  
 Portland, Maine 04101  
 207 774 4811  
 www.wintonsscott.com

Architecture / Planning  
 Preservation Architecture  
 Interior Architecture

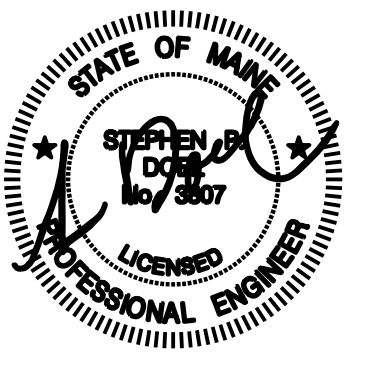

ISSUED  
 FOR  
 PERMIT  
 ONLY  
 3-30-16

Structural Engineer  
 Structural Integrity Consulting  
 Engineers, Inc.

Mechanical / Electrical  
 Engineer

Owner  
 Northland Enterprises  
 LLC.

443 Congress


Portland, Maine

Third Floor  
 Plumbing Plan

1/4" = 1'-0"

M 2.3

MARCH 30, 2016

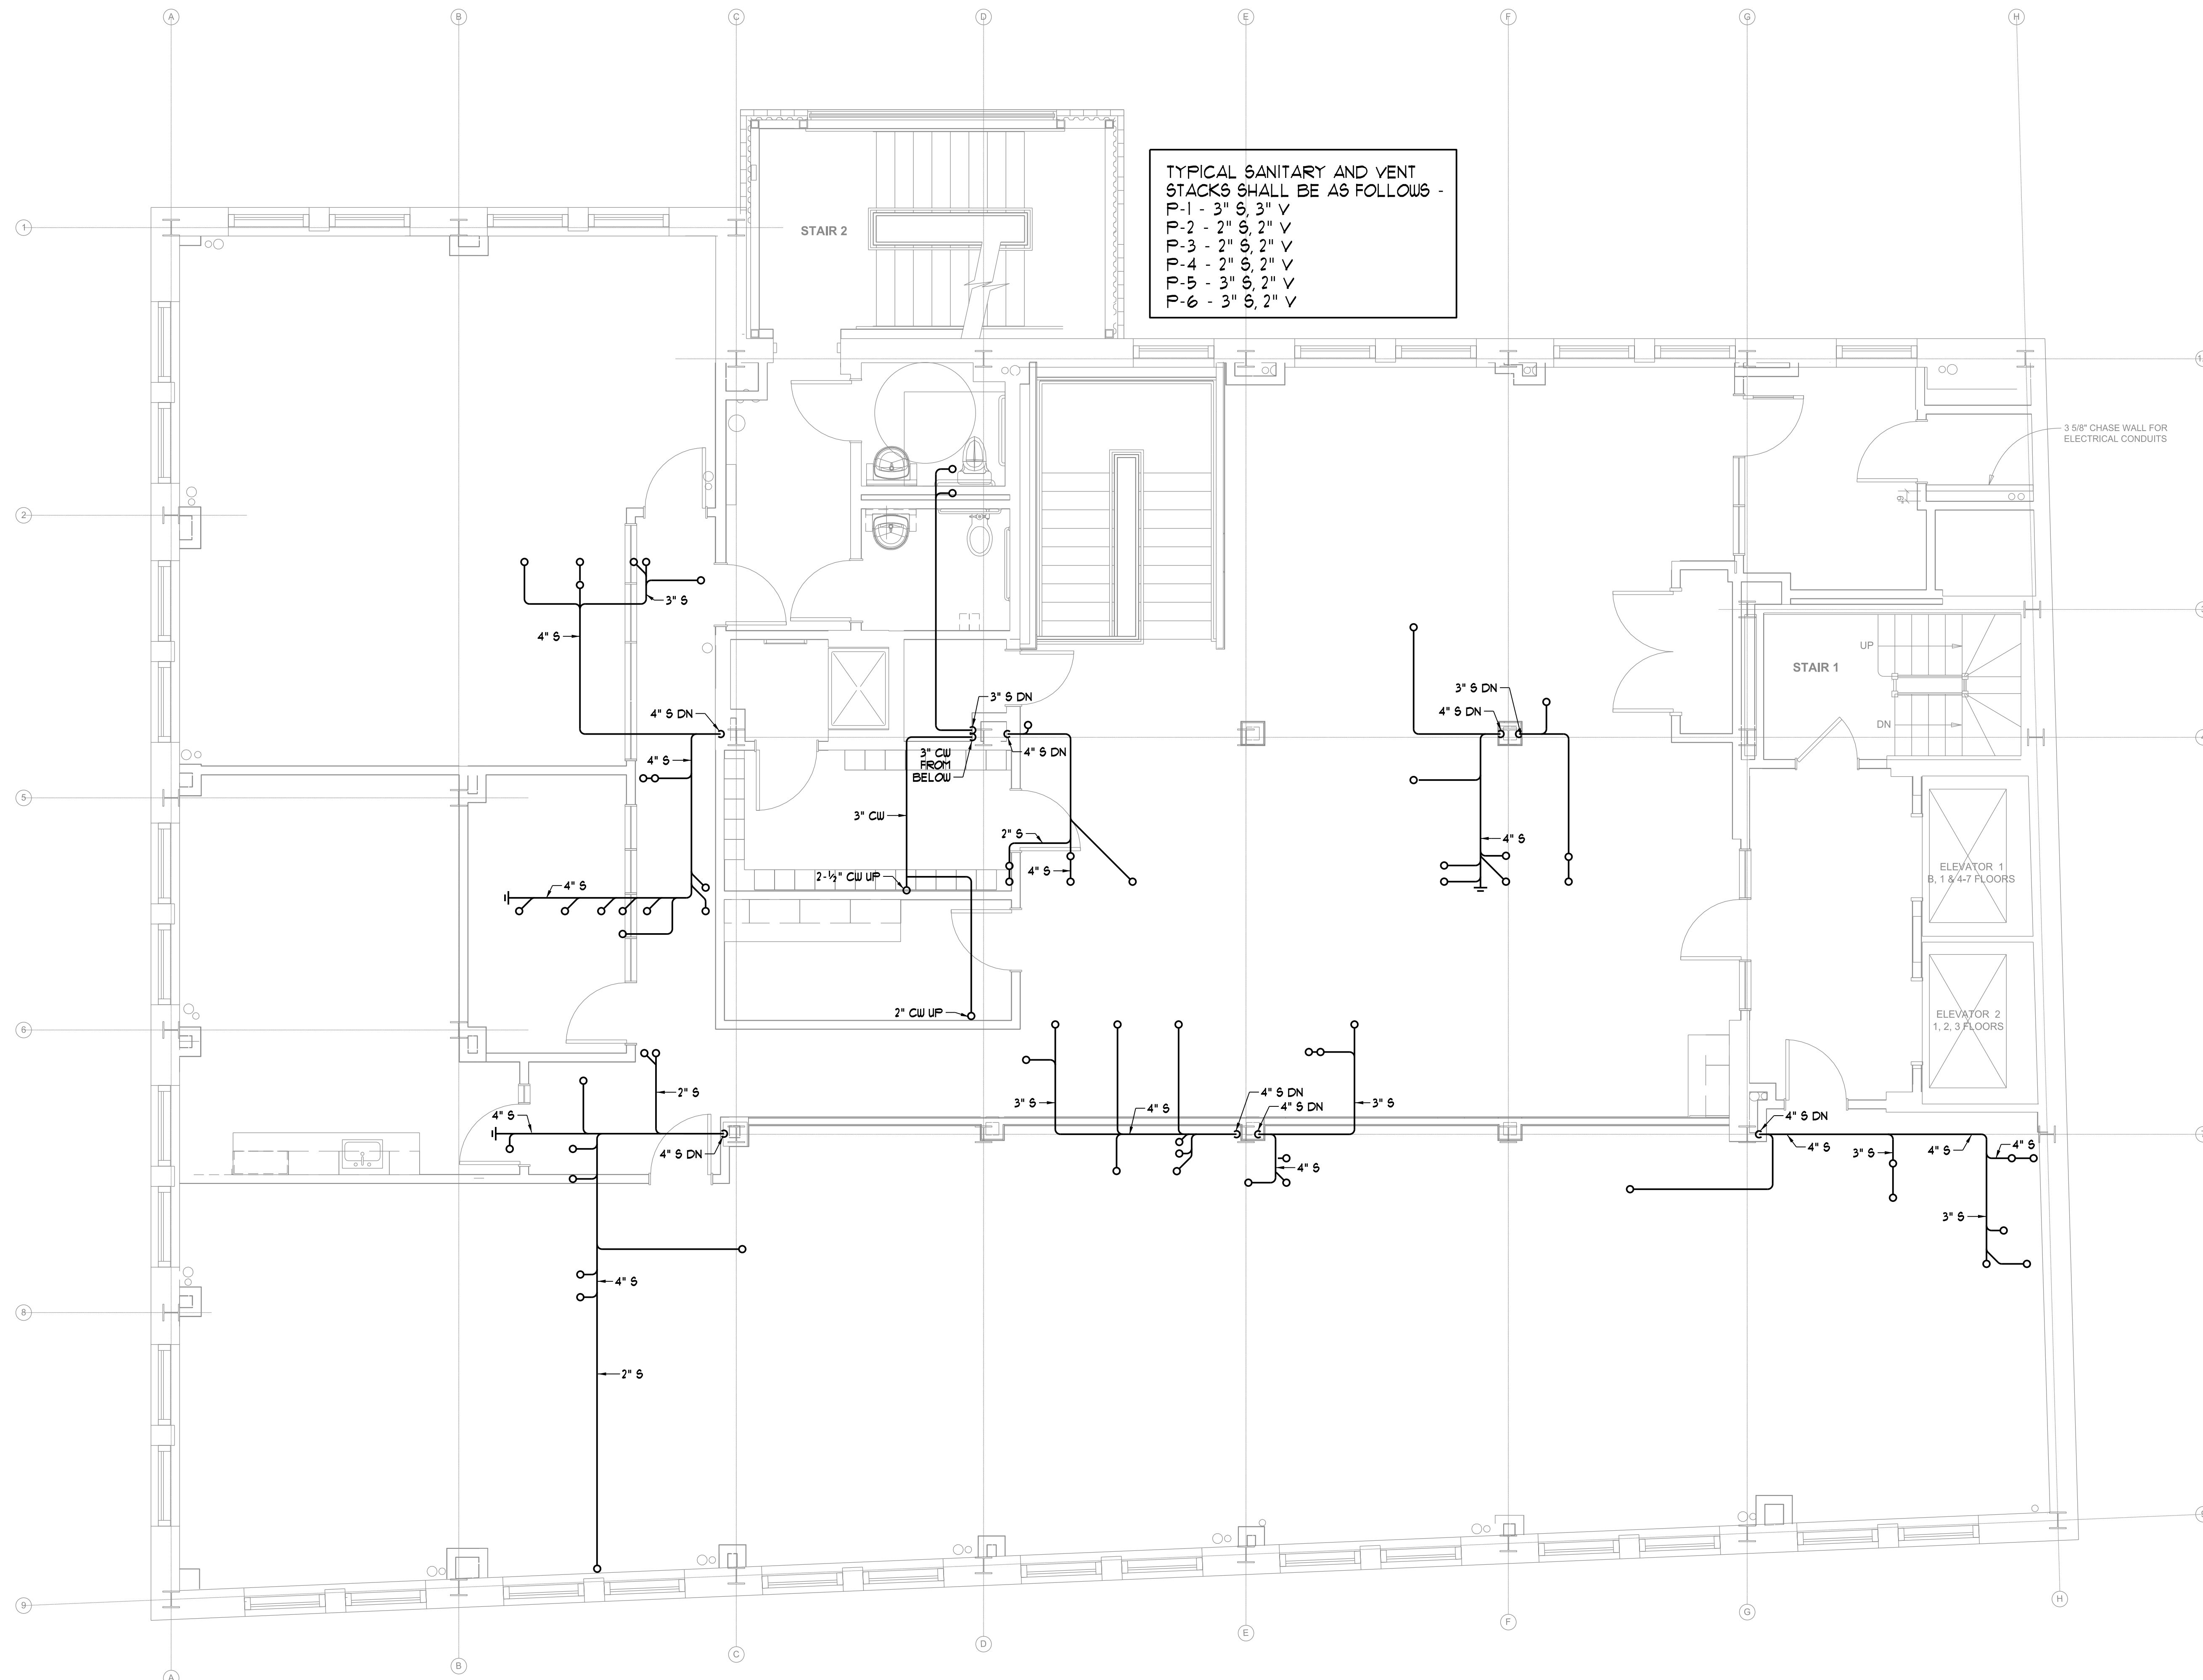

TYPICAL SANITARY AND VENT  
 STACKS SHALL BE AS FOLLOWS -  
 P-1 - 3" S, 3" V  
 P-2 - 2" S, 2" V  
 P-3 - 2" S, 2" V  
 P-4 - 2" S, 2" V  
 P-5 - 3" S, 2" V  
 P-6 - 3" S, 2" V

THIRD FLOOR PLUMBING PLAN  
 SCALE - 1/4" = 1'-0"