
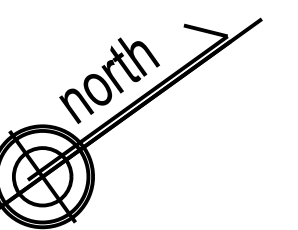


Winton Scott Architects
 5 Milk Street
 Portland, Maine 04101
 207 774 4811
 www.wintonscott.com

Architecture / Planning
 Preservation Architecture
 Interior Architecture

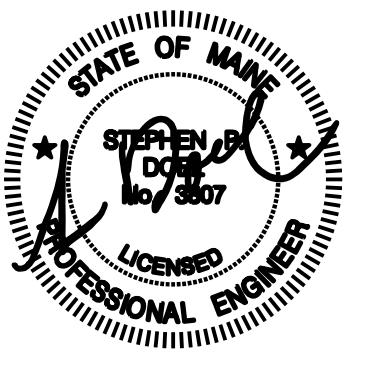

ISSUED
 FOR
 PERMIT
 ONLY
 3-30-16

Structural Engineer
 Structural Integrity Consulting
 Engineers, Inc.

Mechanical / Electrical
 Engineer

Owner
 Northland Enterprises
 LLC.

443 Congress


Portland, Maine

Fourth Floor
 Plumbing
 Plan

1/4" = 1'-0"

M 2.4

MARCH 30, 2016

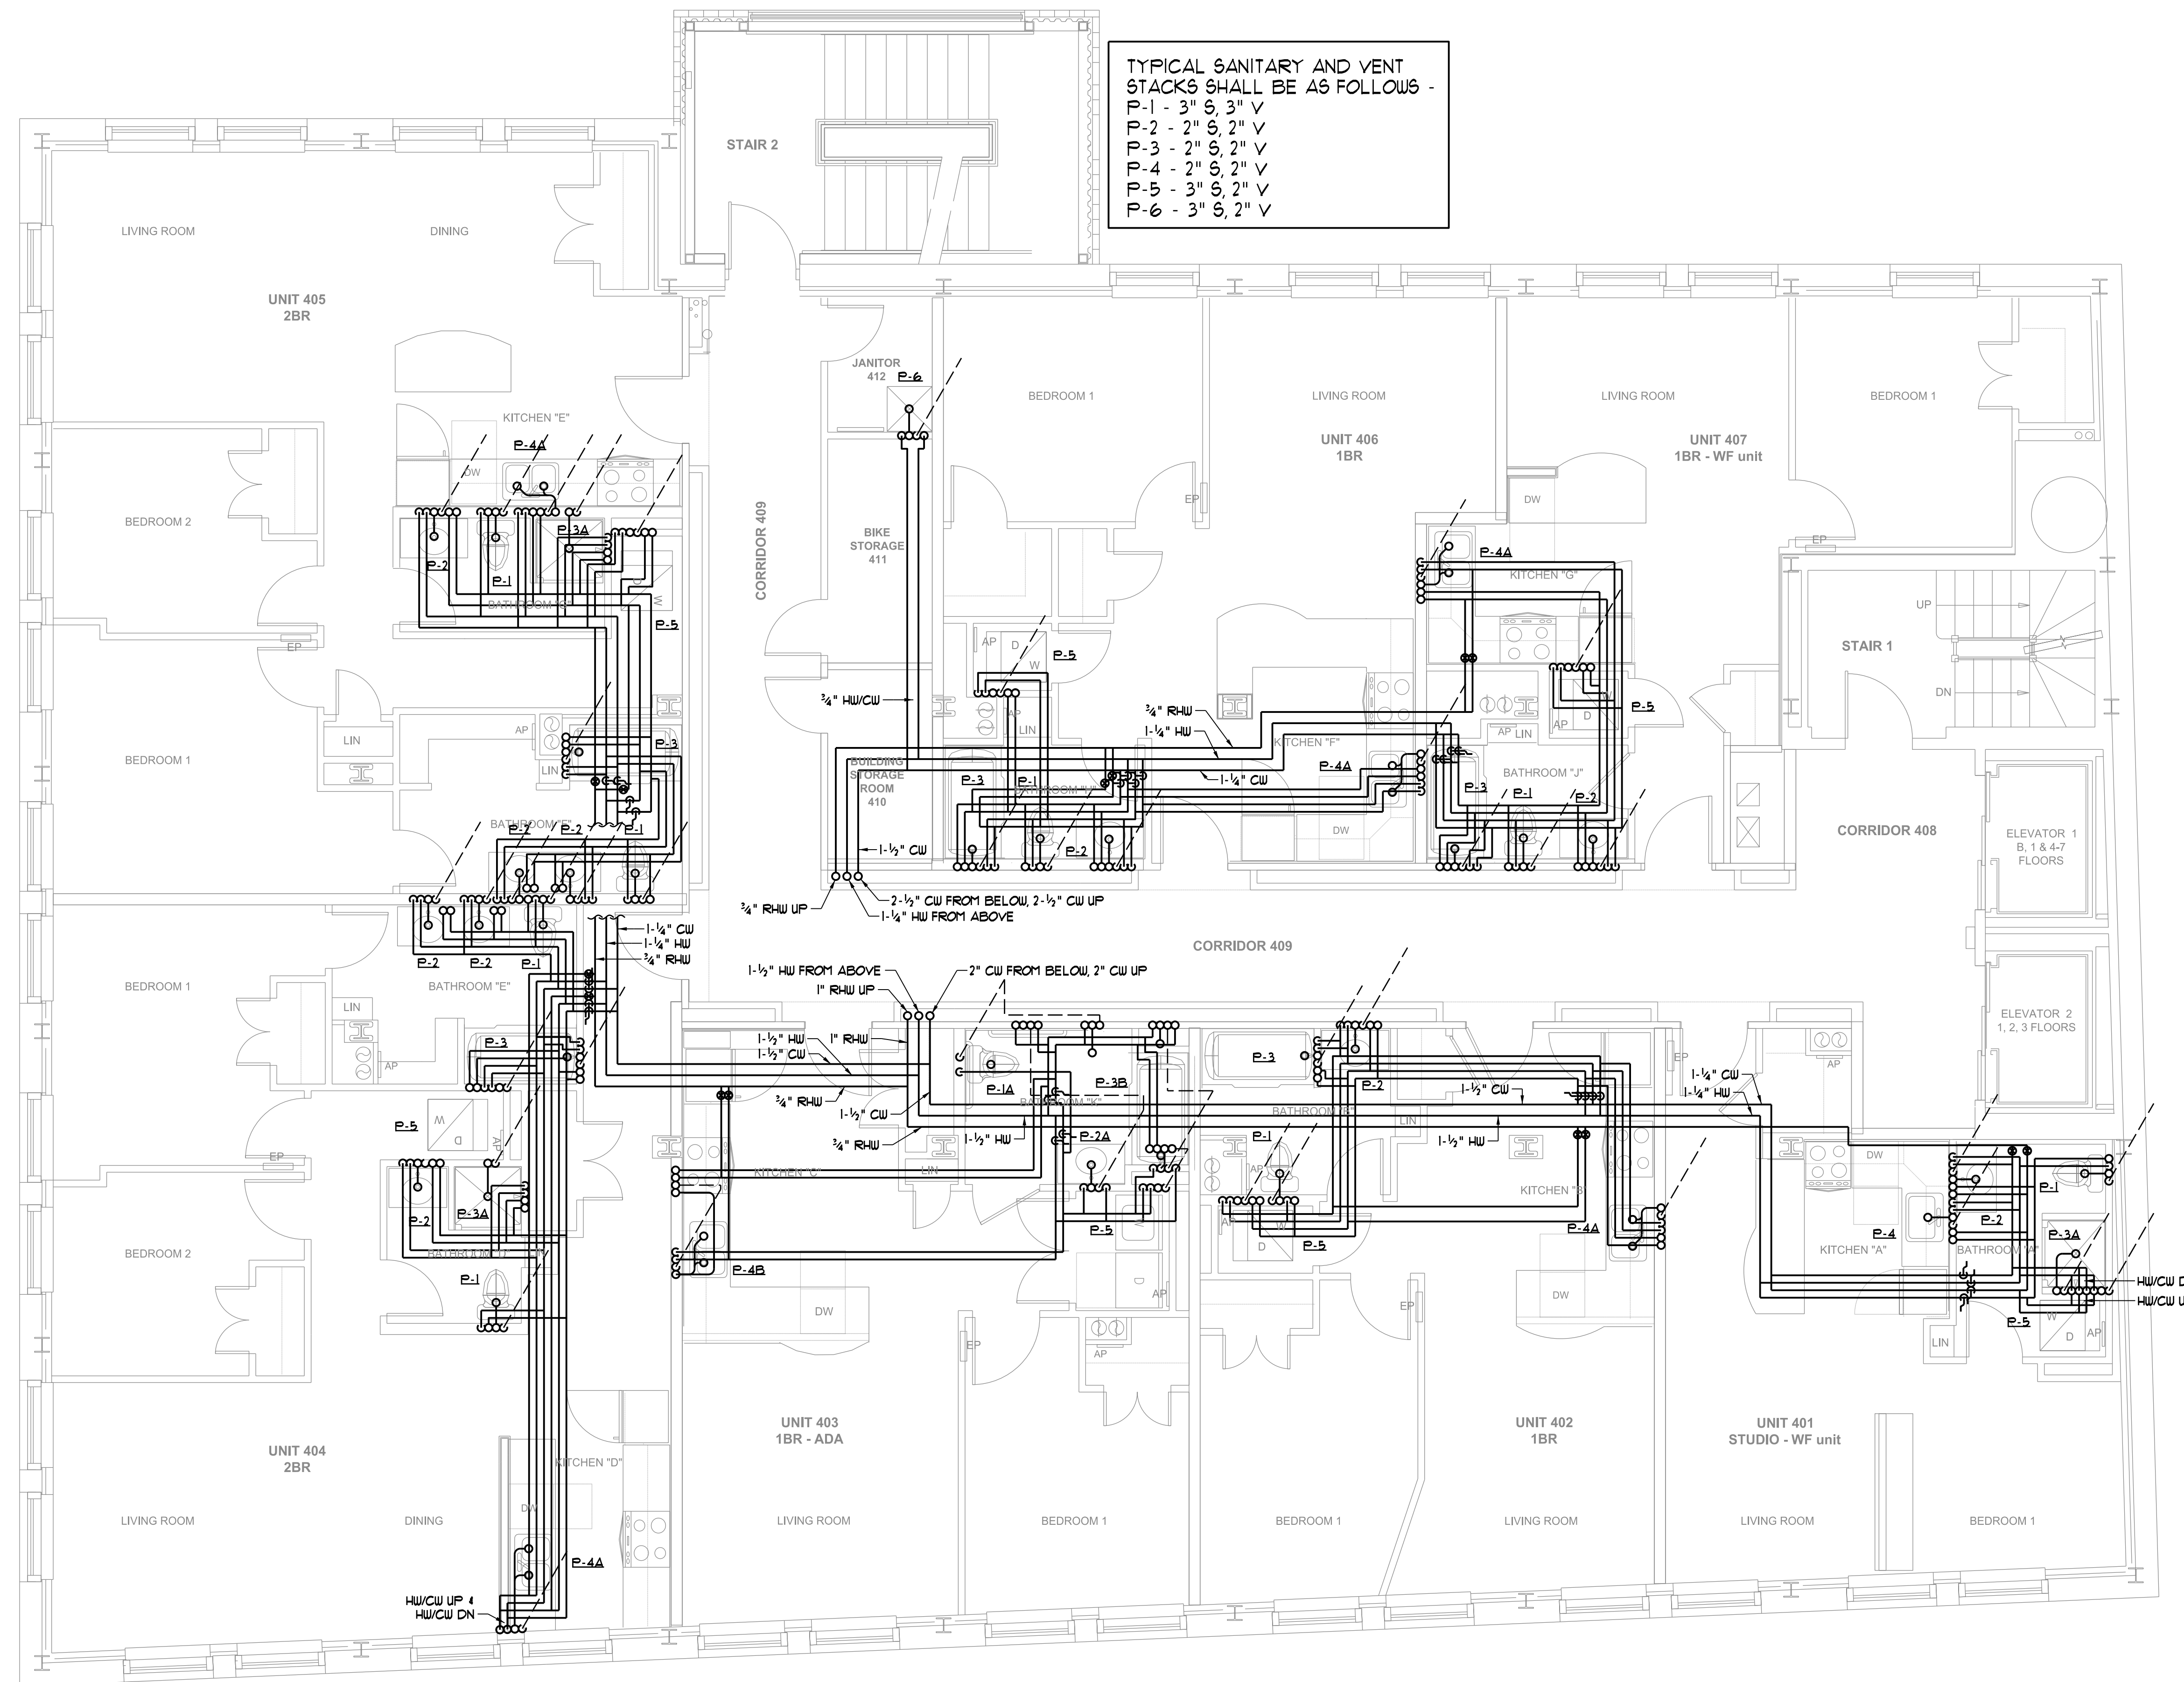

TYPICAL SANITARY AND VENT
 STACKS SHALL BE AS FOLLOWS -
 P-1 - 3" S, 3" V
 P-2 - 2" S, 2" V
 P-3 - 2" S, 2" V
 P-4 - 2" S, 2" V
 P-5 - 3" S, 2" V
 P-6 - 3" S, 2" V

FOURTH FLOOR PLUMBING PLAN
 SCALE - 1/4" = 1'-0"