
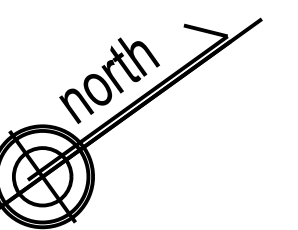


Winton Scott Architects  
 5 Milk Street  
 Portland, Maine 04101  
 207 774 4811  
 www.wintonsscott.com

Architecture / Planning  
 Preservation Architecture  
 Interior Architecture

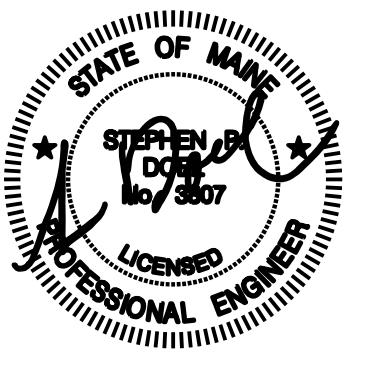

ISSUED  
 FOR  
 PERMIT  
 ONLY  
 3-30-16

Structural Engineer  
 Structural Integrity Consulting  
 Engineers, Inc.

Mechanical / Electrical  
 Engineer

Owner  
 Northland Enterprises  
 LLC.

443 Congress


Portland, Maine

Fifth Floor  
 Plumbing  
 Plan

1/4" = 1'-0"

M 2.5

MARCH 30, 2016

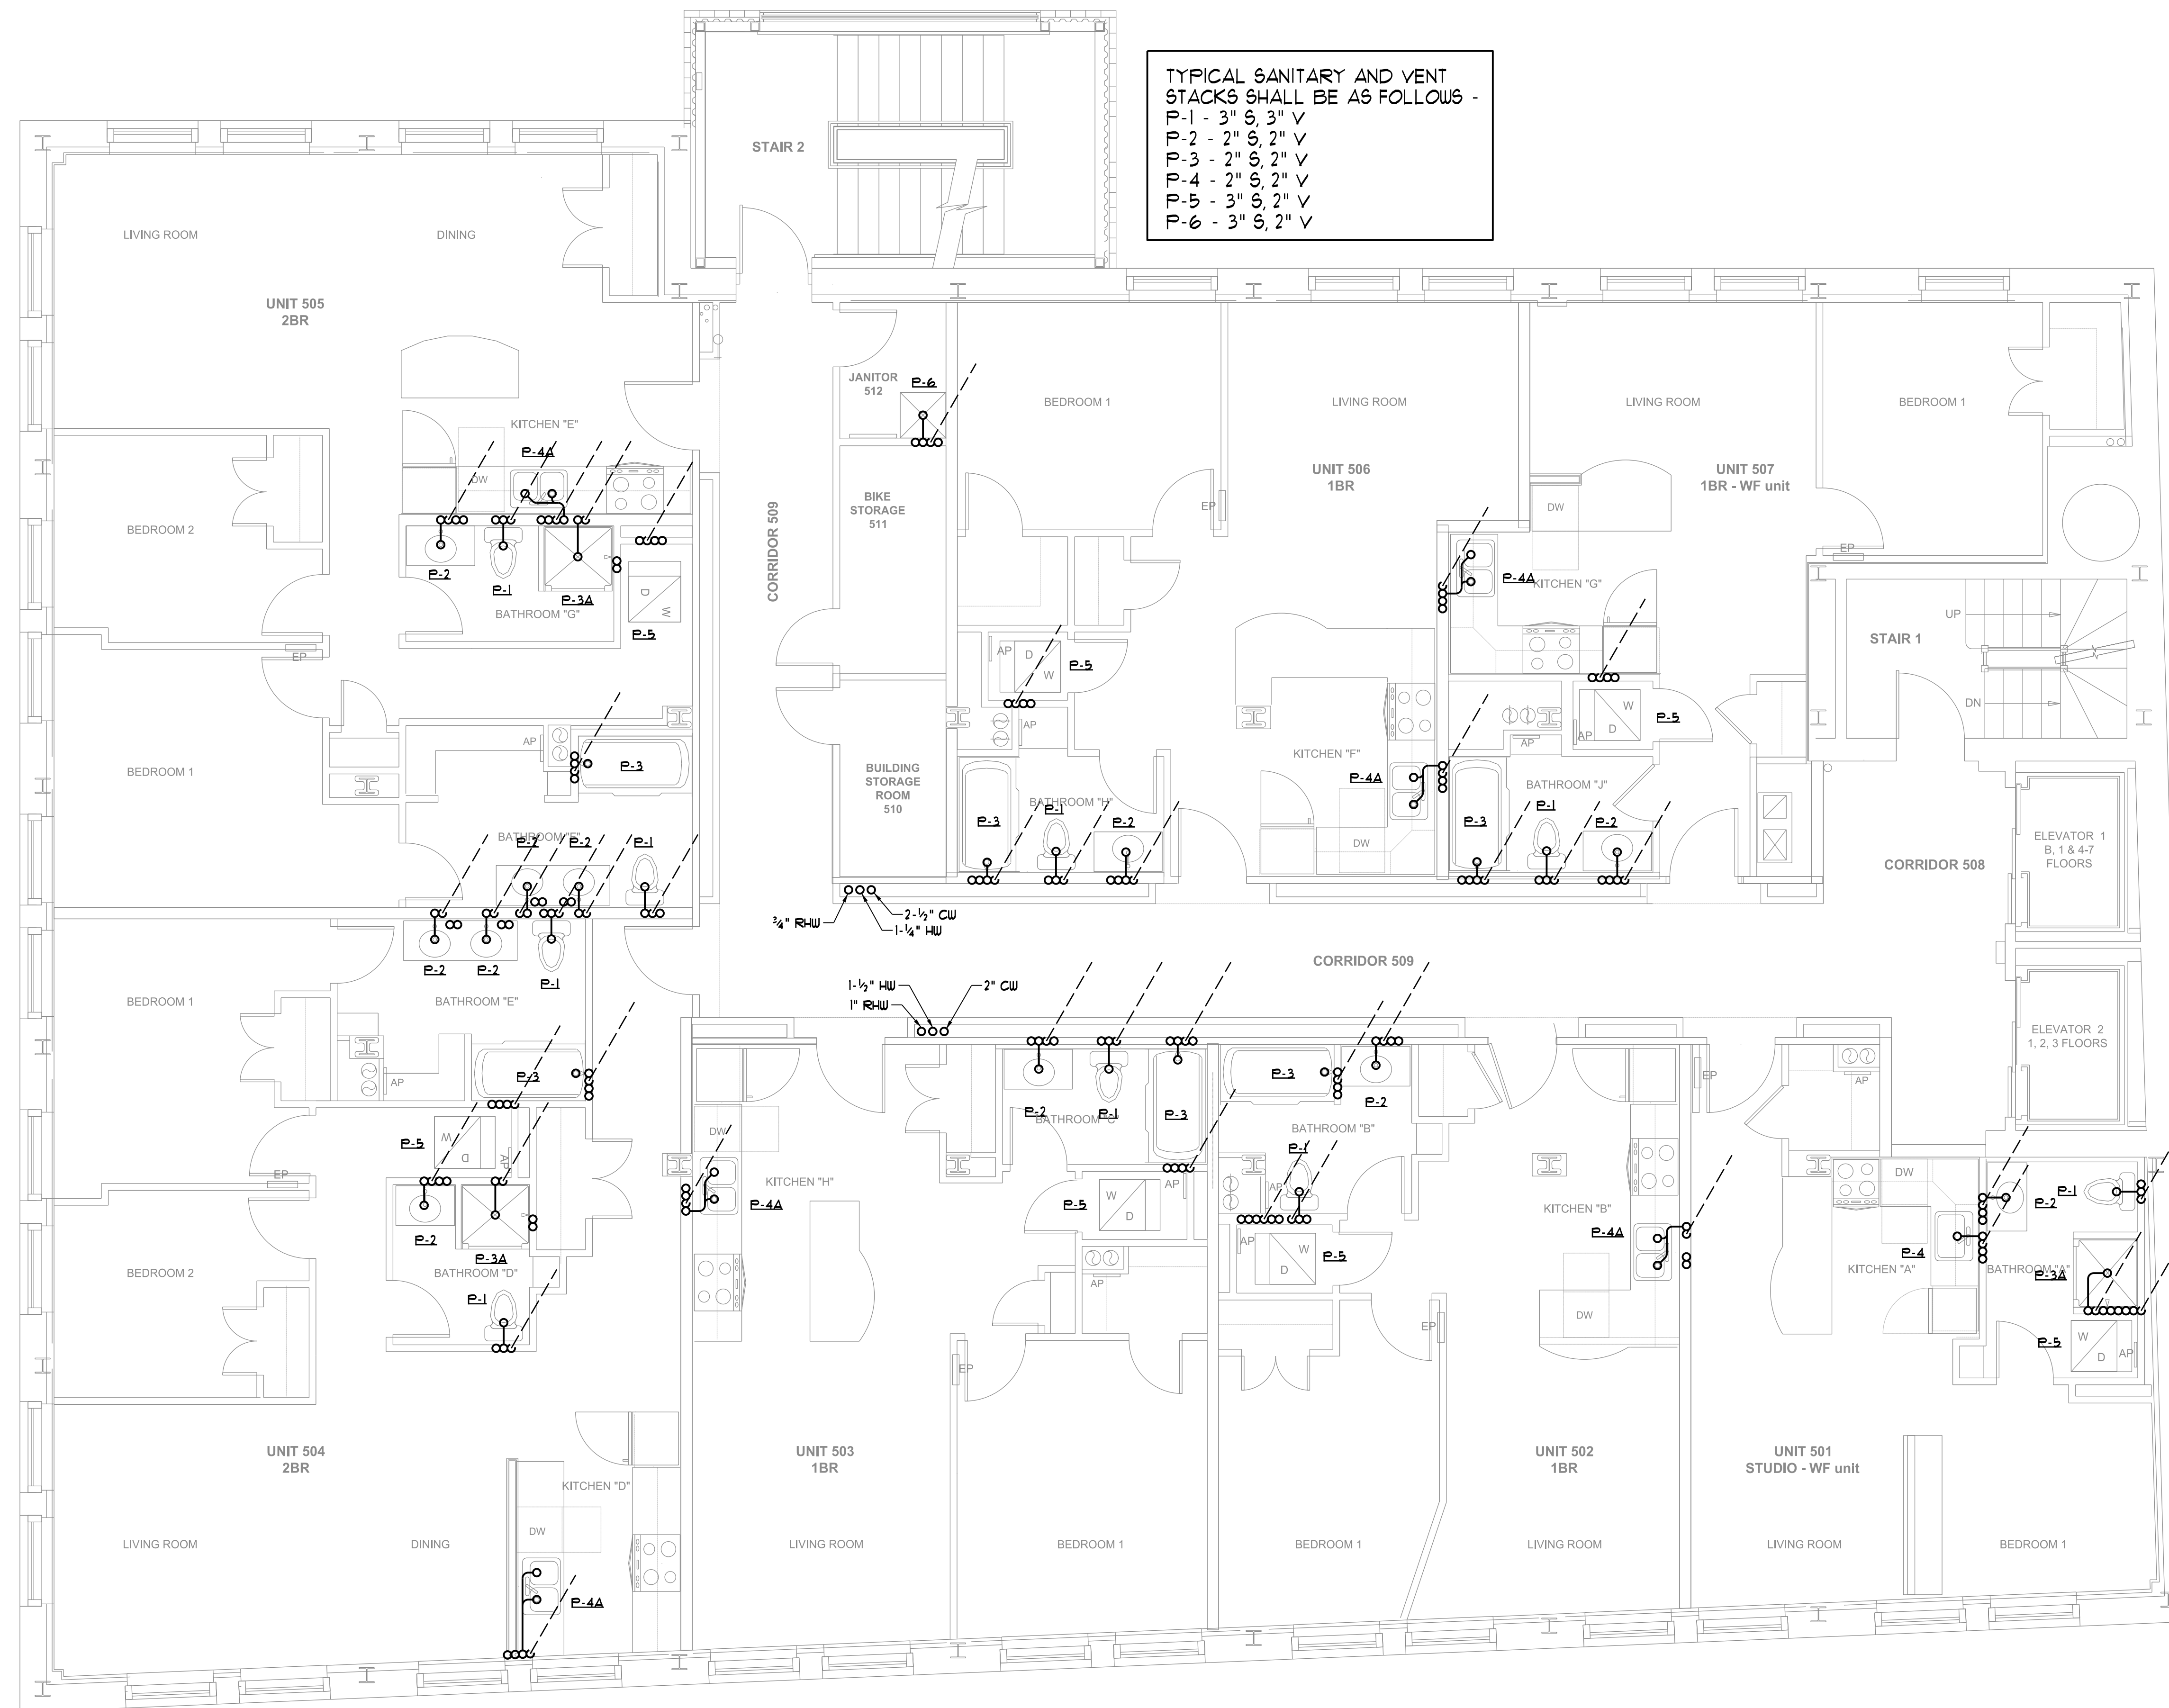

FIFTH FLOOR PLUMBING PLAN  
 SCALE - 1/4" = 1'-0"