


This note is calling to your attention an issue with the location of the EP's at the bedroom door swing. The door schedule does not indicate the lockset information on these doors. In order to comply with NEC clearance and safety, these doors will need to be lockable when the panels are being serviced.

WSA: ALL BEDROOM DOORS HAVE A PRIVACY LOCKSET WHICH CAN BE LOCKED FROM INSIDE THE ROOM. SEE ATTACHED SPEC SECTION 087100 DOOR HARDWARE

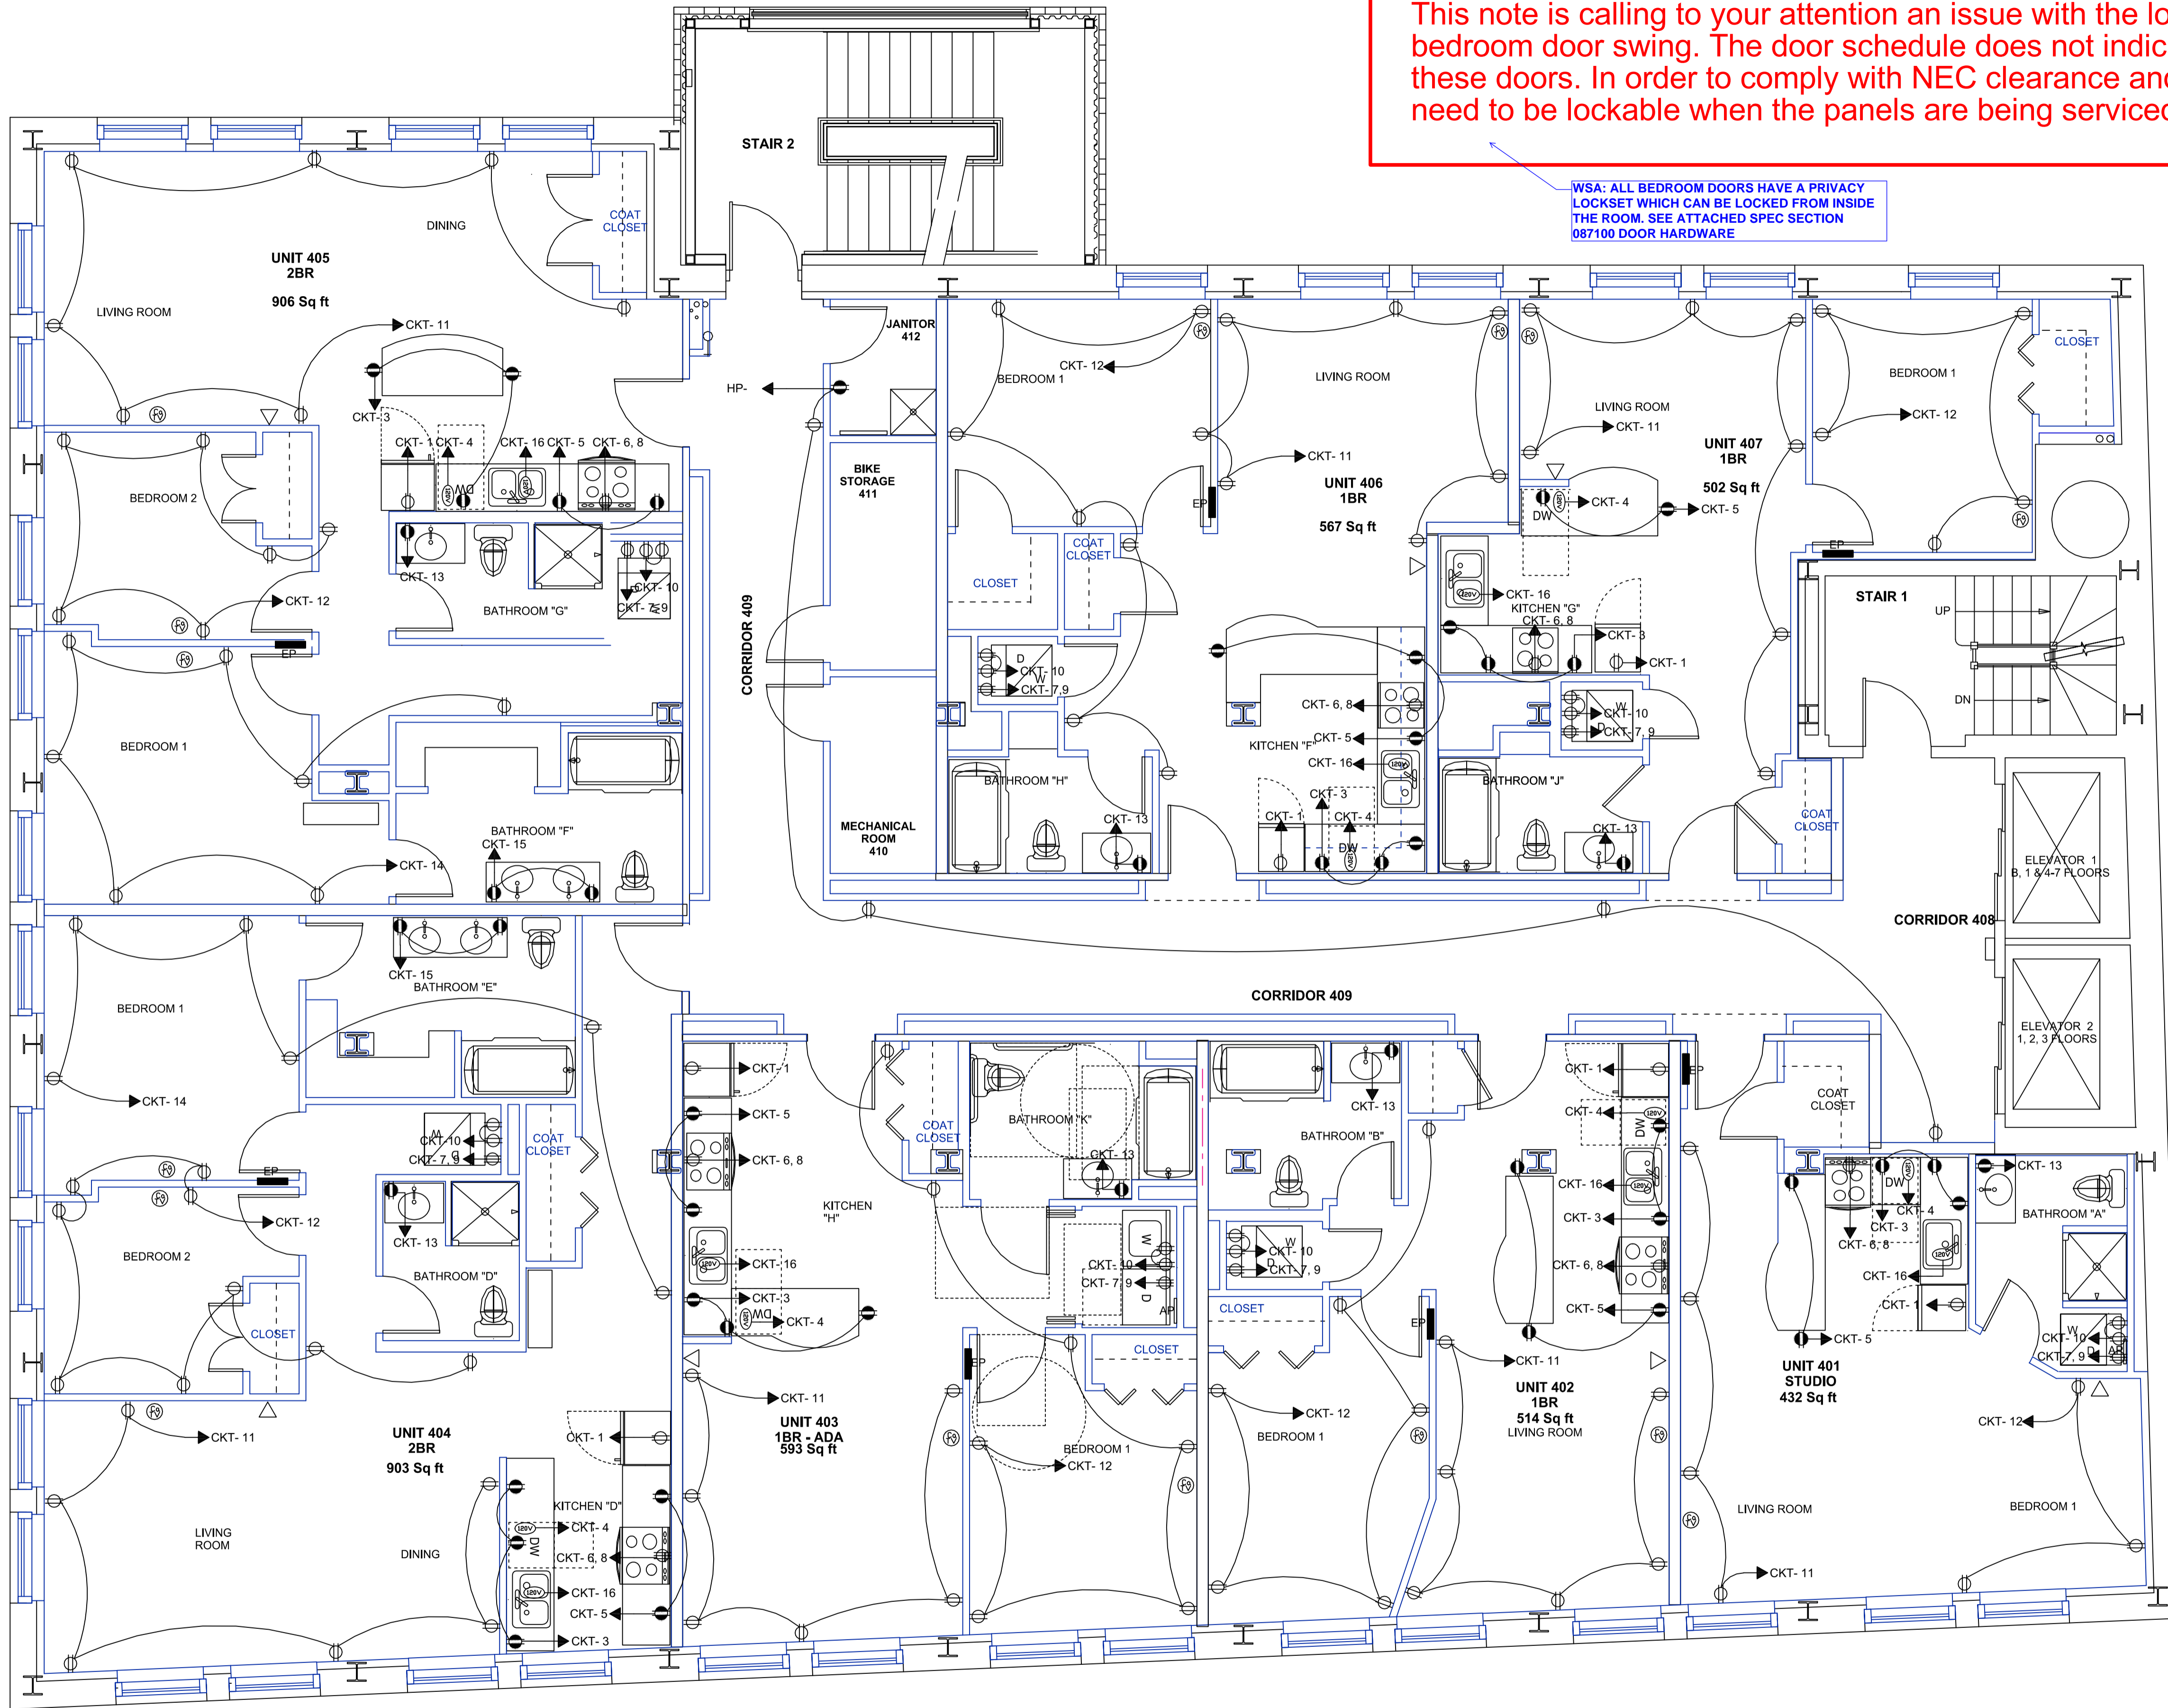

Device Legend


- ⊕ Duplex Receptacle
- ⊕ GFCI Receptacle
- ⊕ Cable TV
- △ Phone
- SW Single Pole Switch
- SW3 3 Way Switch
- SW4 4 Way Switch

Lighting Legend

- ⊕ Type A1 Over Island Light
- ⊕ Type B LED Low Profile
- ⊕ Type C1 Living Room Light
- ⊕ Type D1 Vanity Light
- ⊕ Type E Bedroom Light
- ⊕ Type F1 Entrance Light
- Type G1 LED Surface Light
- Type H Under cabinet Light
- ▨ Type I 4' Surface Wrap Light
- Canopy Light
- W Wall Pack
- Track Light

Exit Emergency Legend

- ⊕ Emergency Light
- ⊕ Remote Emergency Head
- ⊕ Exit Light
- ⊕ Exit Emergency Combo
- E Indicates Existing Fixture
- EM Indicates Battery Back-Up Fixture

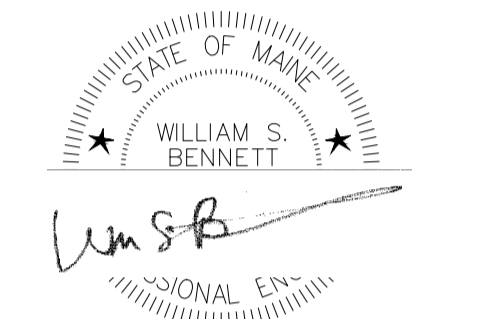

General Notes		
Issued for Building permit Only 3/30/16		
No.	Revision/Issue	Date
1	Progress	12/1/15
2	Progress	3/23/16
3	Issued for Building permit only	3/30/16

Seabee Electric
 COMMERCIAL • INDUSTRIAL
 84 Pleasant Hill Road
 Scarborough, Maine 04074
 (207) 883-5448

Project Name and Address
 443 Congress St. Apartments
 443 Congress Street
 Portland, Maine

Sheet
EP - 2.4
 4th Floor Power
 Scale 1/4" = 1'