


LIFE SAFETY PLAN

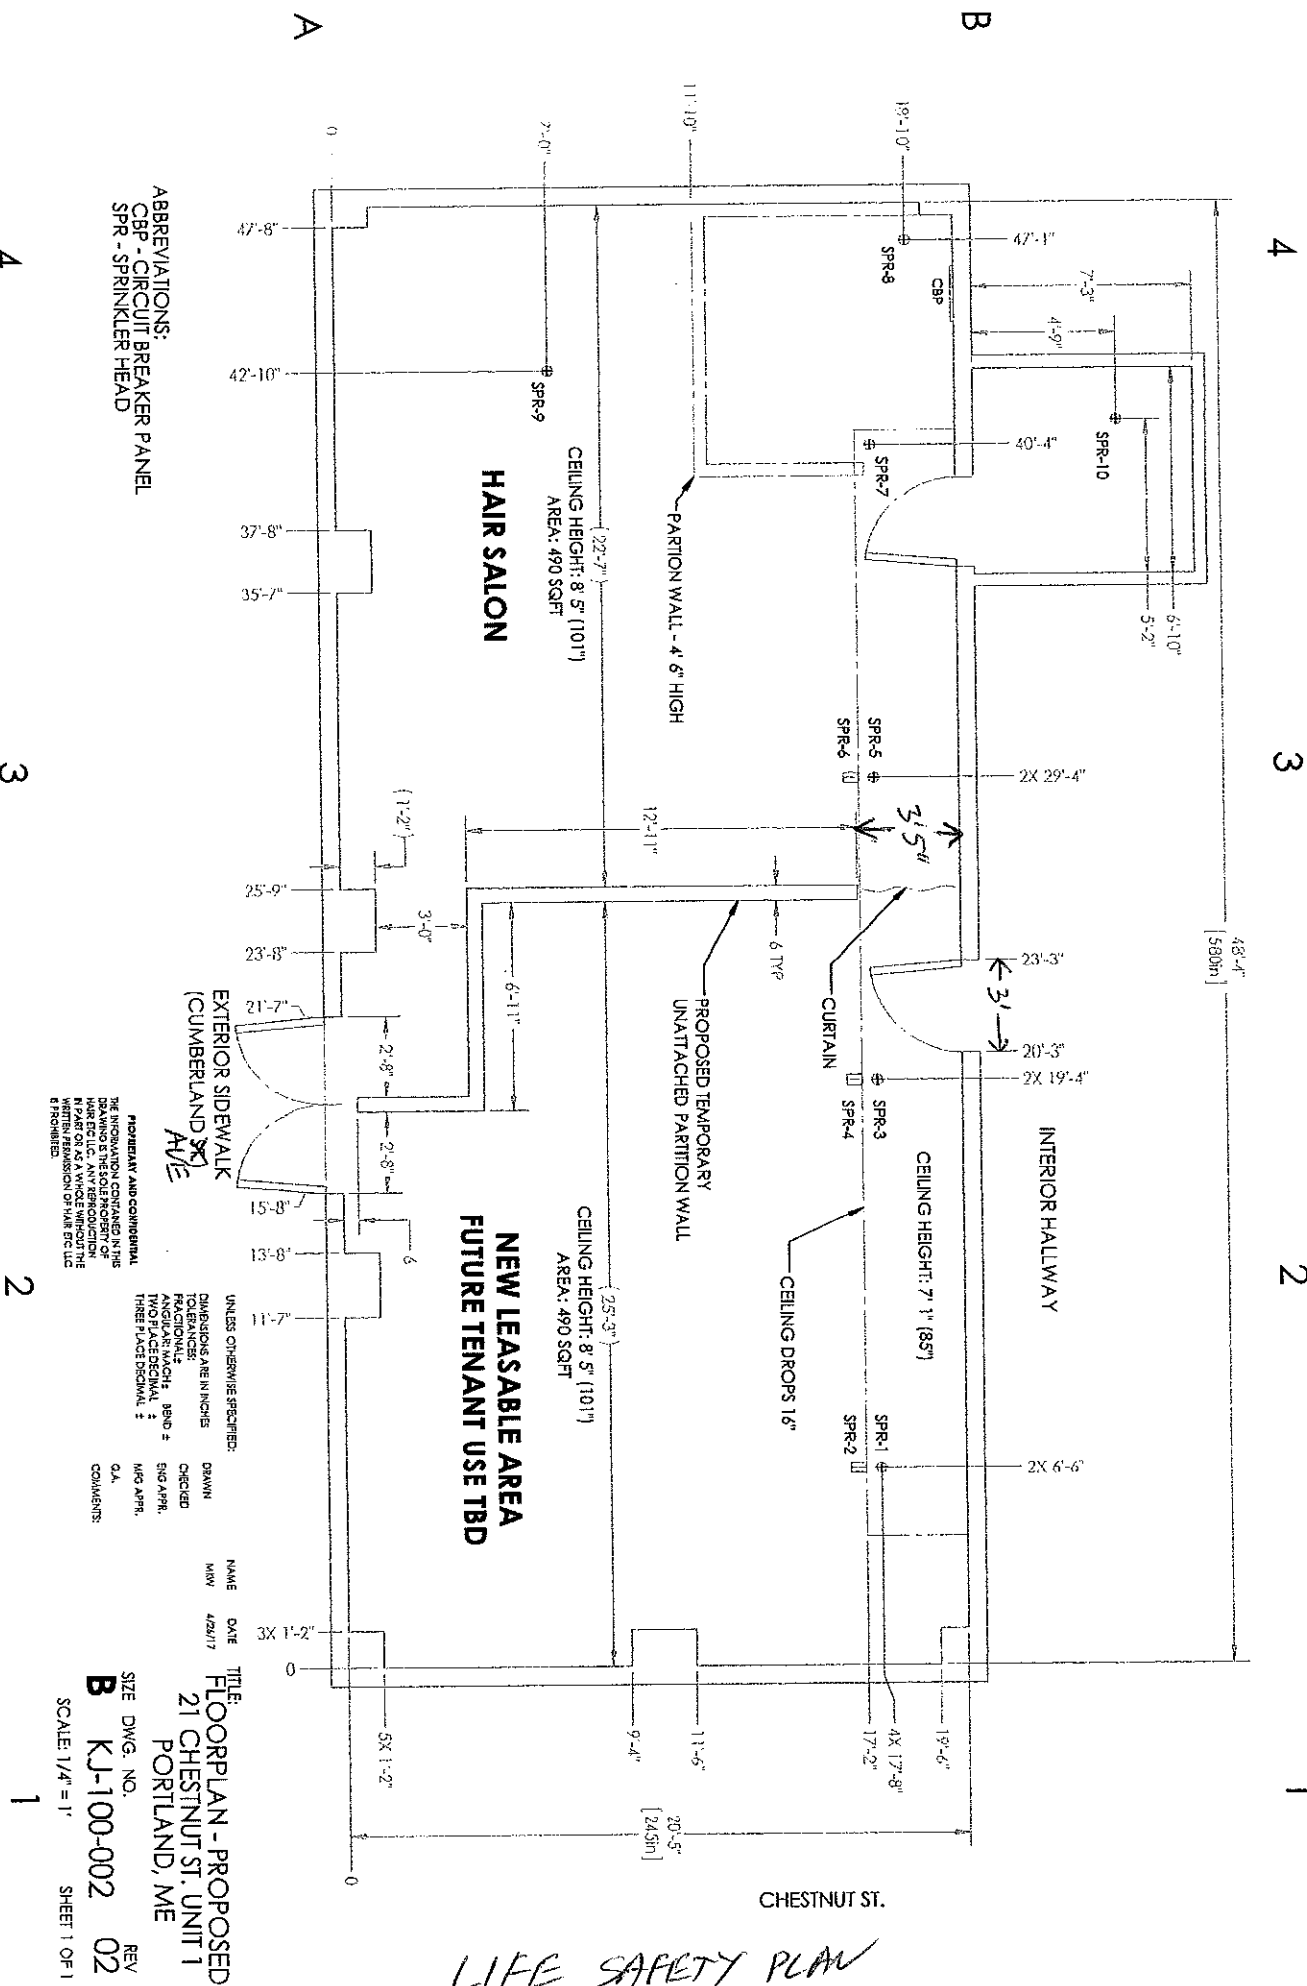

ABBREVIATIONS:
 CBP - CIRCUIT BREAKER PANEL
 SPR - SPRINKLER HEAD

PROVIDENT AND COMMERCIAL
 THE INFORMATION CONTAINED IN THIS
 DRAWING IS THE SOLE PROPERTY OF
 PROVIDENT AND COMMERCIAL. NO PART
 OF THIS DRAWING IS TO BE REPRODUCED
 OR TRANSMITTED IN ANY FORM OR BY
 ANY MEANS, ELECTRONIC OR MECHANICAL,
 INCLUDING PHOTOCOPYING, RECORDING,
 OR BY ANY INFORMATION STORAGE AND
 RETRIEVAL SYSTEM, WITHOUT THE
 WRITTEN PERMISSION OF PROVIDENT AND
 COMMERCIAL.

UNLESS OTHERWISE SPECIFIED:
 DIMENSIONS ARE IN INCHES
 FRACTIONS
 ANGULAR: MACH. BEND #
 TWO PLACE DECIMAL #
 THREE PLACE DECIMAL #
 DRAWN: [Signature]
 CHECKED: [Signature]
 MGD APRIL
 O.A.
 COMMENTS:

NAME: MGV
 DATE: 4/26/17
 TITLE: FLOOR PLAN - PROPOSED
 21 CHESTNUT ST., UNIT 1
 PORTLAND, ME
 SIZE: DWG. NO. B
 KJ-100-002
 SCALE: 1/4" = 1'
 SHEET 1 OF 1

4

3

2

1

4

3

2

1

A

B

A

B