


CHESTNUT STREET LOFTS
URBAN REVITALIZATION PROJECT
BY CHESTNUT STREET LLC,
PORTLAND, MAINE

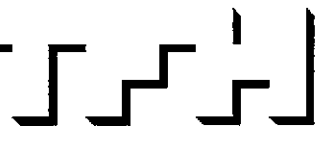

TFH ARCHITECTS
100 COMMERCIAL STREET
PORTLAND MAINE 04101
TELEPHONE 207 775 6141
ARCHITECTURE PLANNING


CONSULTANTS:
CIVIL:
 Land Use Consultants
 955 Riverside Street
 Portland, ME 04103
 207-478-3313
STRUCTURAL:
 Structural Design Consulting
 22 Cabot Street
 Old Orchard Beach, ME 04064
 207-494-4026
MECHANICAL:
 Whitney Engineering
 10 Danforth Street
 Portland, ME 04101
 207-474-7449
ELECTRICAL:
 Bennett Engineering
 7 Berneer Road
 Frenoville, ME 04032
 207-665-6475

REVISIONS:
 1 100% CONSTRUCTION DOCUMENTS
 2 22.24.05


DATE:
 PROJECT No. 0422
 DRAWN BY: RJS
 CHECKED BY: TST
 SCALE: AS NOTED

SHEET TITLE:
FIRST AND SECOND FLOOR PLANS

A1.1

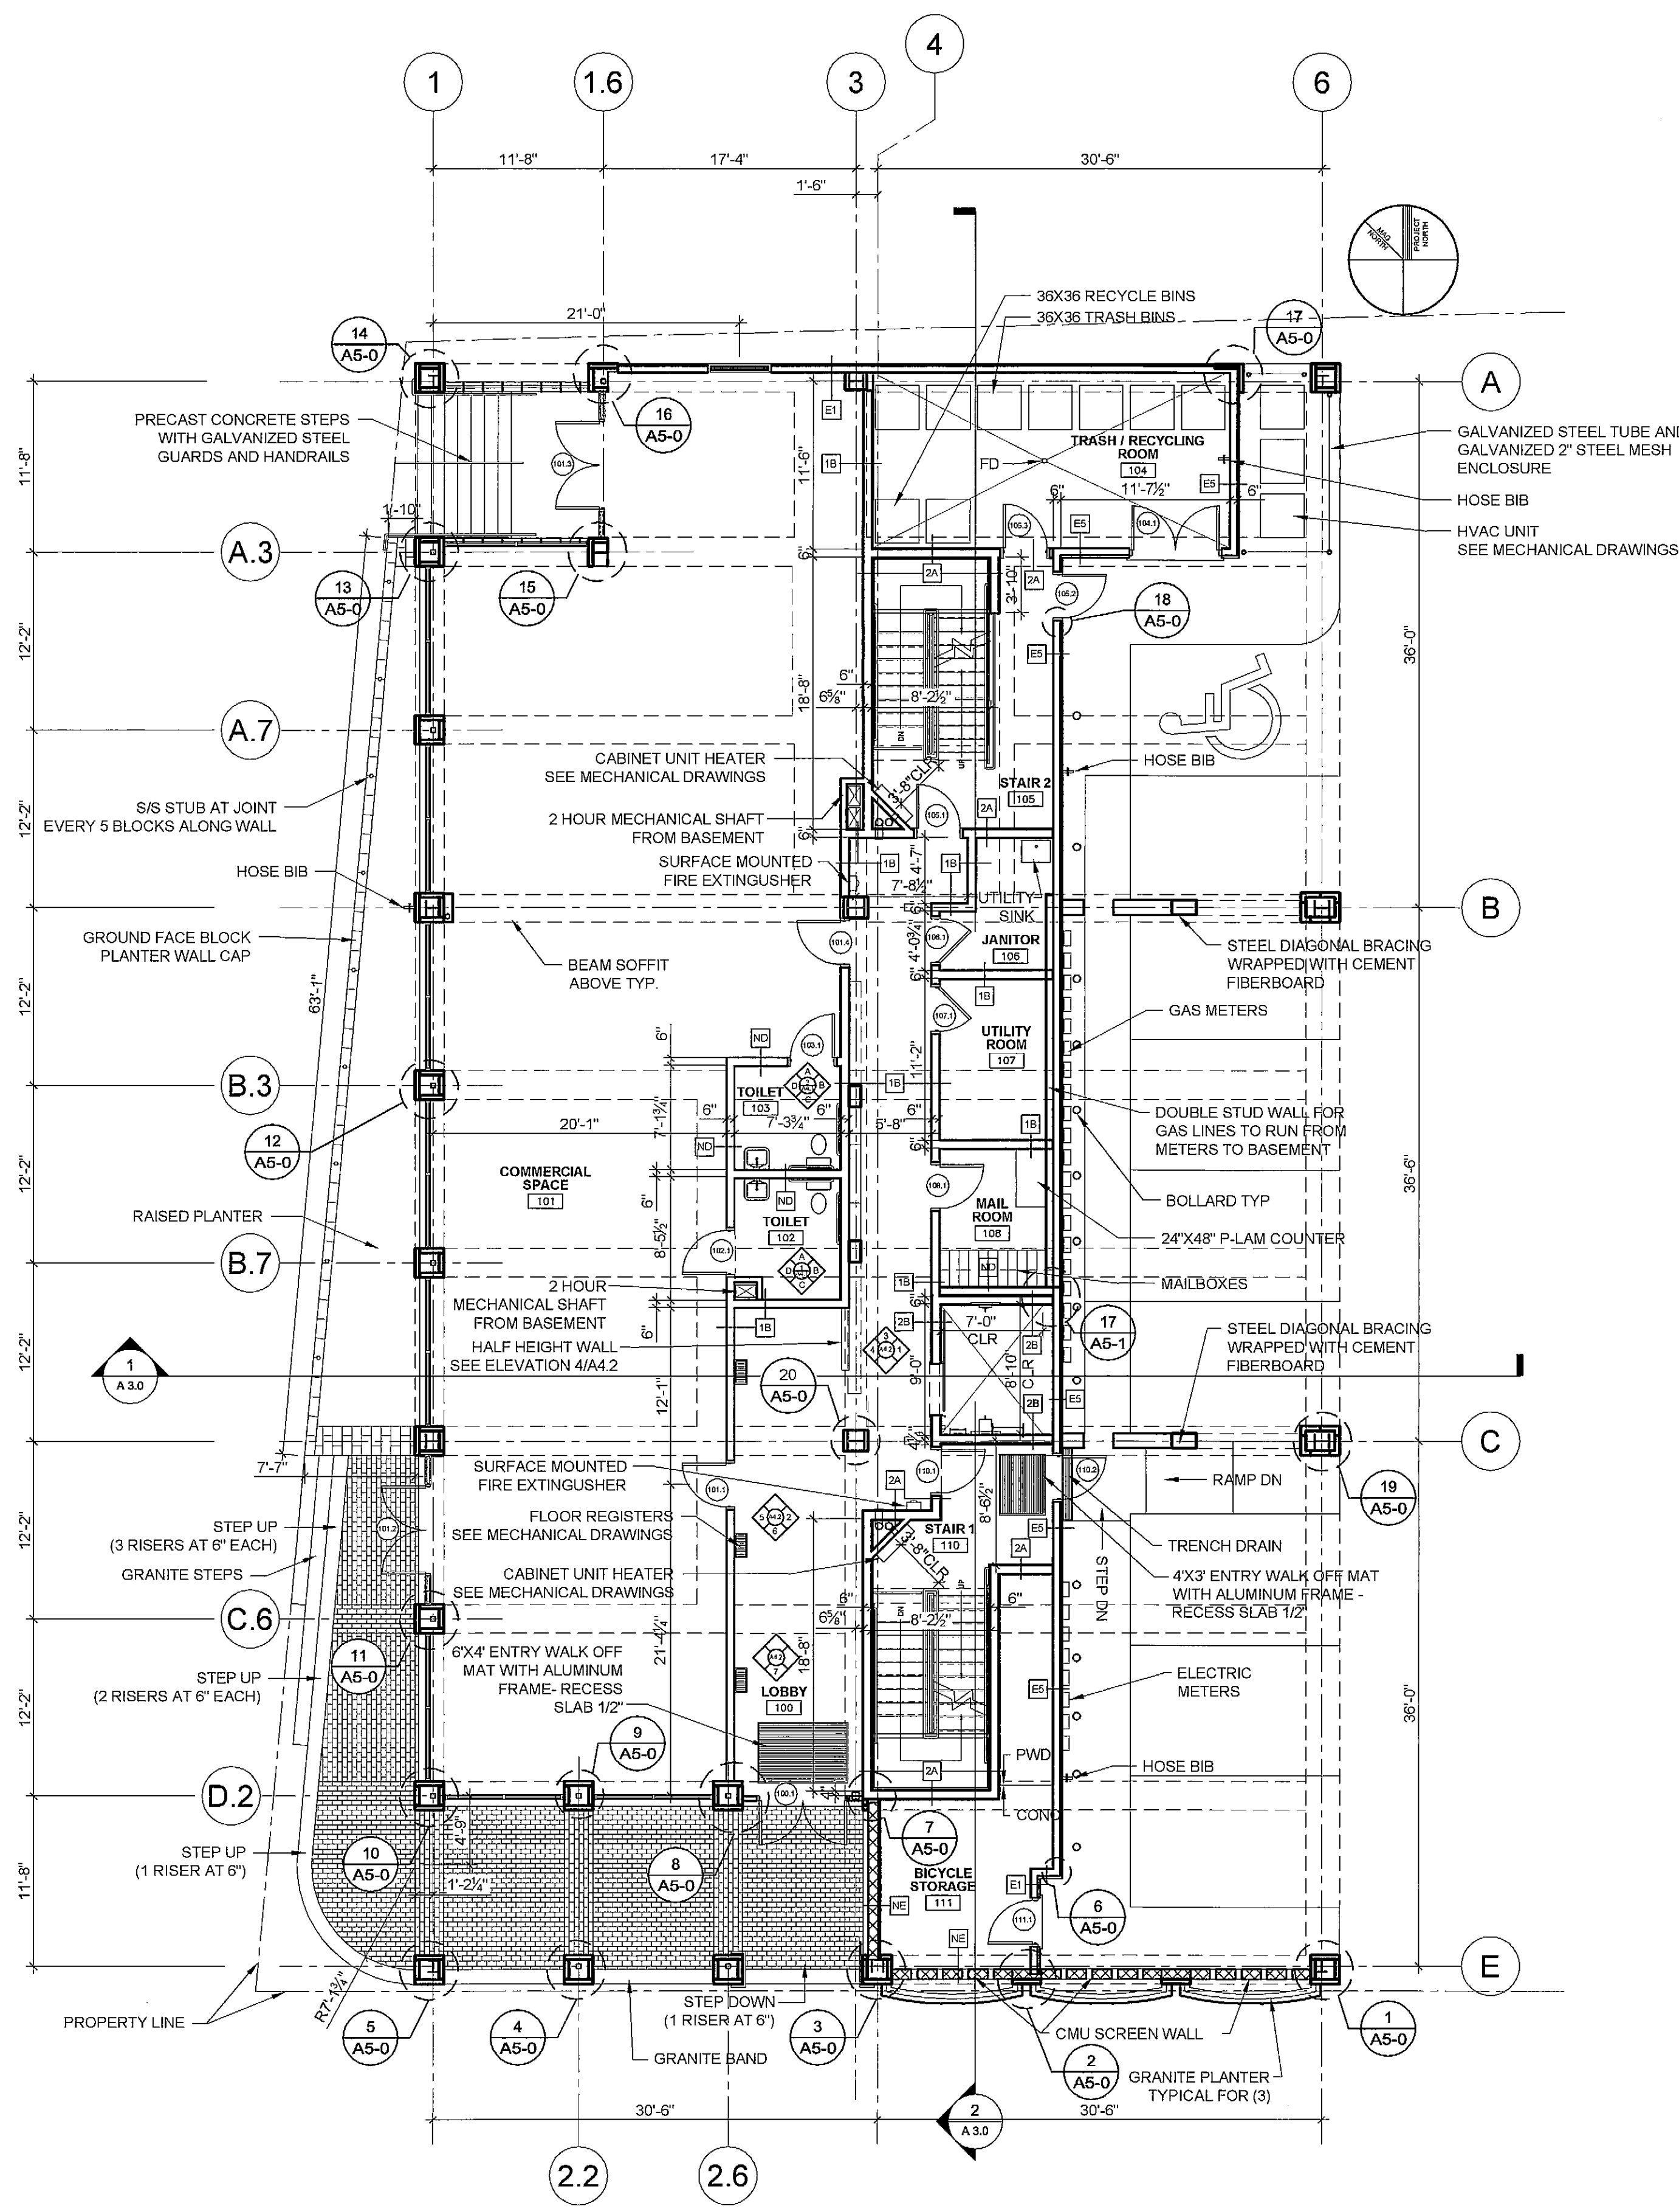

1 FIRST FLOOR PLAN
1/8" = 1'-0"

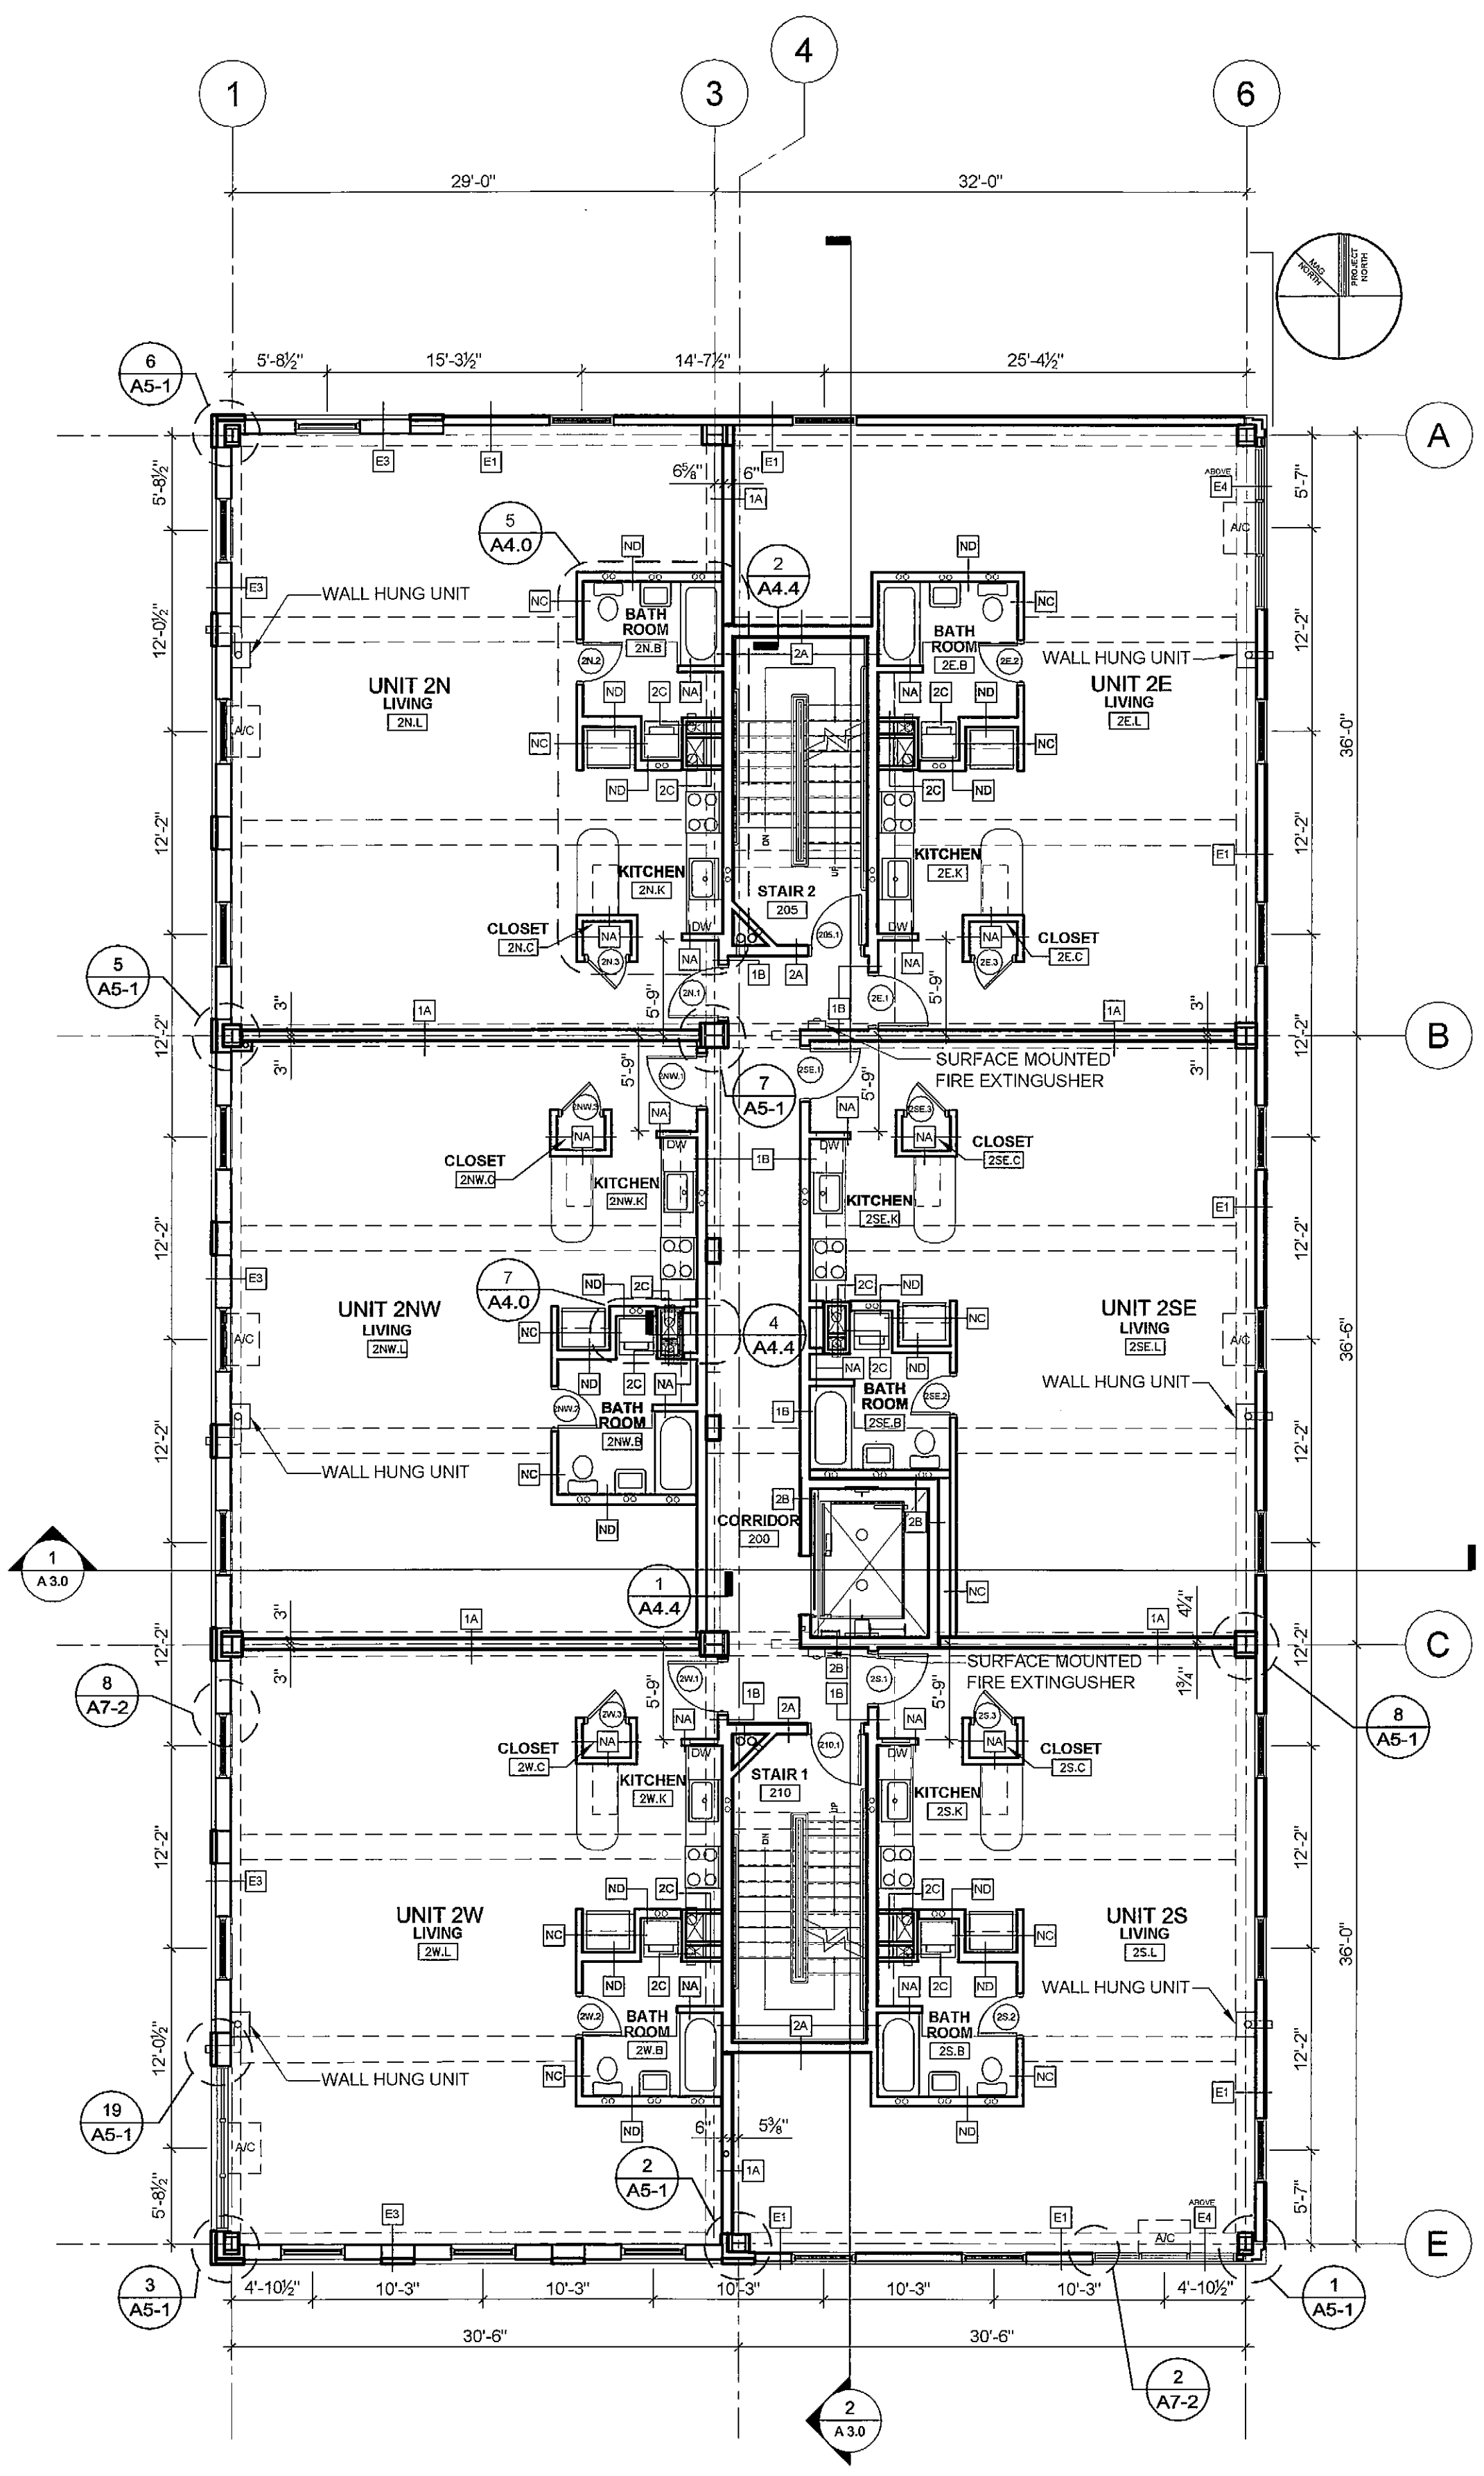

2 SECOND FLOOR PLAN
1/8" = 1'-0"