

© 2005 TFH ARCHITECTS

CHESTNUT STREET LOFTS

URBAN REVITALIZATION PROJECT
BY CHESTNUT STREET LLC.
PORTLAND, MAINE


TFH ARCHITECTS
100 COMMERCIAL STREET
PORTLAND MAINE 04101
TELEPHONE 207 775 6141
ARCHITECTURE PLANNING

CONSULTANTS:
CIVIL:
Lead Use Consultants
566 Riverside Street
Portland, ME 04103
207-479-3313
STRUCTURAL:
Structural Design Consulting
22 Oakmont Drive
Old Orchard Beach, ME 04064
207-664-8038
MECHANICAL:
Whitney Engineering
10 Oakmont Street
Portland, ME 04101
207-874-7442
ELECTRICAL:
Bennett Engineering
7 Bennett Road
Freeport, ME 04032
207-865-8472


REVISIONS:
Re-issued by Addendum #1
01-20-06
100% Construction Documents
02-24-06
DATE: February 24, 2006
PROJECT No. 0422
DRAWN BY: RPW
CHECKED BY: RPW
SCALE: AS NOTED

SHEET TITLE:
**MECHANICAL
FIRST & SECOND
FLOOR PLANS**

M1.1

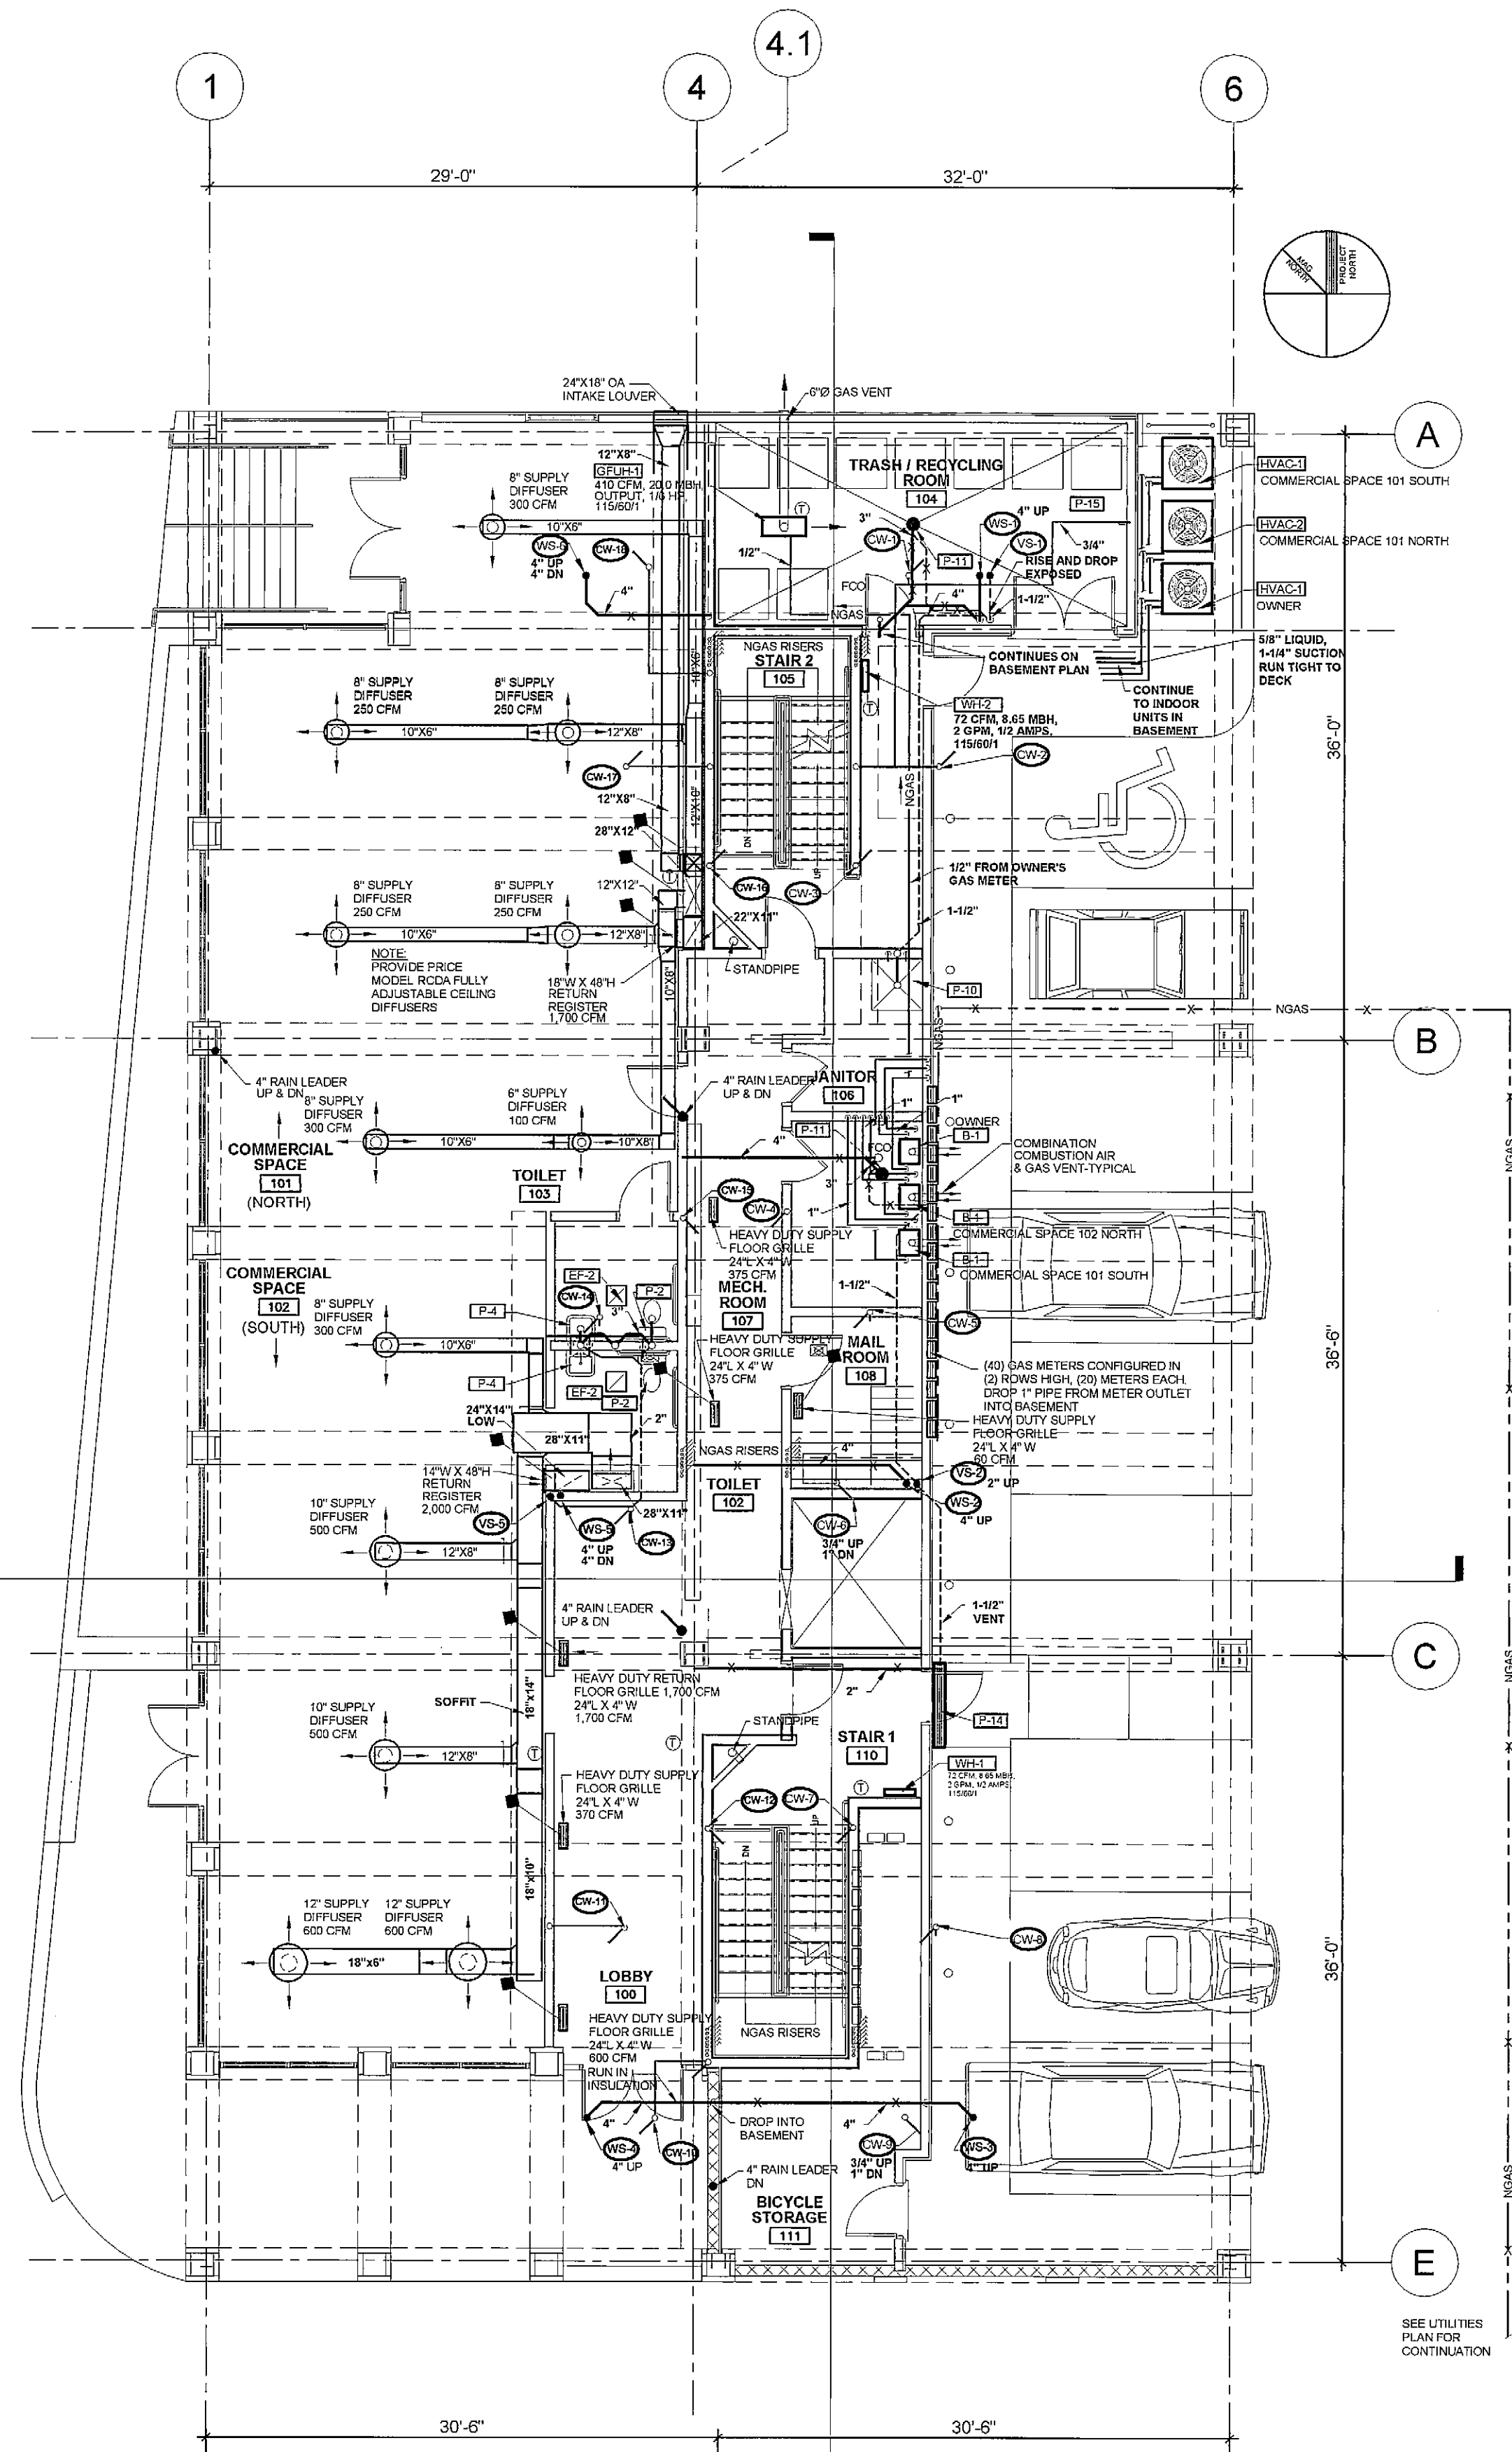

1 FIRST FLOOR MECHANICAL PLAN
A1.1 1/8" = 1'-0"

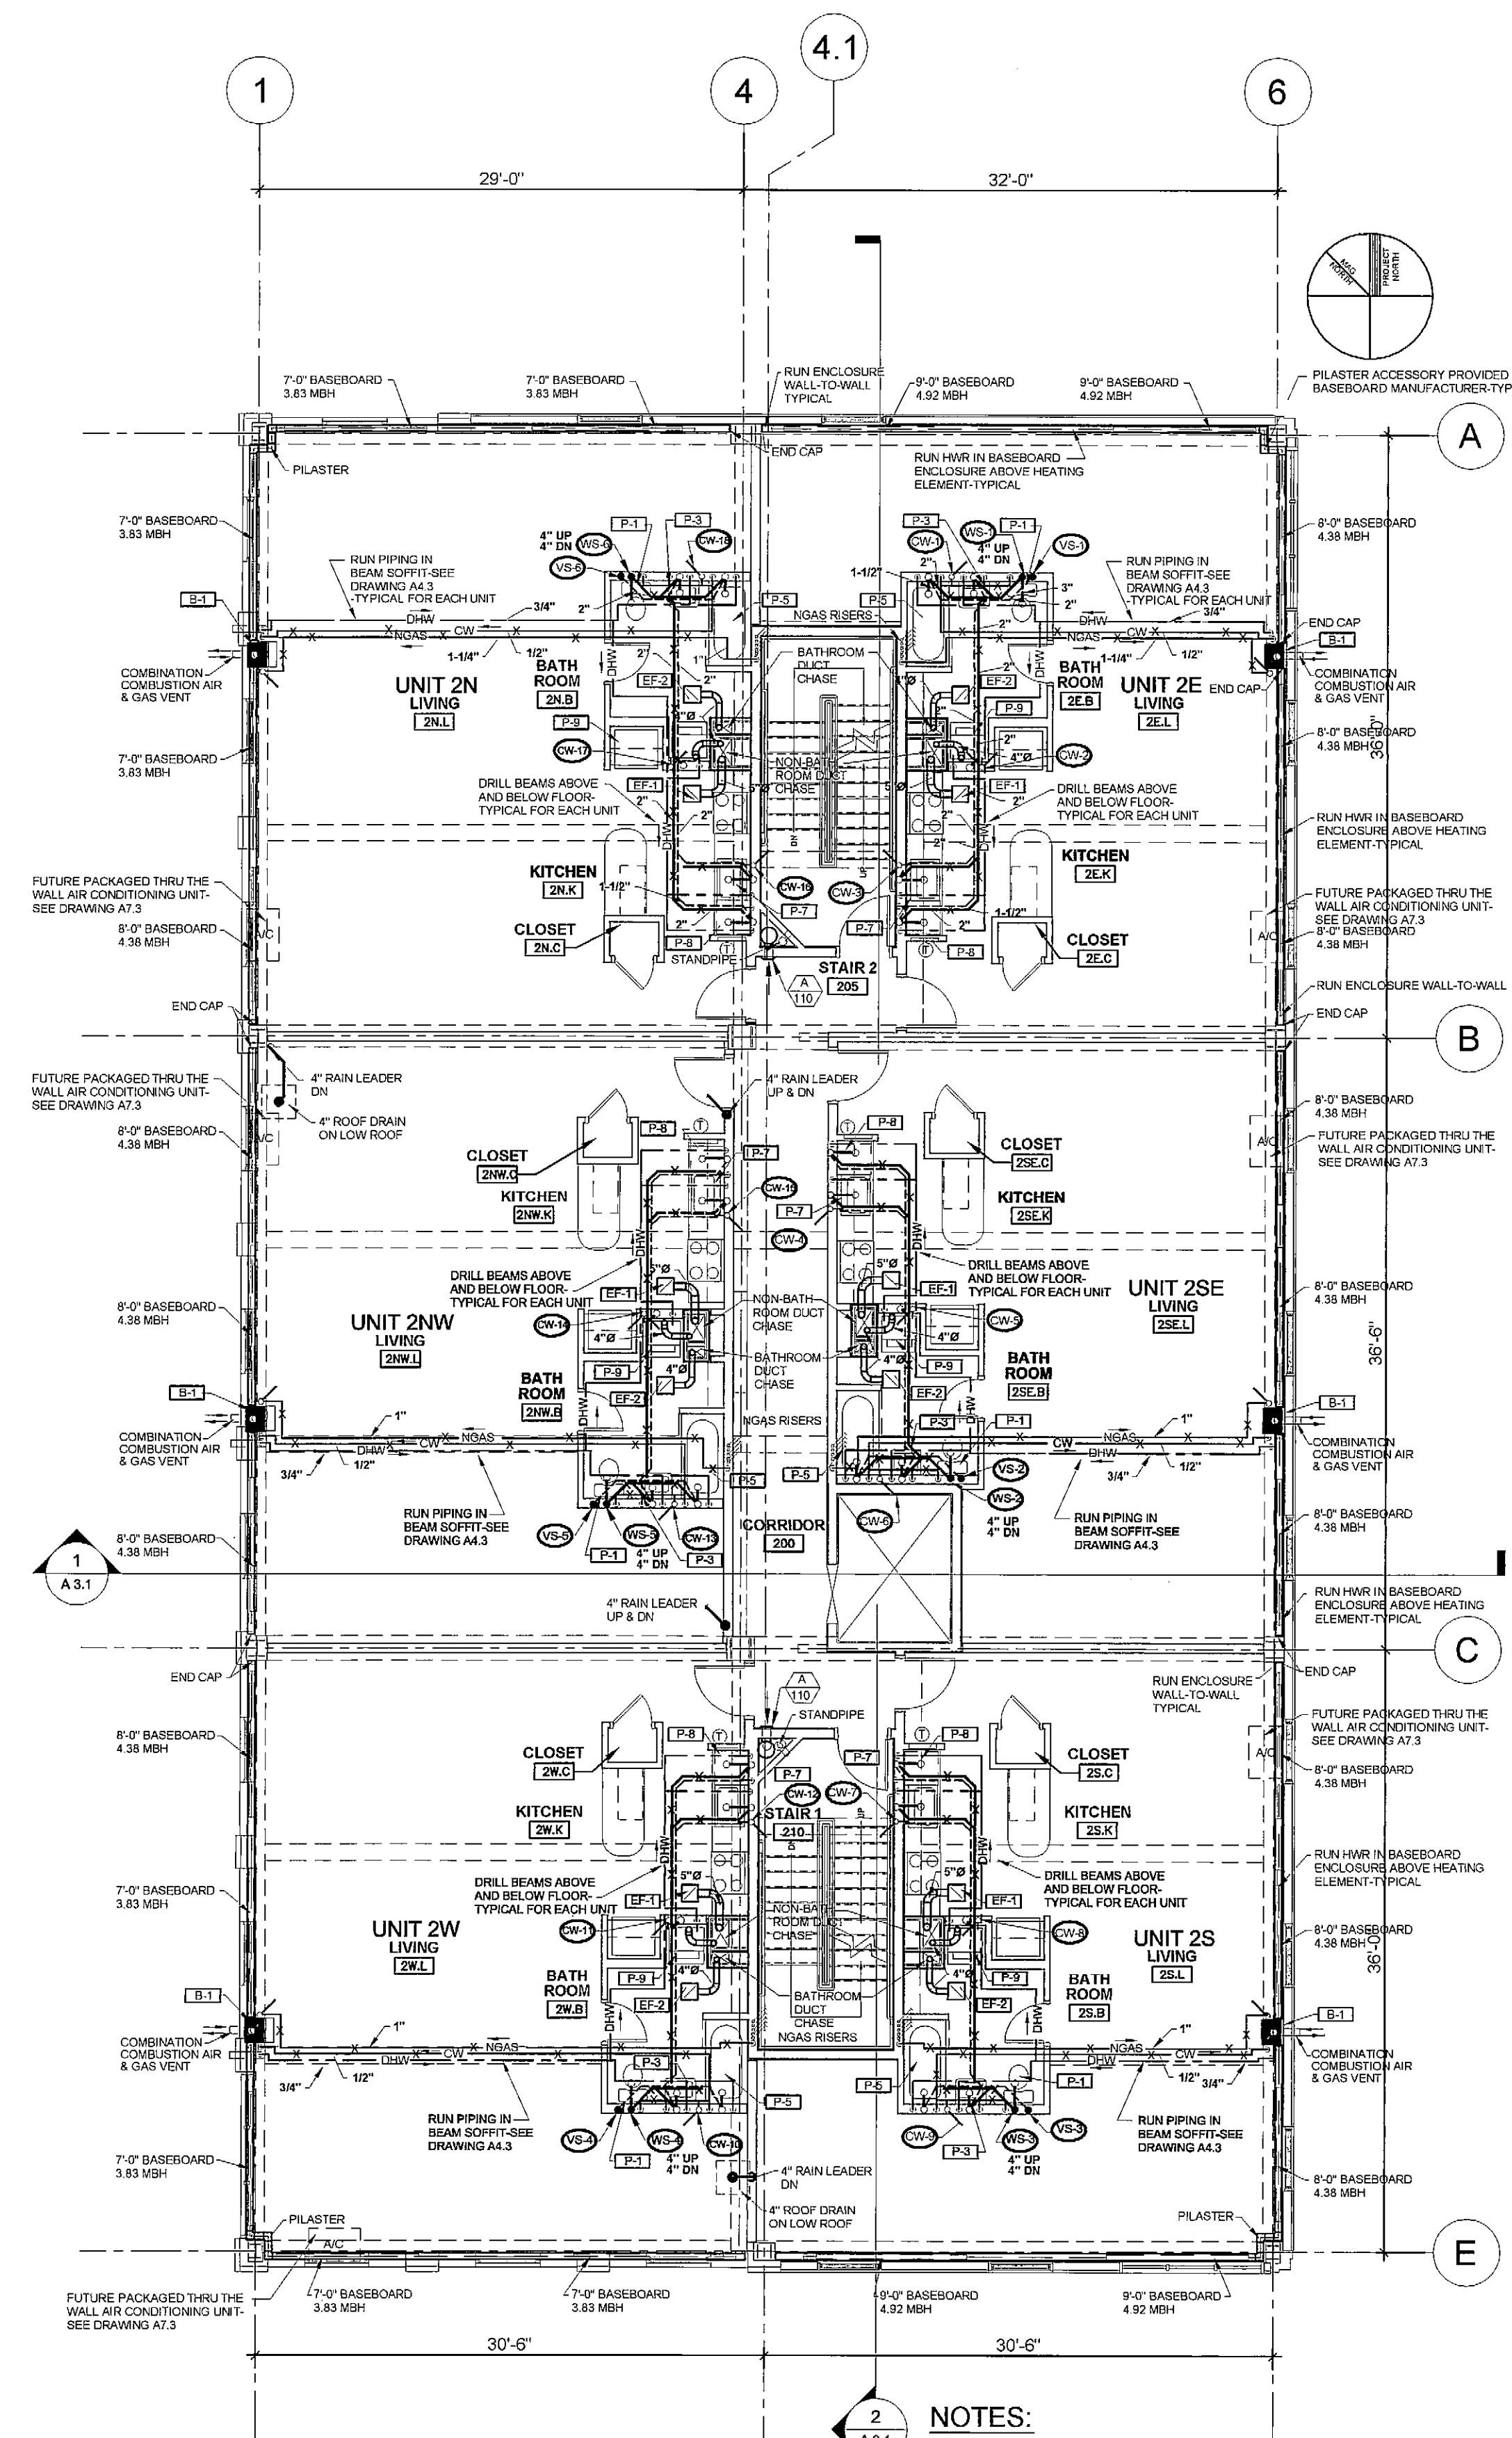

2 SECOND FLOOR MECHANICAL PLAN
A2.1 1/8" = 1'-0"

NOTES:
1. TURN ALL EXHAUST DUCTS UP IN CHASE AND TERMINATE 22" ABOVE BOTTOM OF DUCT
2. EF-1 DUCT 5"Ø, EF-2 DUCT 4"Ø

100% CONSTRUCTION DOCUMENTS 02-24-06