

© 2005 TFH ARCHITECTS

**CHESTNUT STREET LOFTS**  
URBAN REVITALIZATION PROJECT  
BY CHESTNUT STREET LLC,  
PORTLAND, MAINE


**TFH ARCHITECTS**  
100 COMMERCIAL STREET  
PORTLAND MAINE 04101  
TELEPHONE 207 775 6141  
ARCHITECTURE PLANNING

**CONSULTANTS:**  
**CIVIL:**  
Land Use Consultants  
968 Riverside Street  
Portland, ME 04103  
207-678-8213  
**STRUCTURAL:**  
Structural Design Consulting  
22 Orono Drive  
Old Orchard Beach, ME 04054  
207-926-4006  
**MECHANICAL:**  
Whitney Engineering  
10 Dunbar Street  
Portland, ME 04101  
207-874-7449  
**ELECTRICAL:**  
Bennett Engineering  
7 Bennett Street  
Falmouth, ME 04032  
207-665-0476


**REVISIONS:**  
Re-issued by Addendum #1  
01-20-06  
100% Construction Documents  
02-24-06  
DATE: February 24, 2006  
PROJECT No. 0422  
DRAWN BY: RPW  
CHECKED BY: RPW  
SCALE: AS NOTED

SHEET TITLE:  
**MECHANICAL  
THIRD & FOURTH  
FLOOR PLANS**

**M1.2**

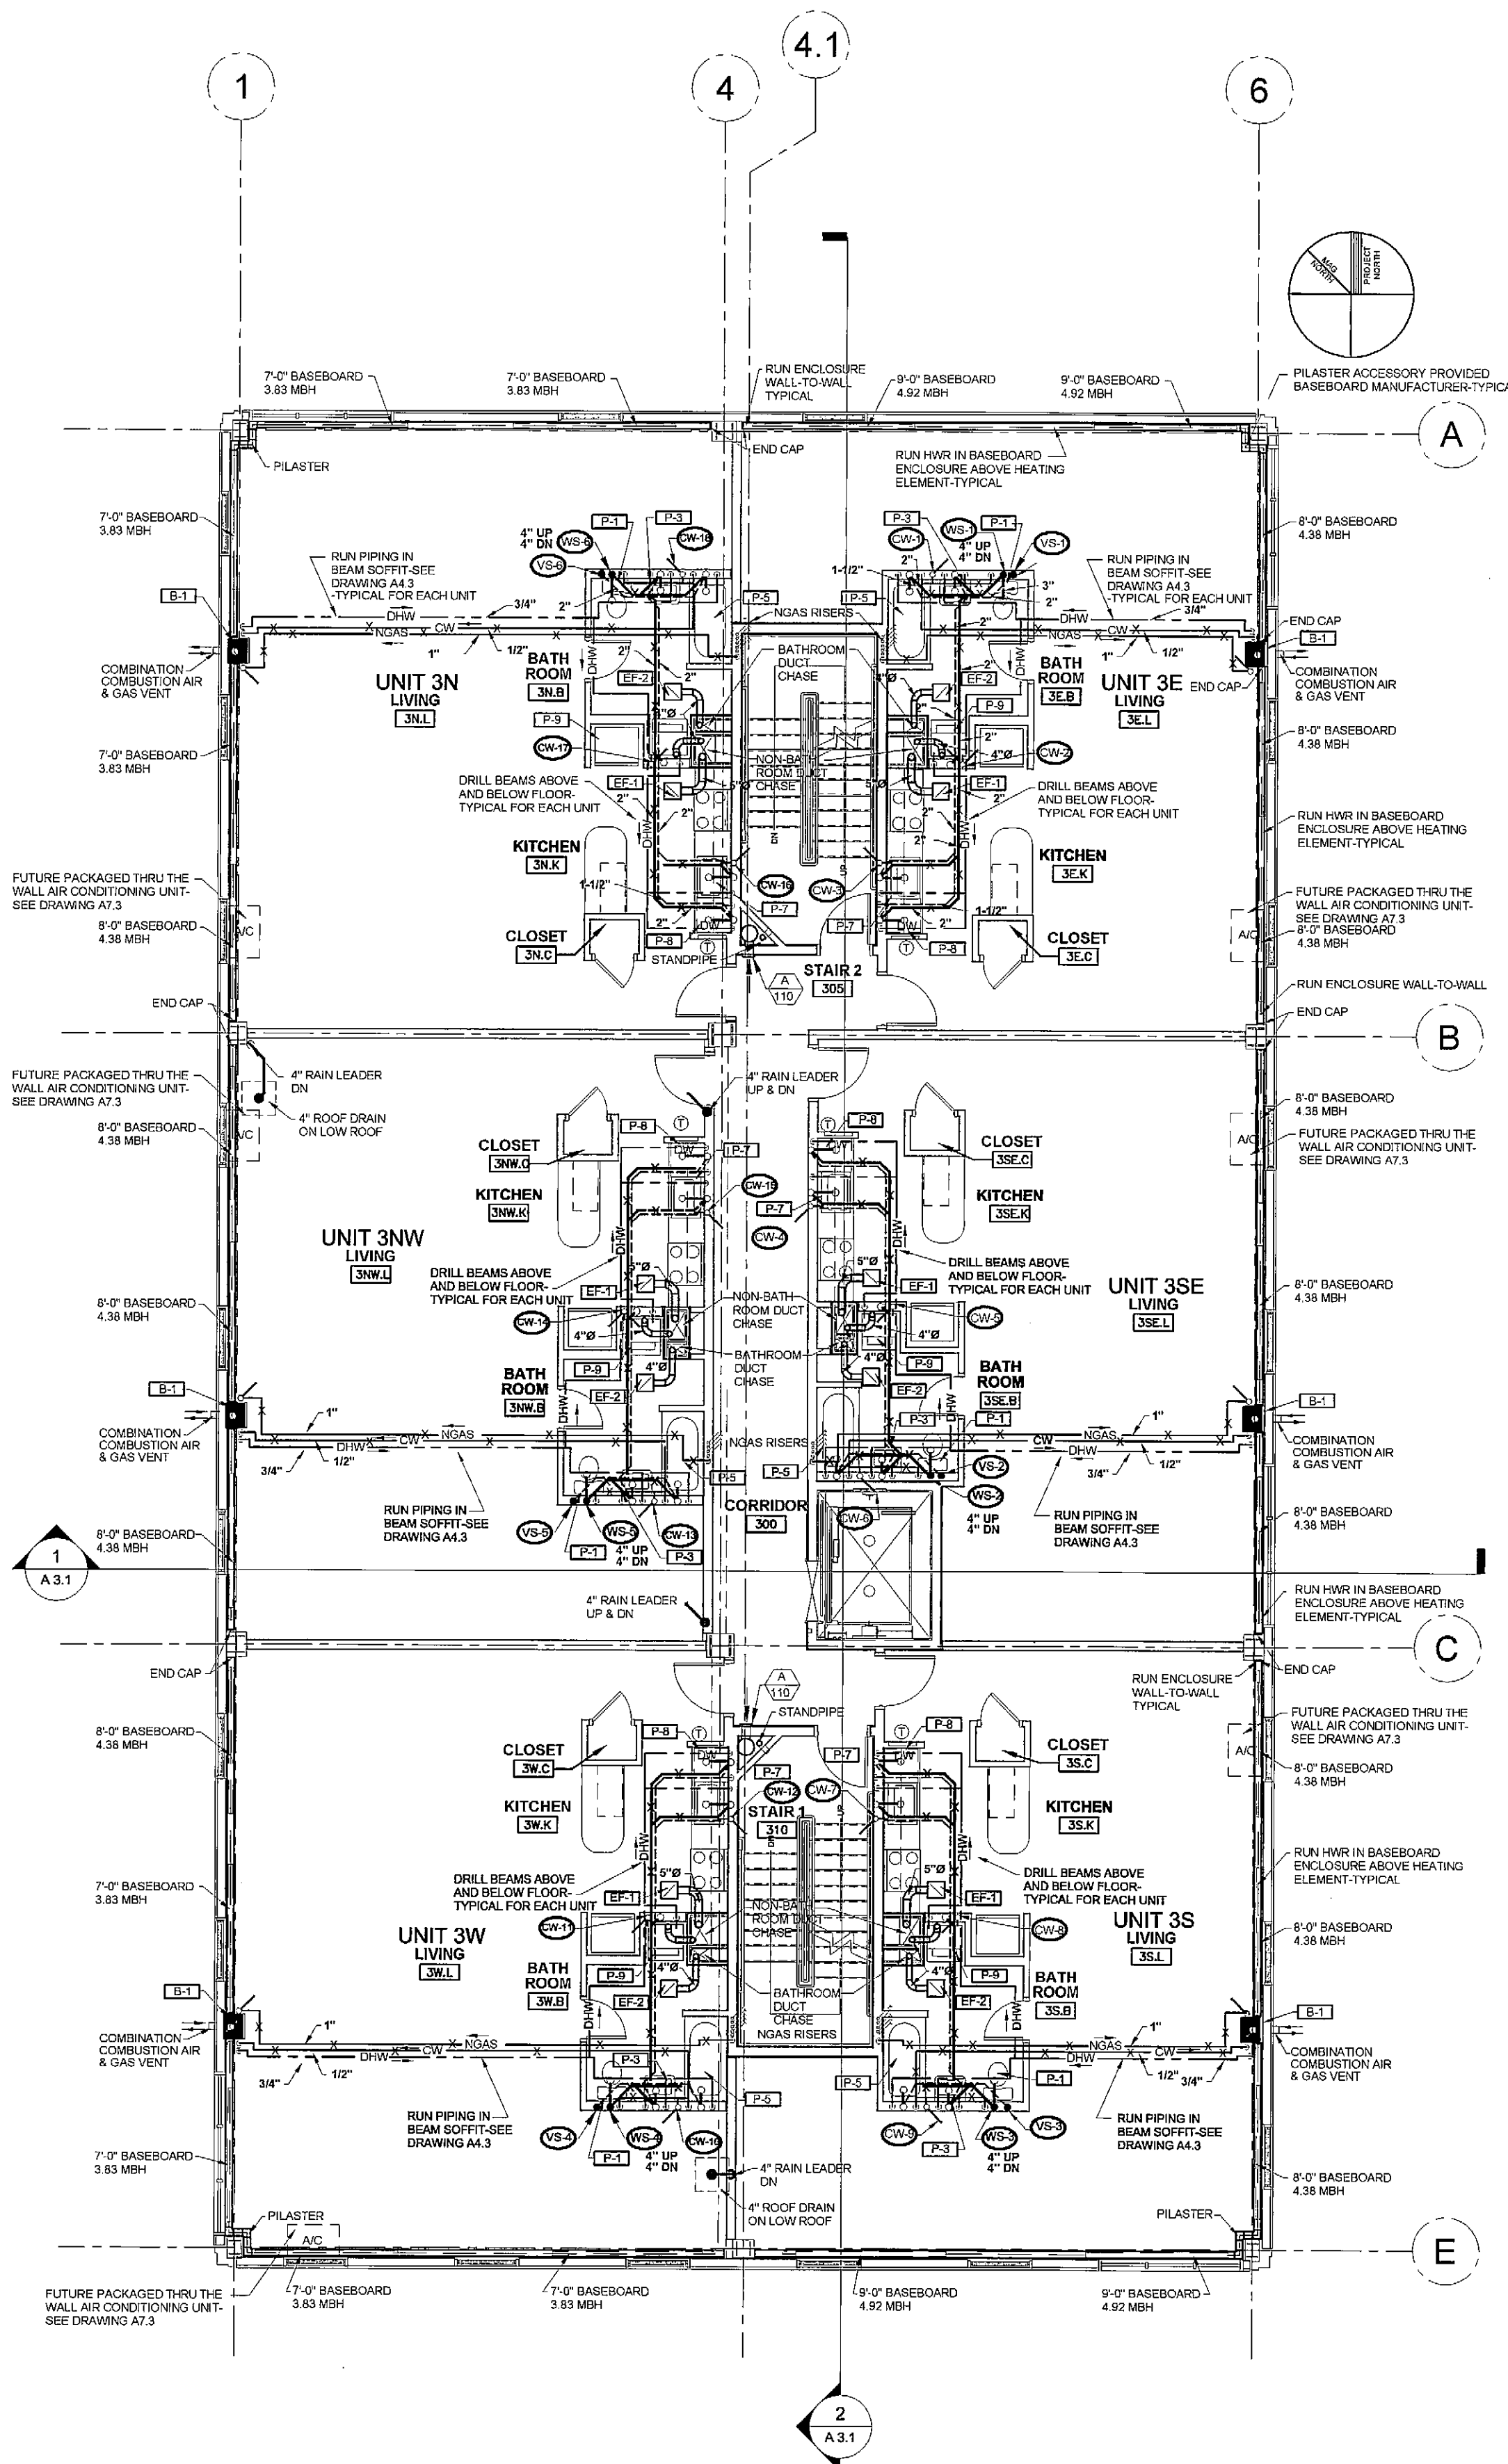

**1** THIRD FLOOR MECHANICAL PLAN  
1/8" = 1'-0"

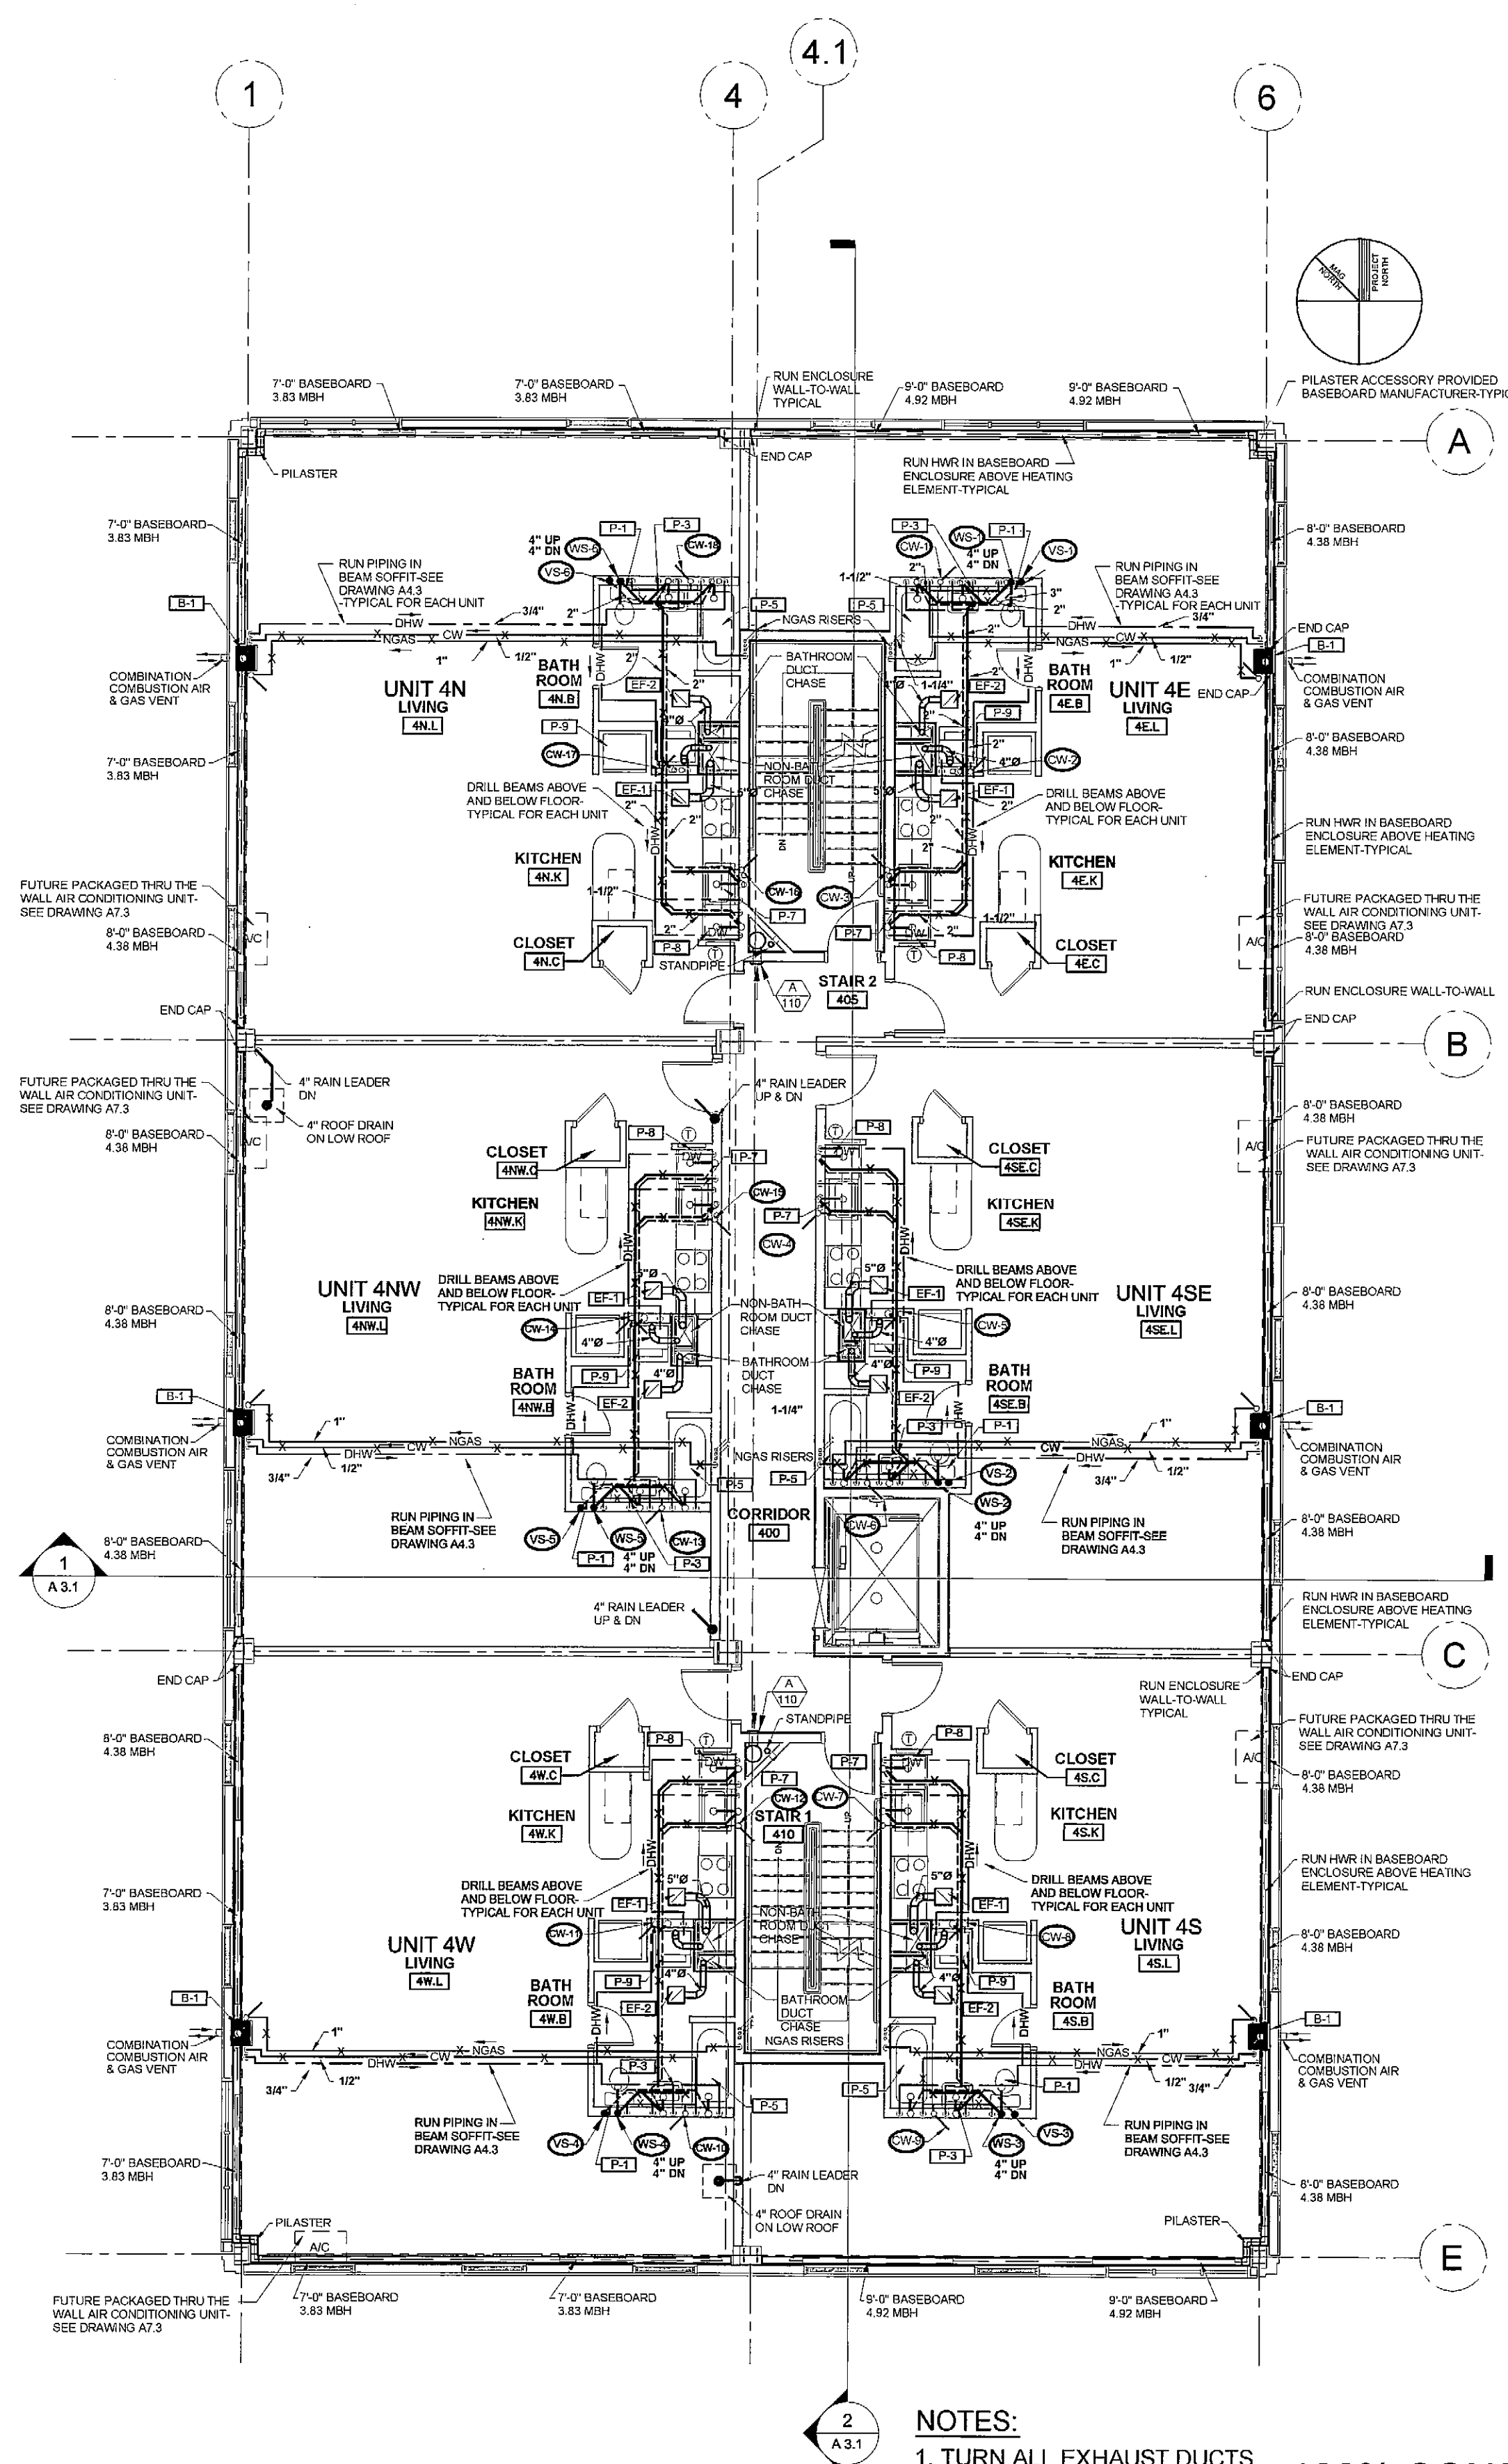

**2** FOURTH FLOOR MECHANICAL PLAN  
1/8" = 1'-0"

**NOTES:**  
1. TURN ALL EXHAUST DUCTS UP IN CHASE AND TERMINATE 22" ABOVE BOTTOM OF DUCT  
2. EF-1 DUCT 5"Ø, EF-2 DUCT 4"Ø

**100% CONSTRUCTION DOCUMENTS 02-24-06**