


© 2005 TFH ARCHITECTS

CHESTNUT STREET LOFTS

URBAN REVITALIZATION PROJECT
BY CHESTNUT STREET LLC.
PORTLAND, MAINE

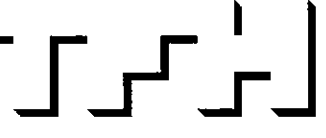


TFH ARCHITECTS
100 COMMERCIAL STREET
PORTLAND MAINE 04101
TELEPHONE 207 775 6141
ARCHITECTURE PLANNING

CONSULTANTS:
SHELL
Lead Use Consultants
968 Riverside Street
Portland, ME 04103
207-778-5313
STRUCTURAL
Structural Design Consulting
27 Oakmont Drive
Oak Orchard Beach, ME 04064
207-534-8038
MECHANICAL
Whitney Engineering
10 Darford Street
Portland, ME 04101
207-474-7449
ELECTRICAL
Brower Engineering
7 Banner Road
Falmouth, ME 04032
207-655-6475


REVISIONS:
Re-issued by Addendum #1
01-20-06
100% Construction Documents
02-24-06
DATE: February 24, 2006
PROJECT No. 0422
DRAWN BY: RPW
CHECKED BY: RPW
SCALE: AS NOTED

SHEET TITLE:
MECHANICAL
FIFTH AND SIXTH
FLOOR PLANS

M1.3

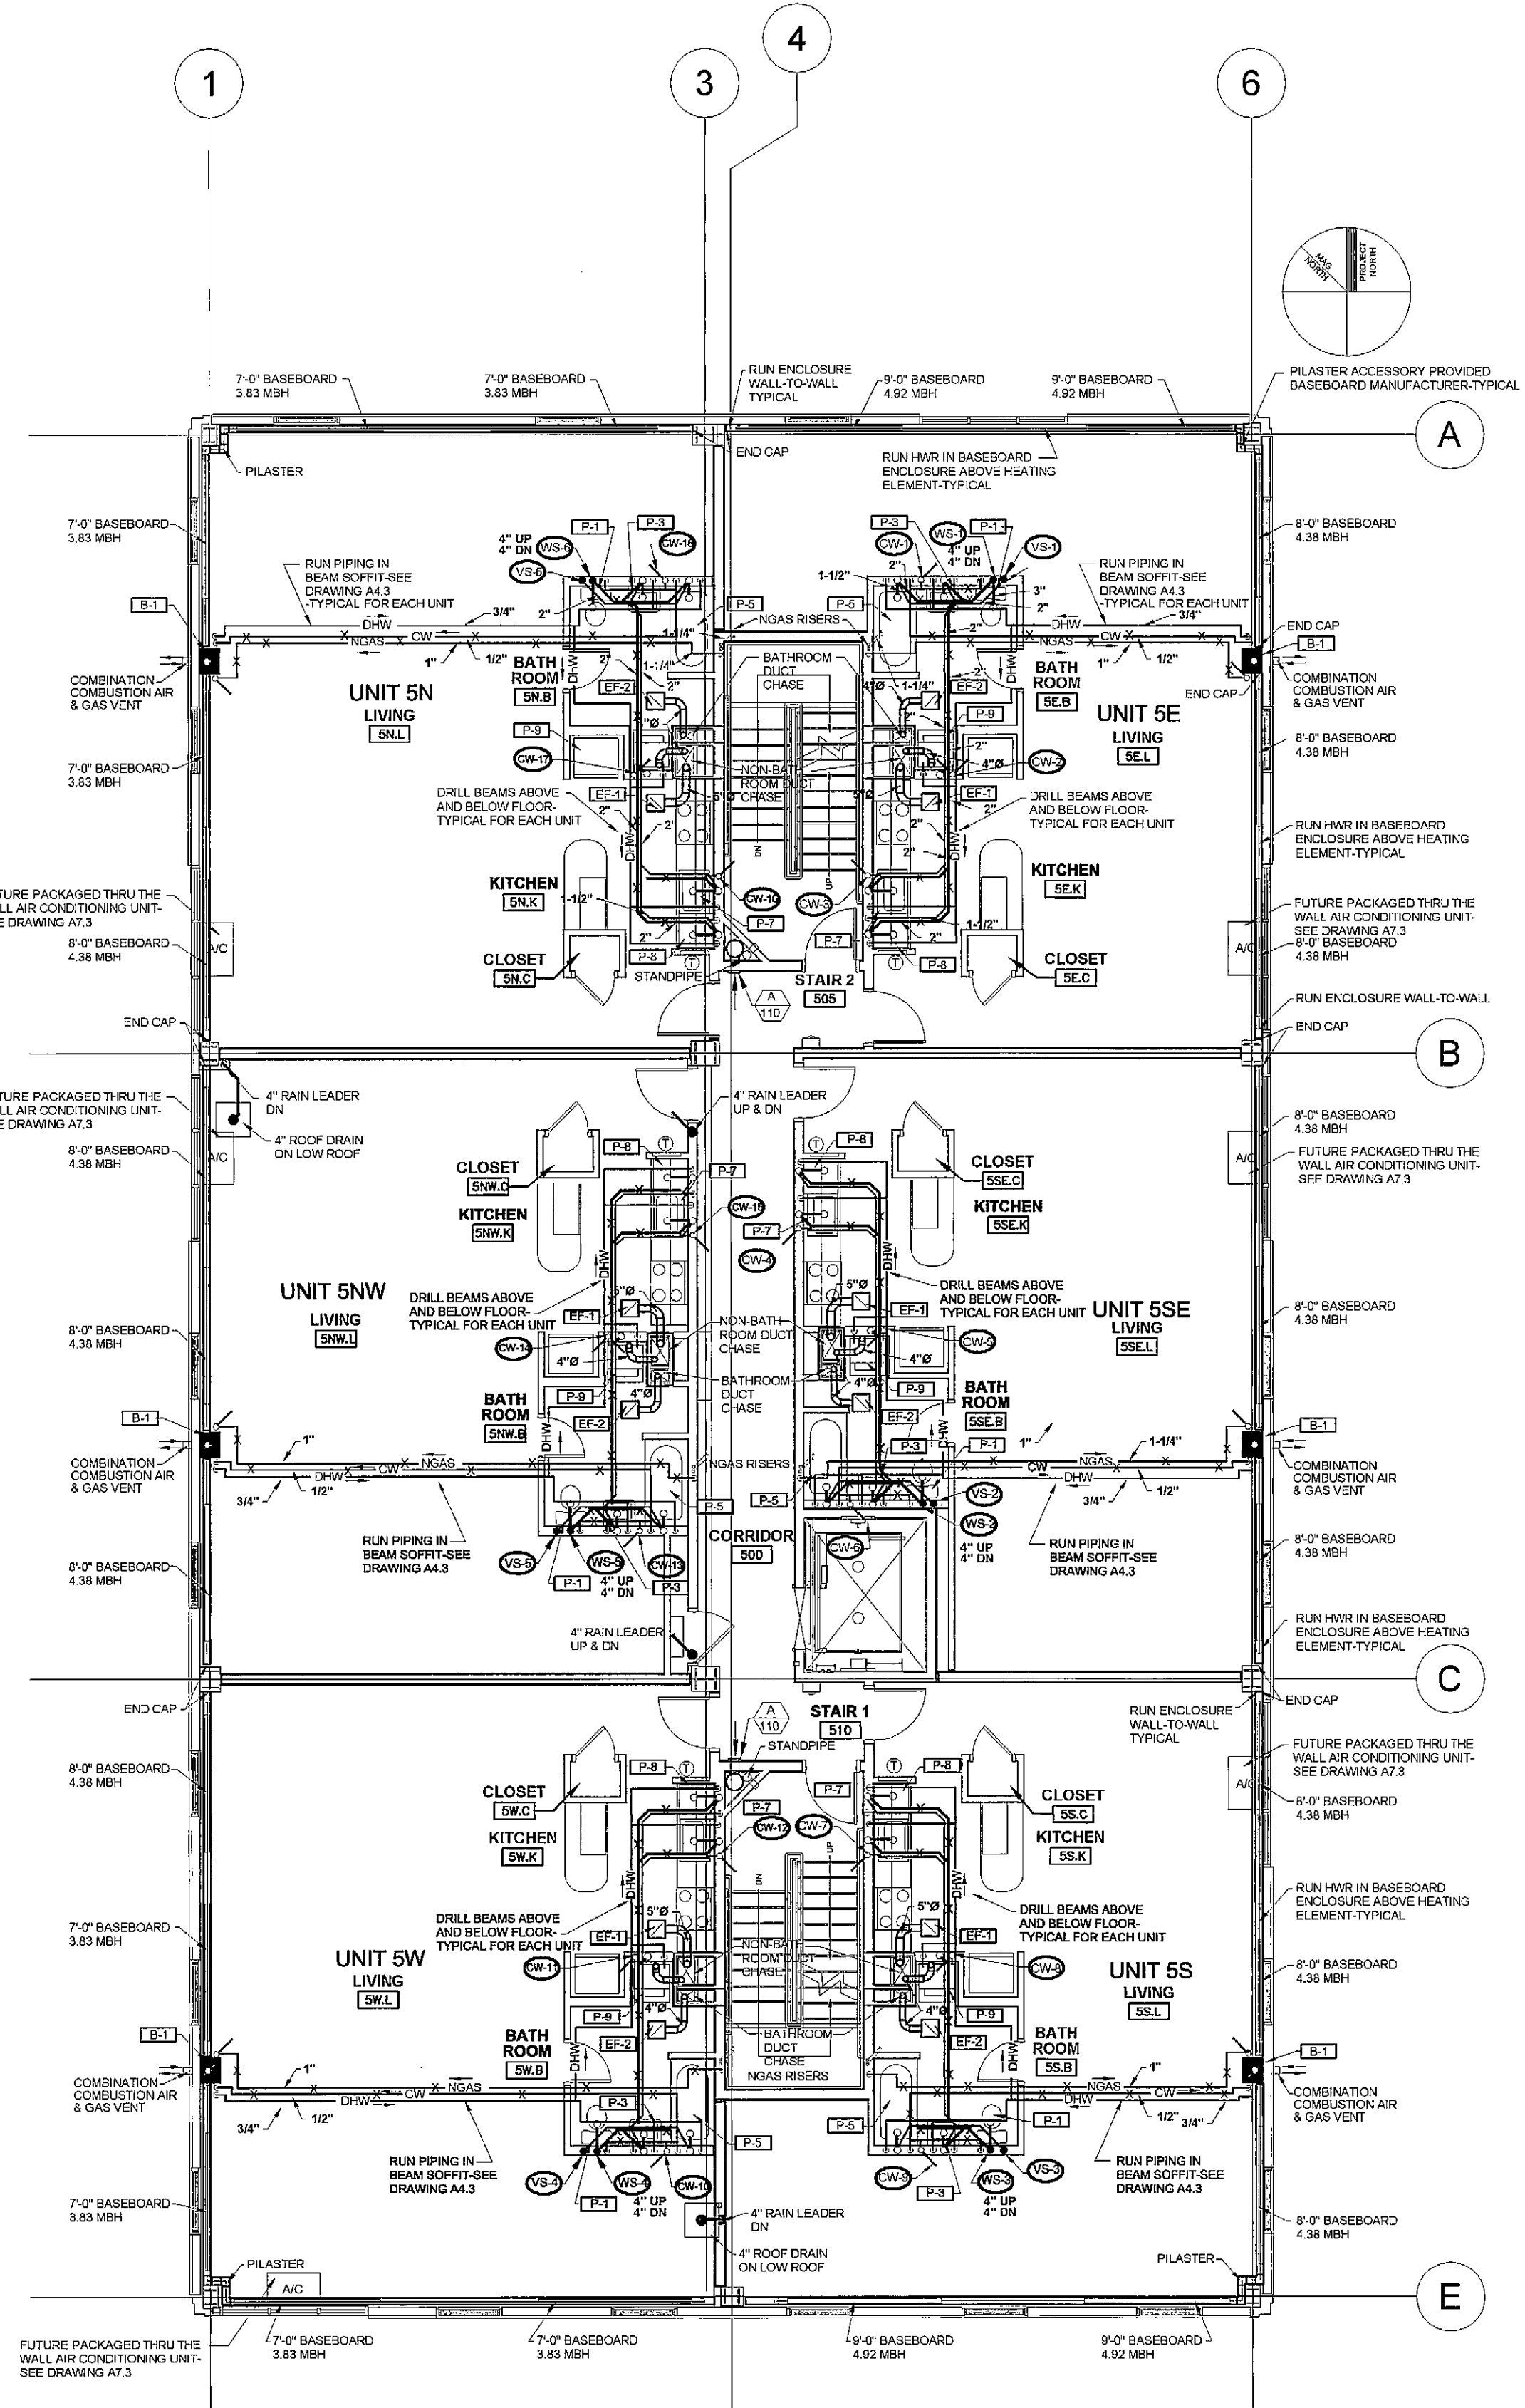

1 FIFTH FLOOR MECHANICAL PLAN
A1.3 1/8" = 1'-0"

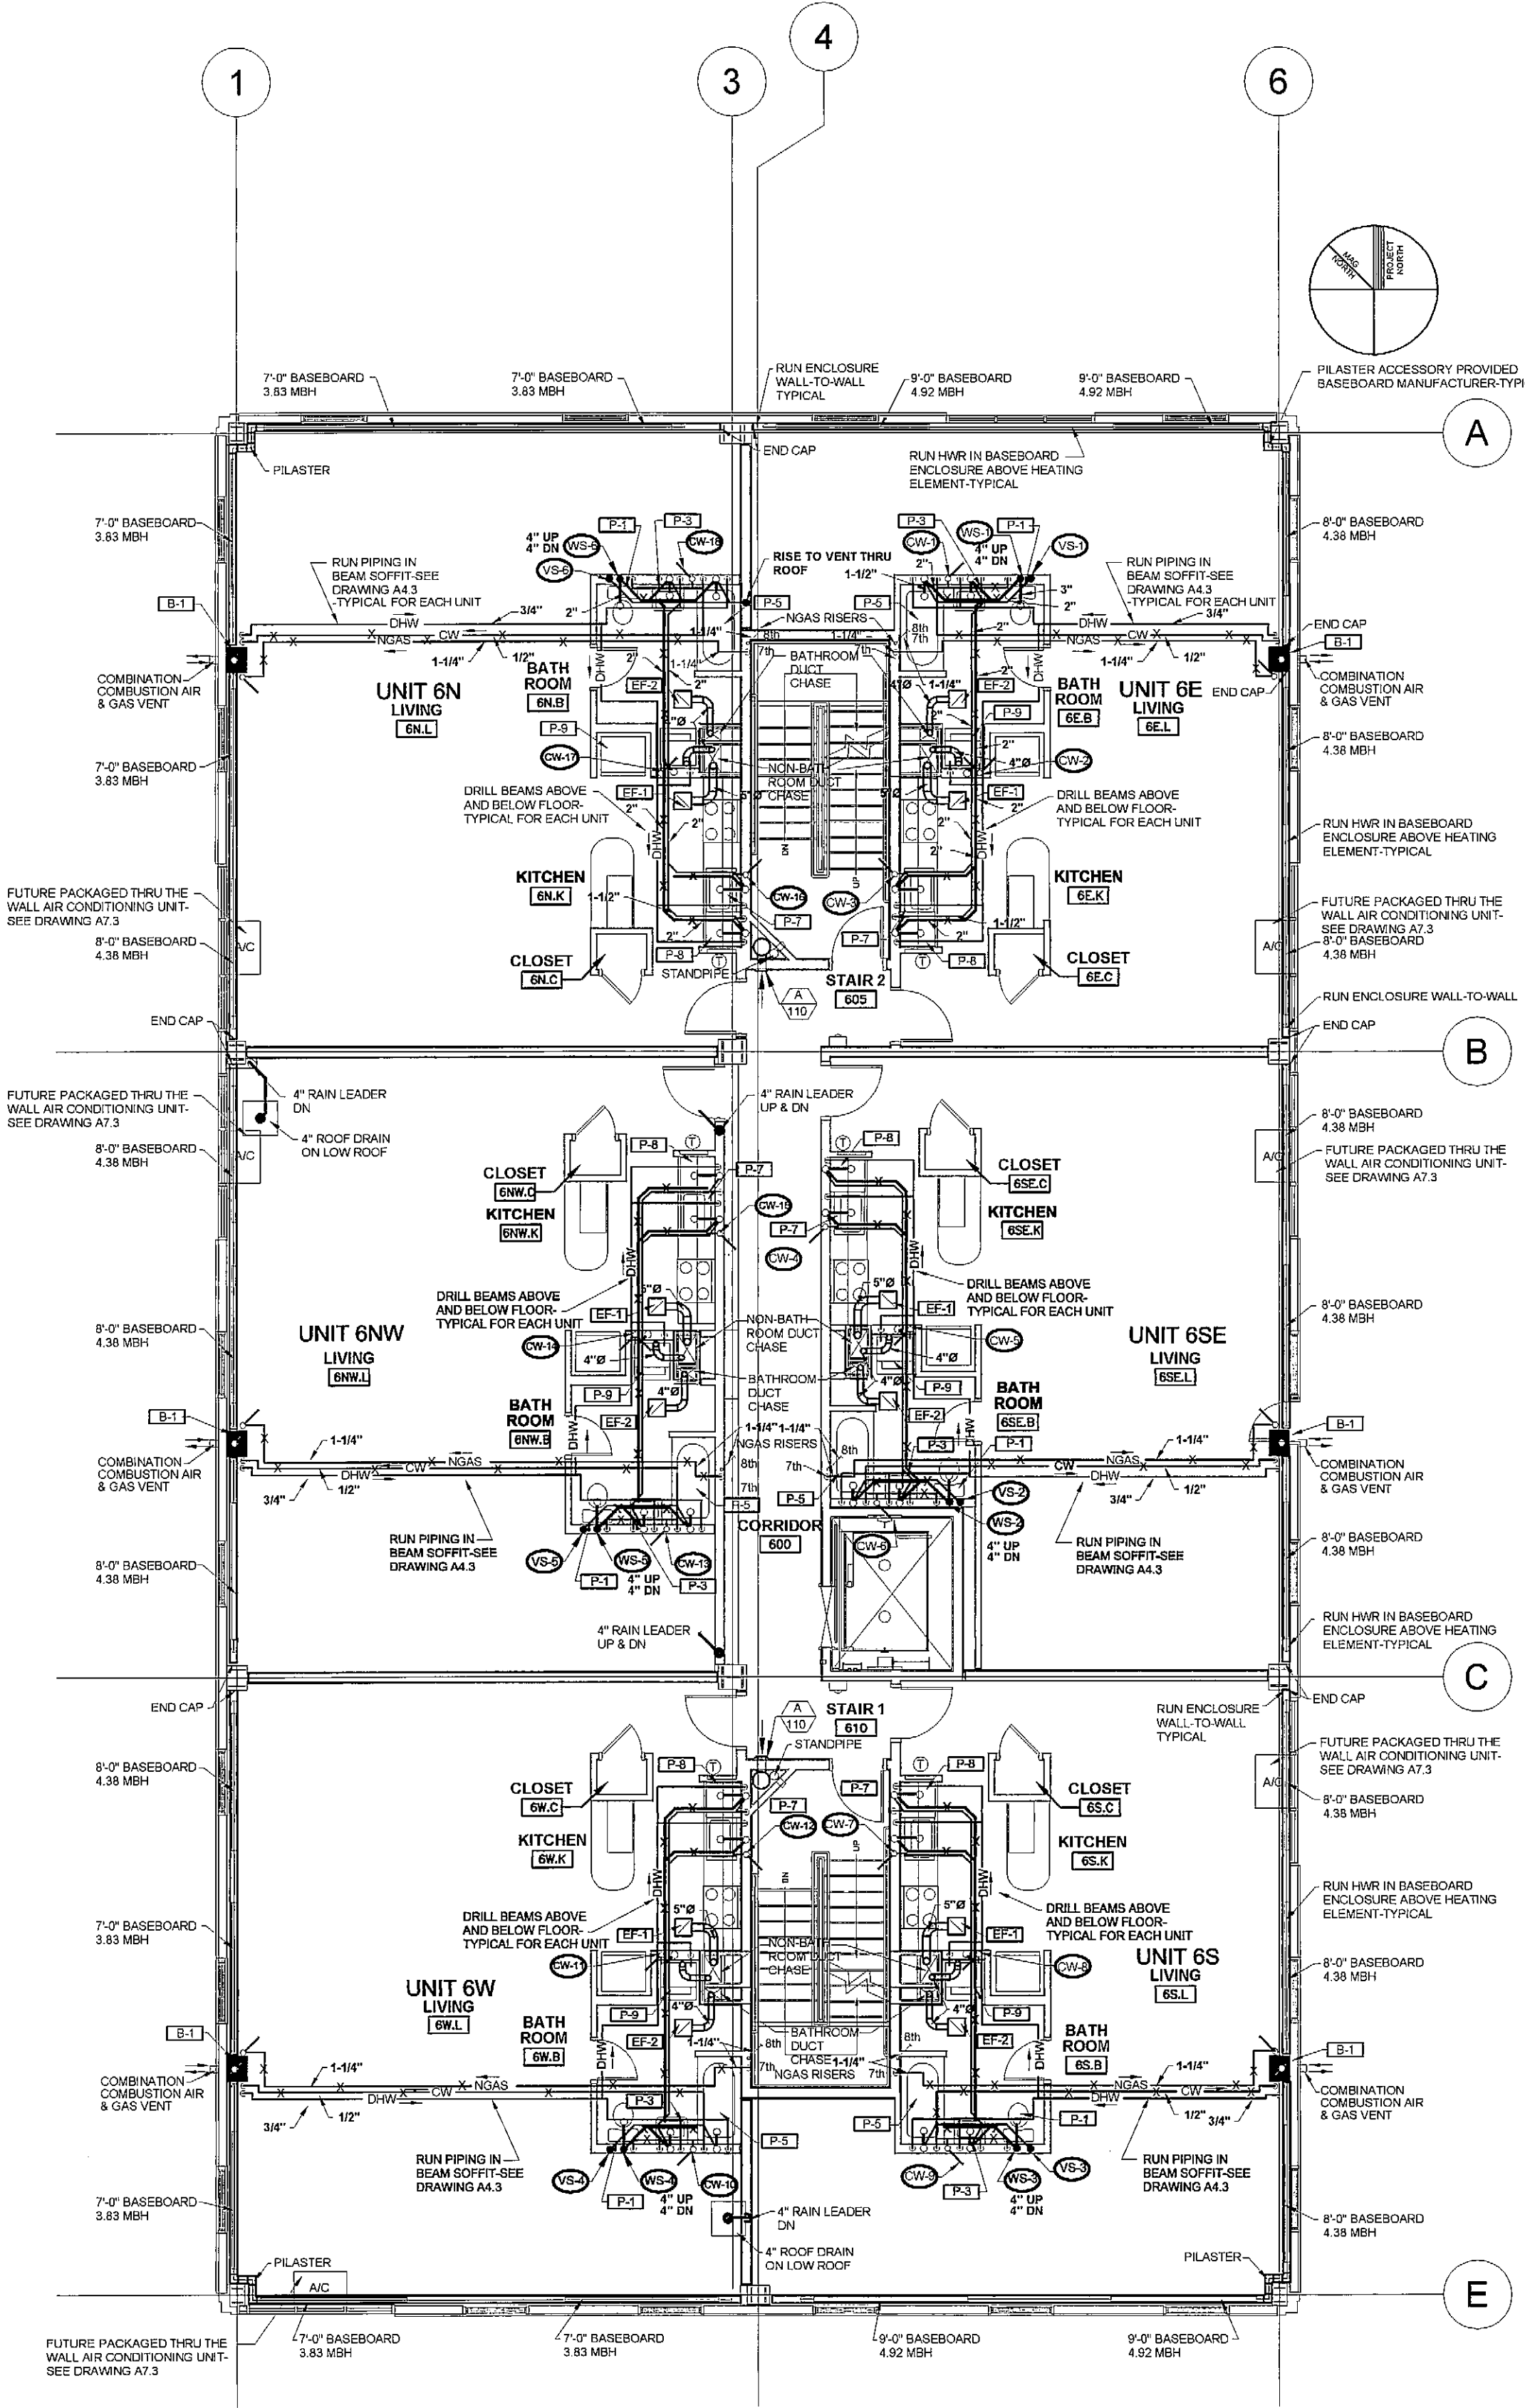

2 SIXTH FLOOR MECHANICAL PLAN
A1.3 1/8" = 1'-0"

NOTES:
1. TURN ALL EXHAUST DUCTS UP IN CHASE AND TERMINATE 22" ABOVE BOTTOM OF DUCT
2. EF-1 DUCT 5"Ø, EF-2 DUCT 4"Ø
100% CONSTRUCTION DOCUMENTS 02-24-06