


© 2005 TFH ARCHITECTS

CHESTNUT STREET LOFTS

URBAN REVITALIZATION PROJECT
BY CHESTNUT STREET LLC,
PORTLAND, MAINE

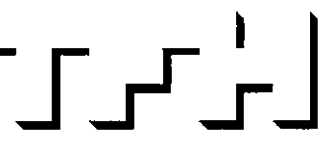

TFH ARCHITECTS
100 COMMERCIAL STREET
PORTLAND MAINE 04101
TELEPHONE 207 775 6141
ARCHITECTURE PLANNING

CONSULTANTS:


- CIVIL:**
Lead Use Consultants
966 Riverside Street
Portland, ME 04103
207-878-3313
- STRUCTURAL:**
Structural Design Consulting
22 Chalmers Drive
Old Orchard Beach, ME 04064
207-934-8038
- MECHANICAL:**
Whitney Engineering
10 Danforth Street
Portland, ME 04101
207-874-7449
- ELECTRICAL:**
Barnett Engineering
7 Bennett Road
Fryeburg, ME 04032
207-695-6475

REVISIONS:


- Re-issued by Addendum #1
01-20-06
- 100% Construction Documents
02-24-06
- DATE: February 24, 2006
- PROJECT No. 0422
- DRAWN BY: RPW
- CHECKED BY: RPW
- SCALE: AS NOTED

SHEET TITLE:
SEVENTH AND
EIGHTH
FLOOR PLANS

M1.4

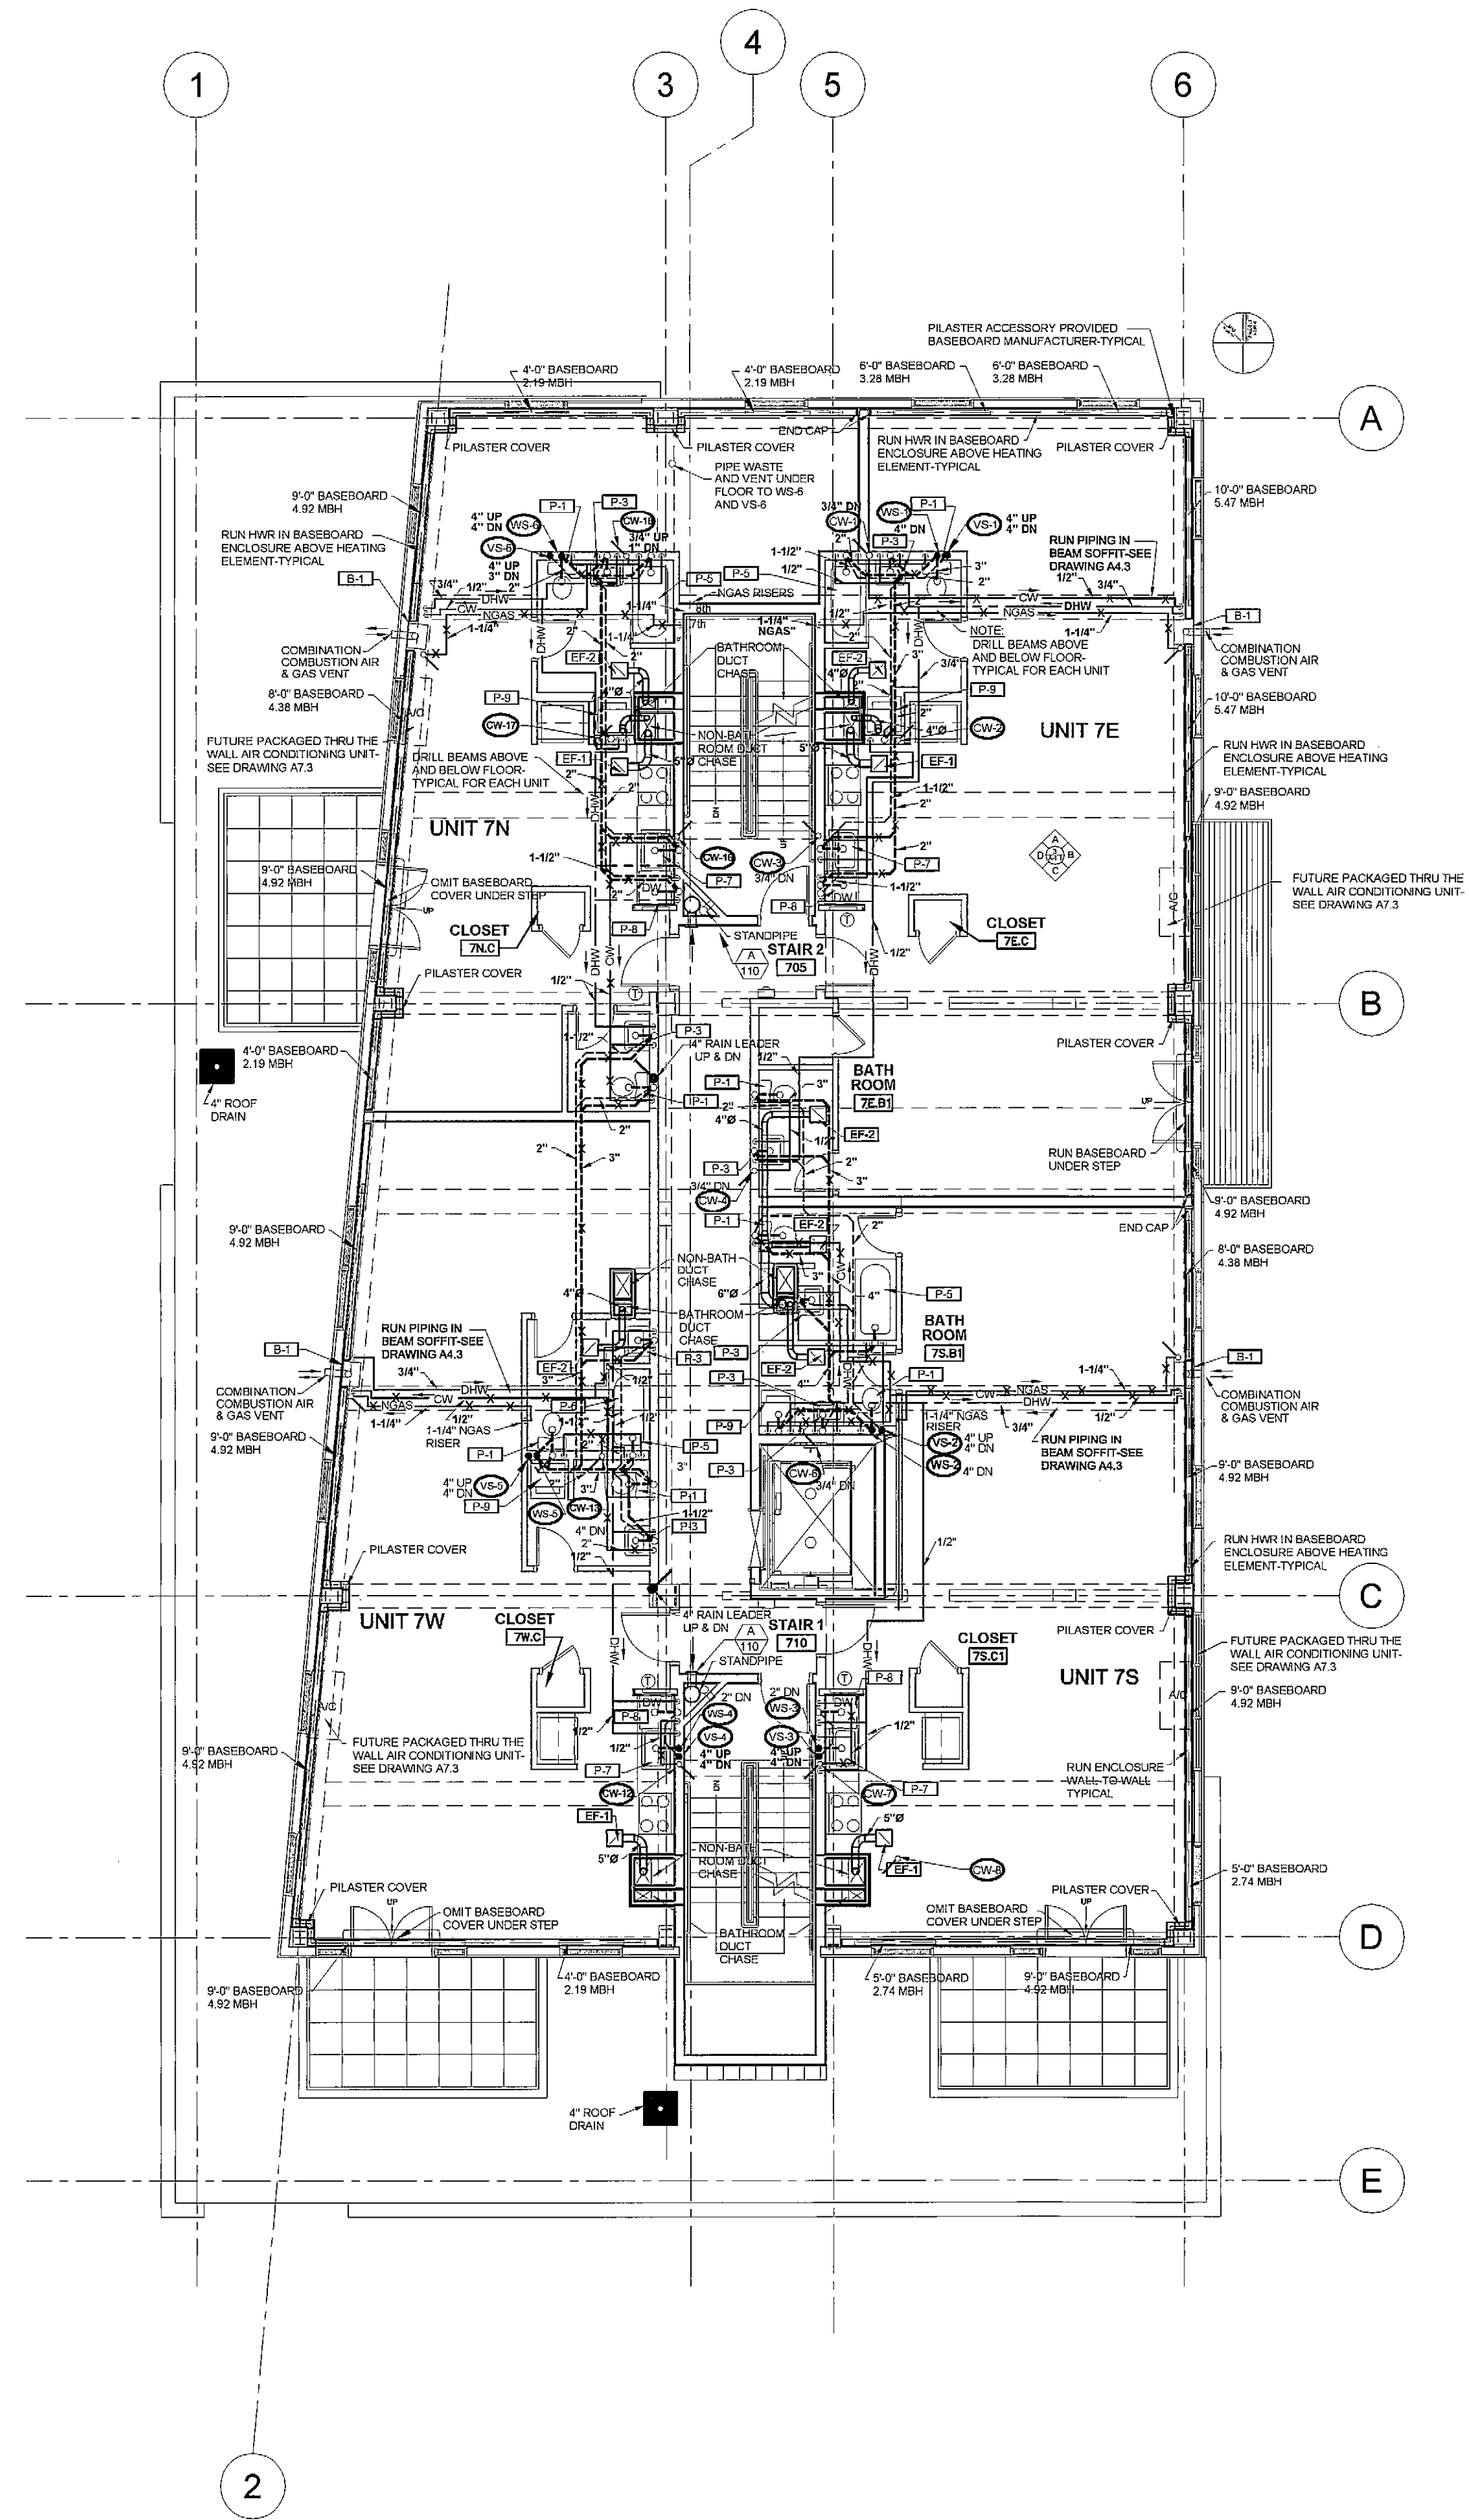

1 SEVENTH FLOOR MECHANICAL PLAN
A1.4 1/8" = 1'-0"

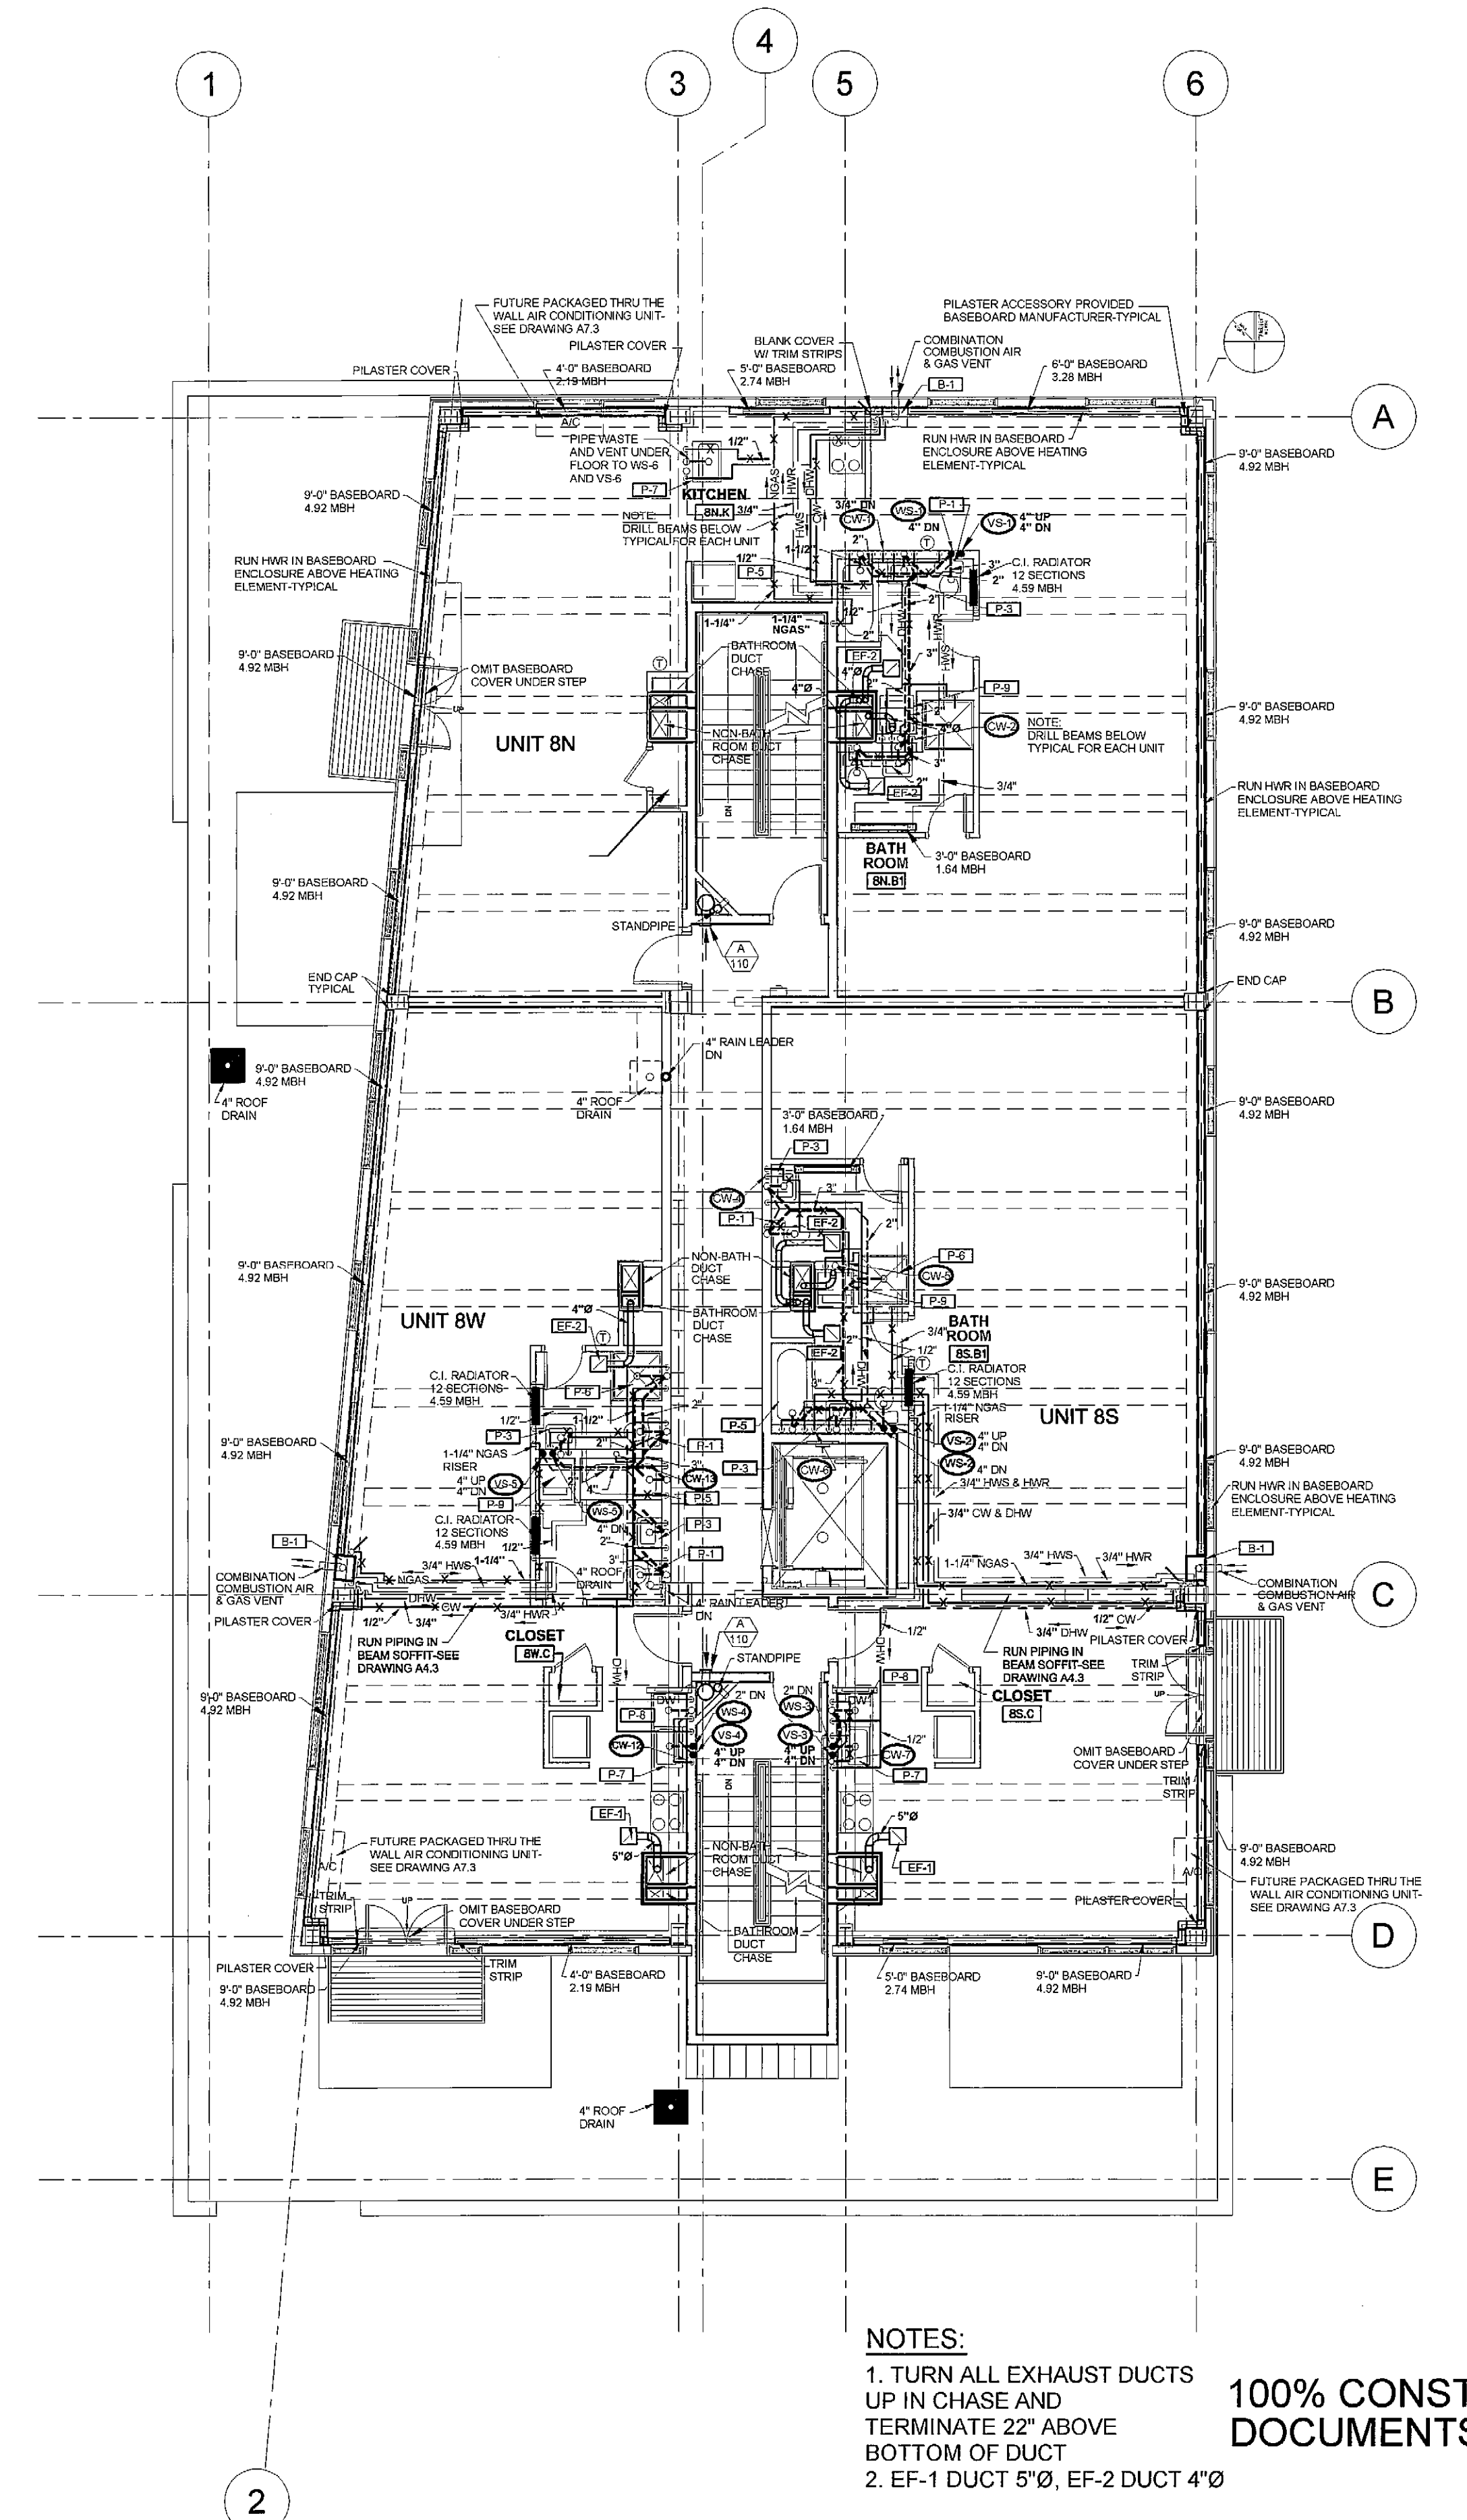

2 EIGHTH FLOOR MECHANICAL PLAN
A1.4 1/8" = 1'-0"

NOTES:
1. TURN ALL EXHAUST DUCTS UP IN CHASE AND TERMINATE 22" ABOVE BOTTOM OF DUCT
2. EF-1 DUCT 5"Ø, EF-2 DUCT 4"Ø

100% CONSTRUCTION DOCUMENTS 02-24-06