


© 2005 TFH ARCHITECTS

CHESTNUT STREET LOFTS
URBAN REVITALIZATION PROJECT
BY CHESTNUT STREET LLC.
PORTLAND, MAINE

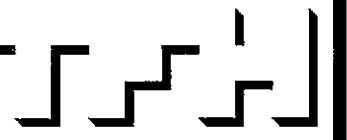

TFH ARCHITECTS
100 COMMERCIAL STREET
PORTLAND MAINE 04101
TELEPHONE 207 775 6141
ARCHITECTURE PLANNING

CONSULTANTS:
CIVIL:
Land Use Consultants
950 Riverside Street
Portland, ME 04103
207-676-5313
STRUCTURAL:
Structural Design Consulting
22 Cassewood Drive
Old Orchard Beach, ME 04064
207-534-8538
MECHANICAL:
Wilburly Engineering
10 Danforth Street
Portland, ME 04101
207-674-7460
ELECTRICAL:
Bennett Engineering
7 Bennett Road
Freeport, ME 04032
207-855-9475

REVISIONS:
JAN 2, 2006 BID SET
FEB 9, 2006 PERMIT SET
FEB 23, 2006
CONSTRUCTION
DOCUMENTS

DATE:

PROJECT No. 0422


DRAWN BY: WSBJR SPD

CHECKED BY: CWA WSBJR


SCALE: AS NOTED

SHEET TITLE:
5th,
2nd-4th &
6th FLOOR
ELECTRICAL
PLANS

E1.2

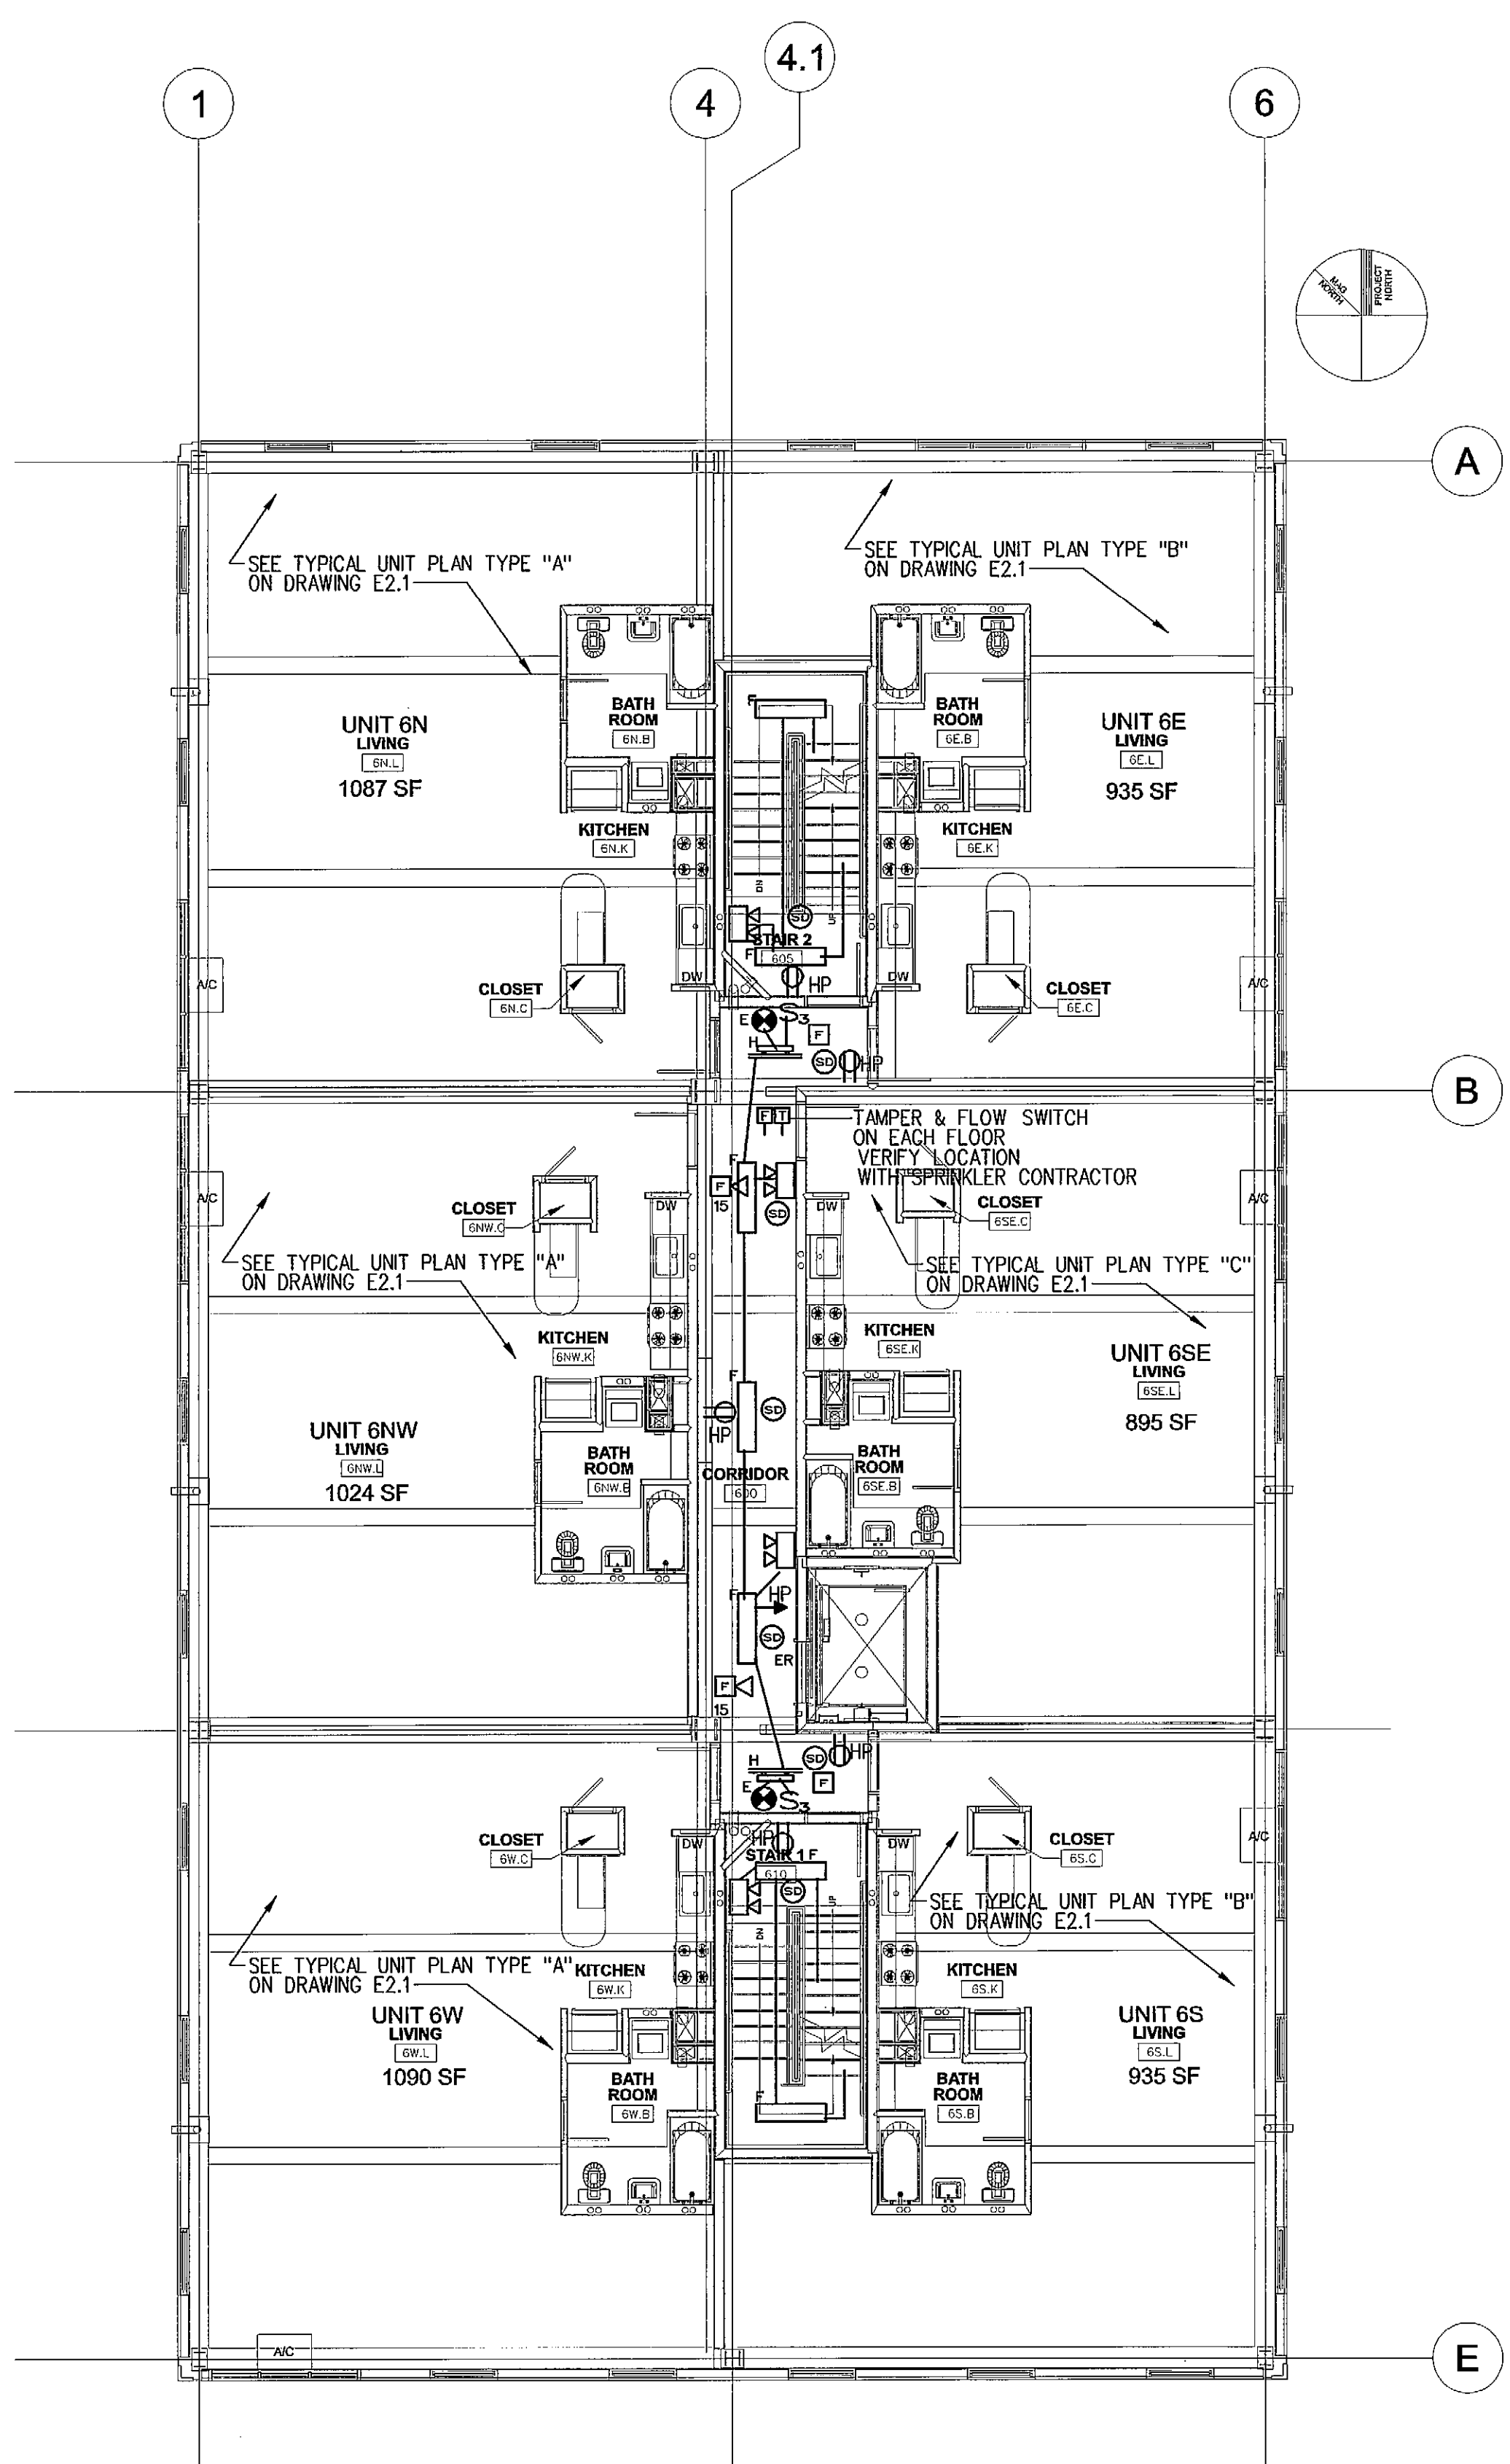

TYPICAL 2ND - 4TH & 6TH FLOOR ELECTRICAL PLAN
SCALE: 1/8"=1'-0"

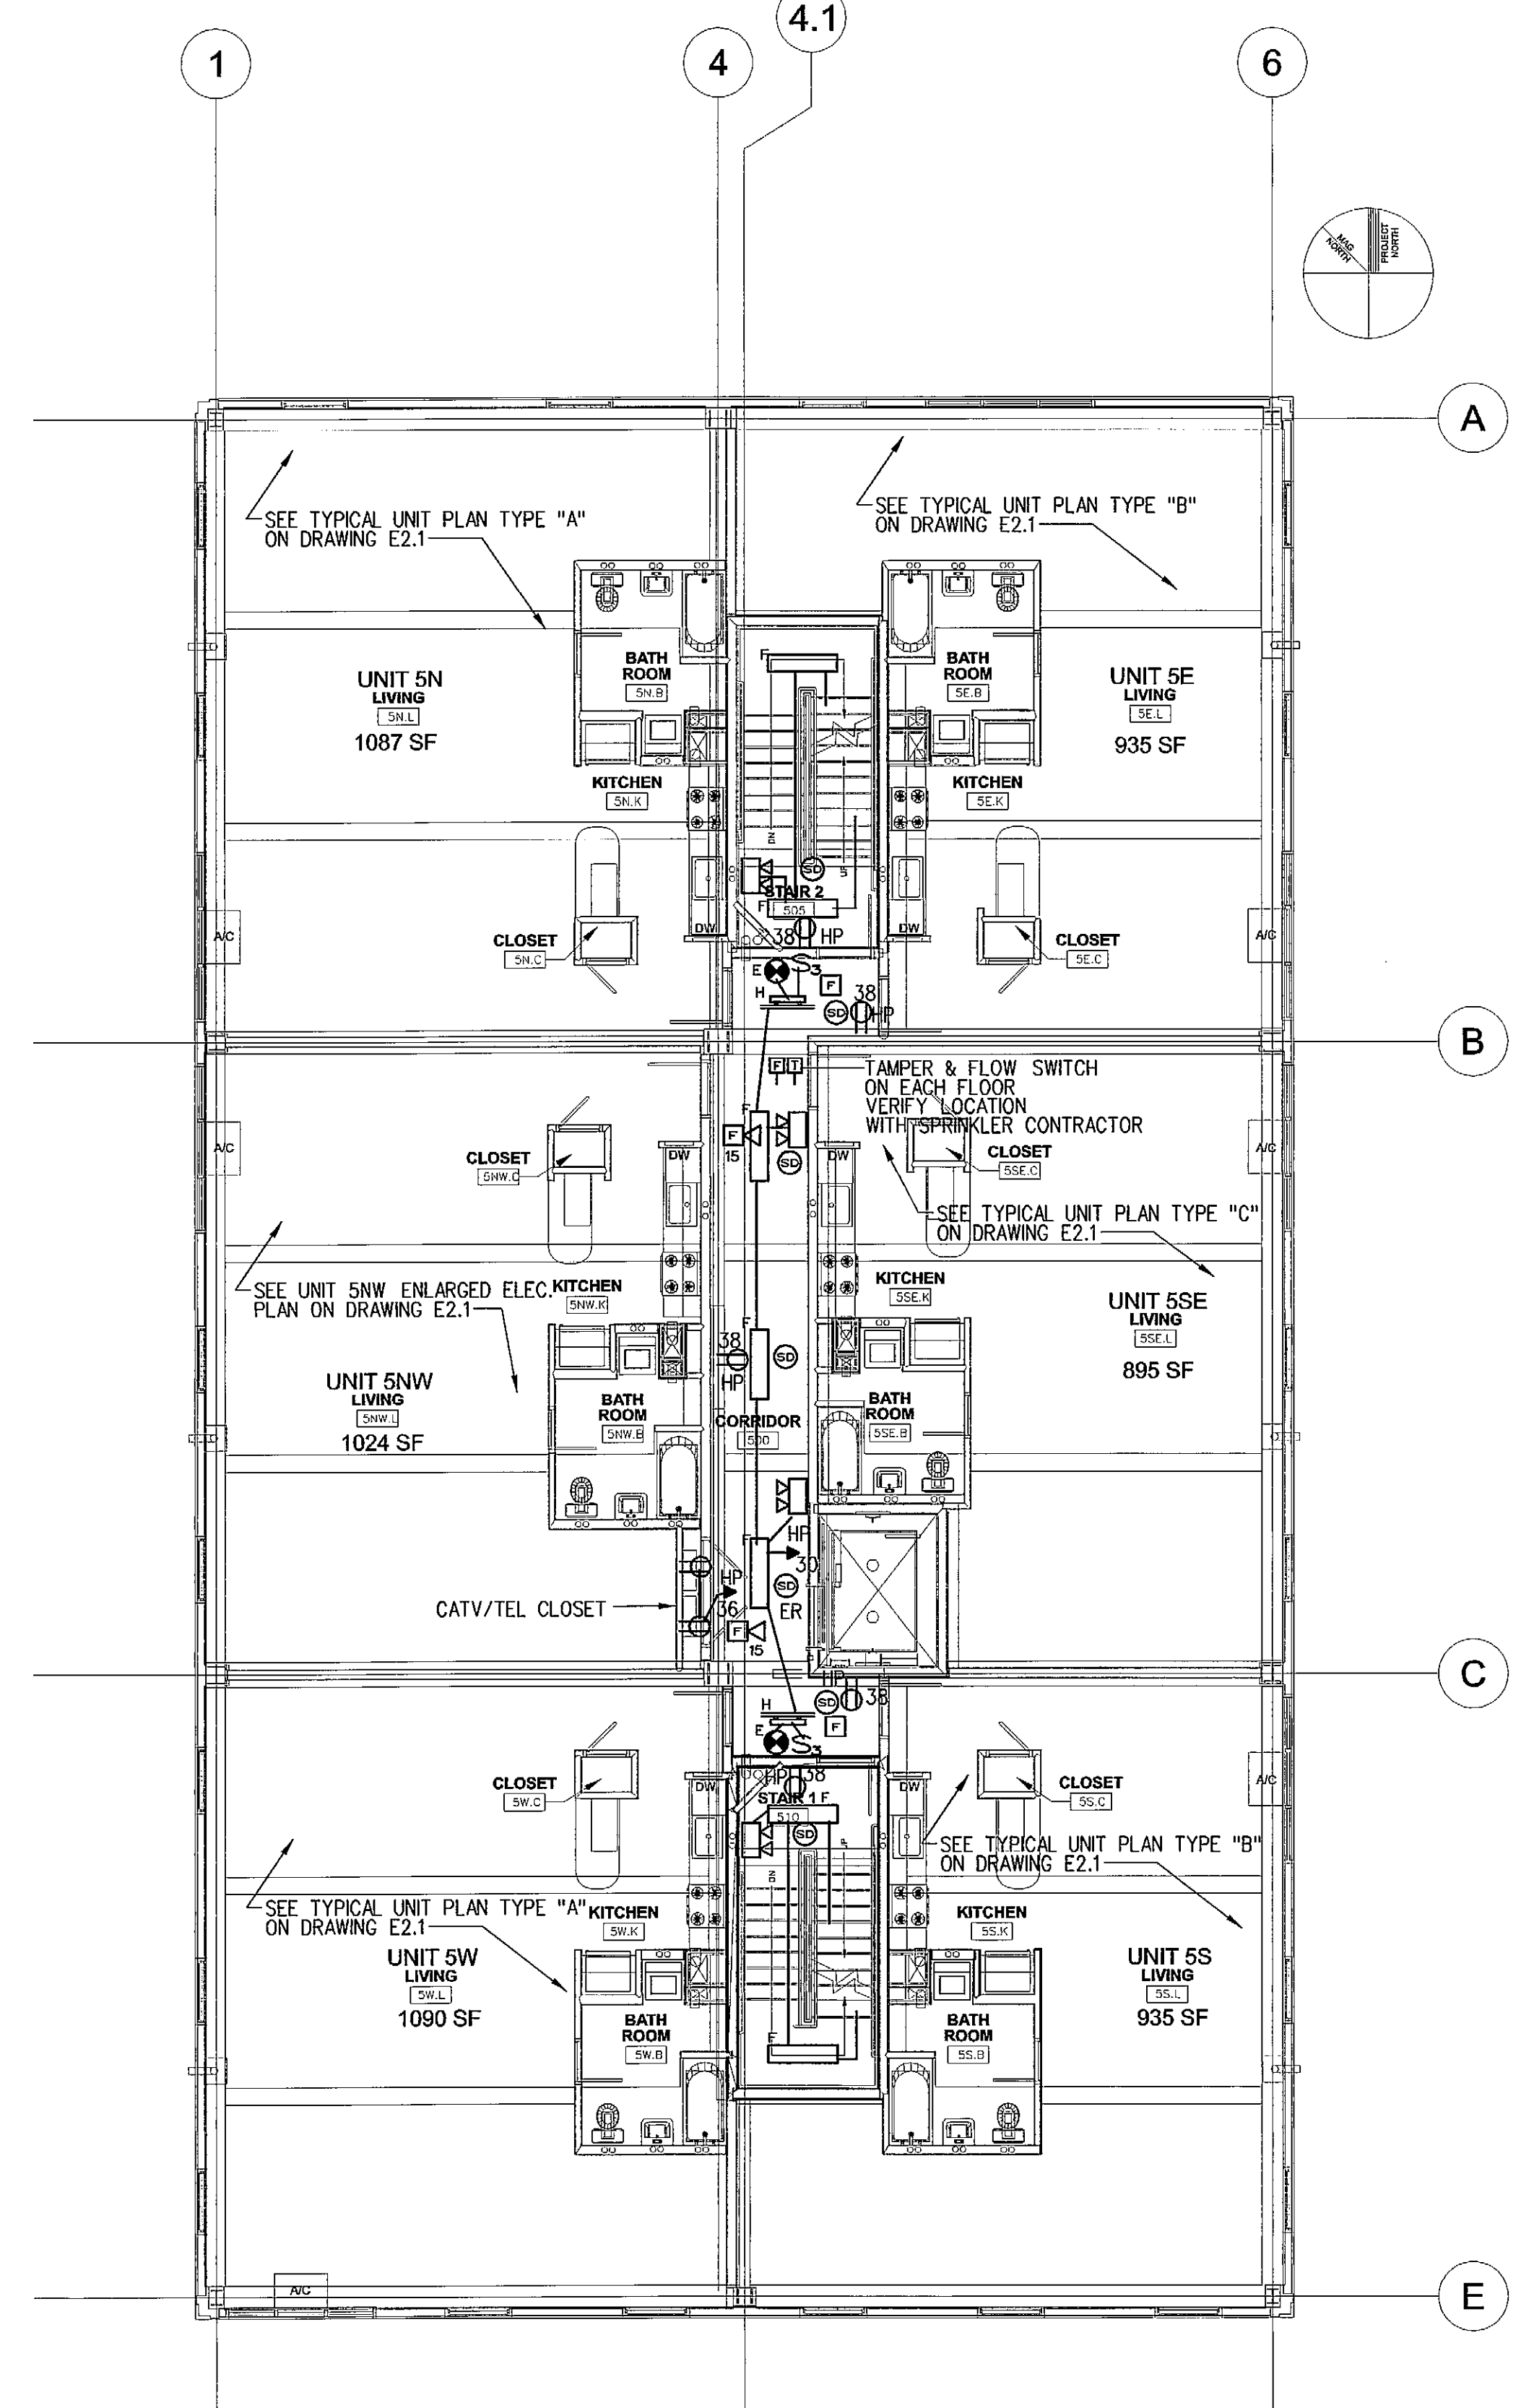

FIFTH FLOOR ELECTRICAL PLAN
SCALE: 1/8"=1'-0"