

© 2005 TFH ARCHITECTS

# CHESTNUT STREET LOFTS

URBAN REVITALIZATION PROJECT  
BY CHESTNUT STREET LLC.  
PORTLAND, MAINE



TFH ARCHITECTS  
100 COMMERCIAL STREET  
PORTLAND MAINE 04101  
TELEPHONE 207 775 6141  
ARCHITECTURE PLANNING

CONSULTANTS:  
**CIVIL:**  
Lara Use Consultants  
965 Riverside Street  
Portland, ME 04103  
207-678-3313  
**STRUCTURAL:**  
Structural Design Consulting  
22 Cabot Street  
Old Orchard Beach, ME 04064  
207-654-8030  
**MECHANICAL:**  
Whitney Engineering  
10 Dunforth Street  
Portland, ME 04101  
207-674-7449  
**ELECTRICAL:**  
Bennett Engineering  
7 Bennett Road  
Fresno, ME 04032  
207-655-8475

REVISIONS:  
JAN 2, 2006 BID SET  
FEB 9, 2006 PERMIT SET  
FEB 23, 2006  
CONSTRUCTION  
DOCUMENTS

DATE:

PROJECT No. 0422

DRAWN BY: WSBJR SPD



CHECKED BY: CWA WSBJR

SCALE: AS NOTED

SHEET TITLE:

ROOF  
ELECTRICAL  
PLANS

## E1.4

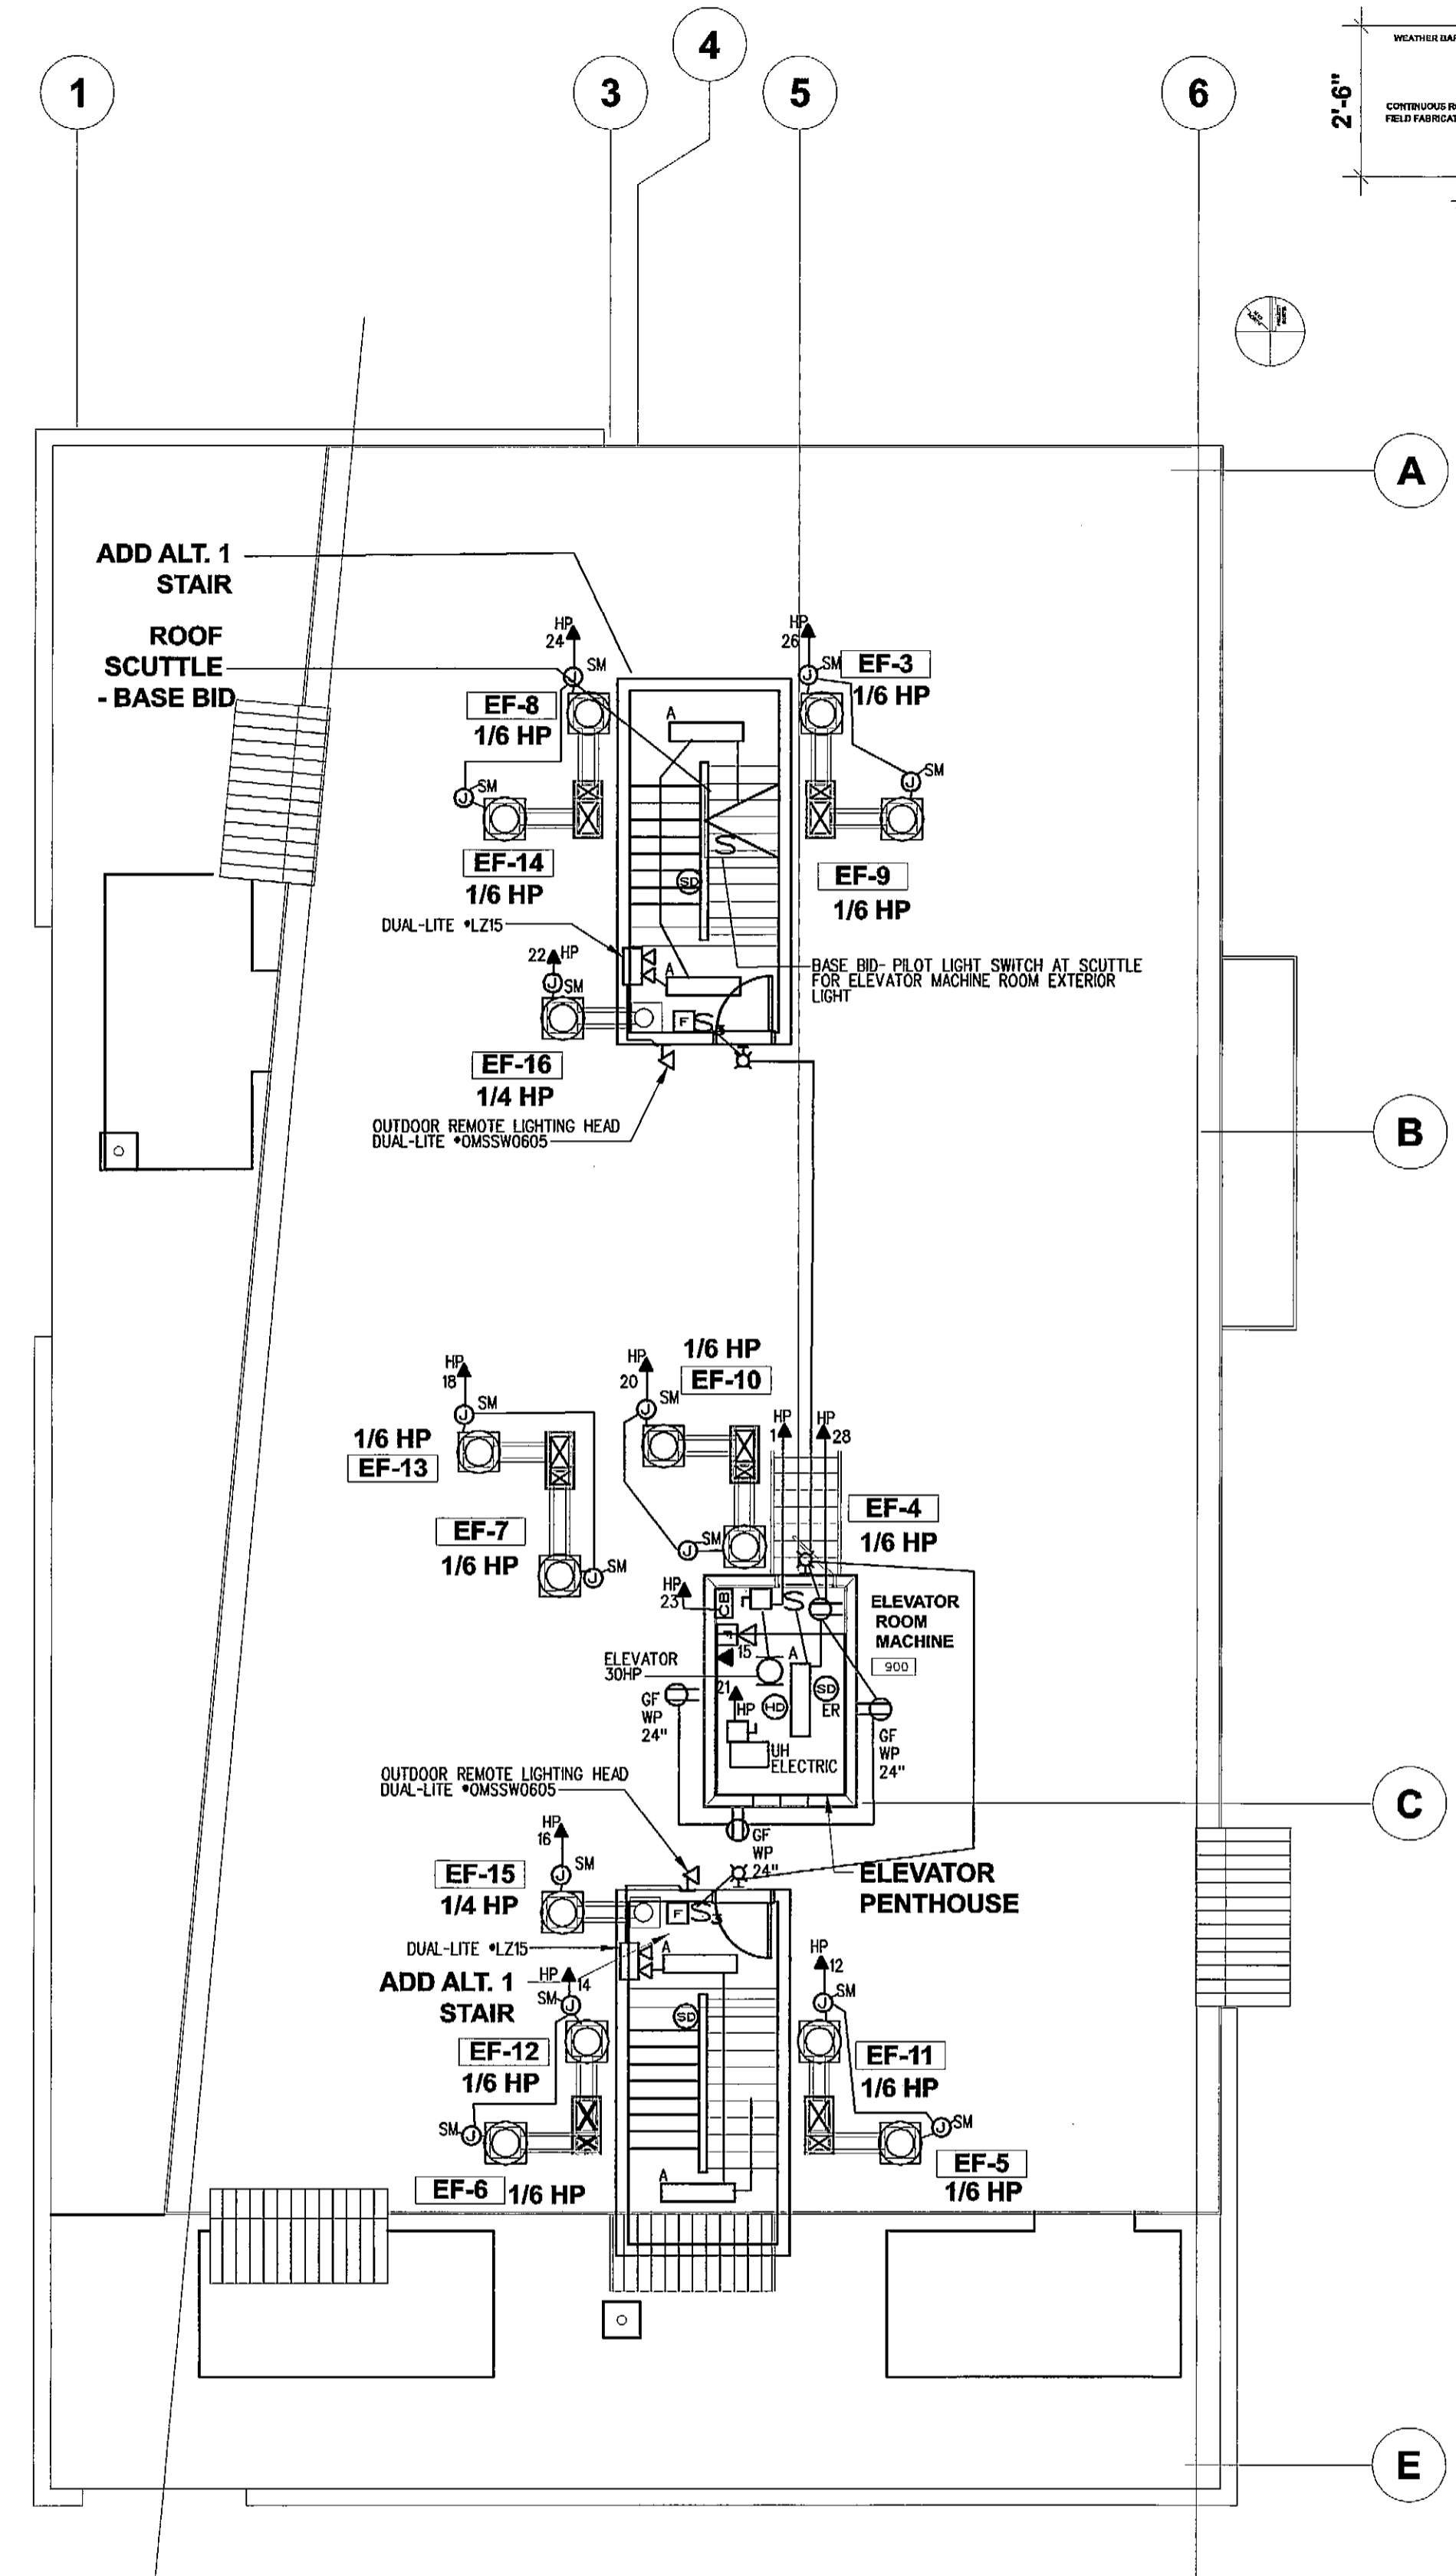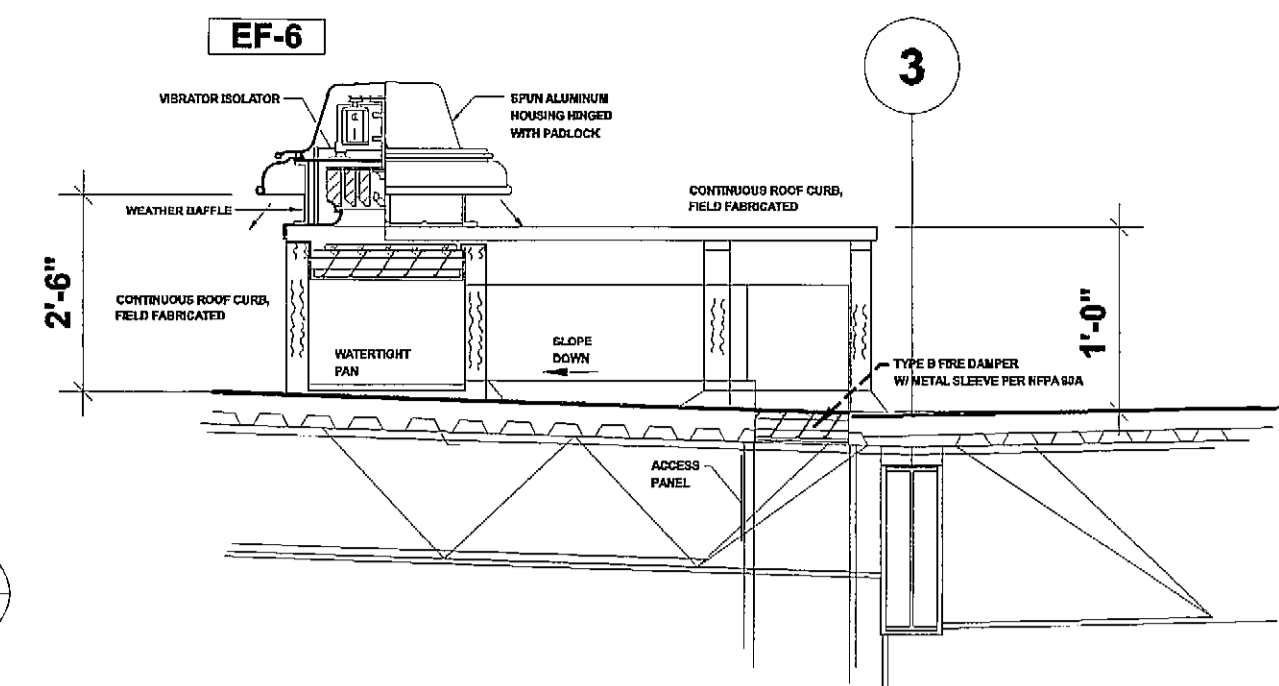

ADD ALT. 1  
STAIR  
ROOF  
SCUTTLE  
-BASE BID

EF-8  
1/6 HP

EF-14  
1/6 HP

EF-16  
1/4 HP

EF-3  
1/6 HP

EF-9  
1/6 HP

EF-13  
1/6 HP

EF-7  
1/6 HP

EF-4  
1/6 HP

EF-15  
1/4 HP

EF-12  
1/6 HP

EF-6  
1/6 HP

EF-11  
1/6 HP

EF-5  
1/6 HP

ADD ALTERNATE ONE (1)  
-(2) STAIRS TO ROOF WITH ENCLOSURE  
-ROOF TOP DECK

ROOF ELECTRICAL PLAN  
SCALE: 1/8"=1'-0"