



A1 BASEMENT LEVEL - LIGHTING
1/8"=1'-0"

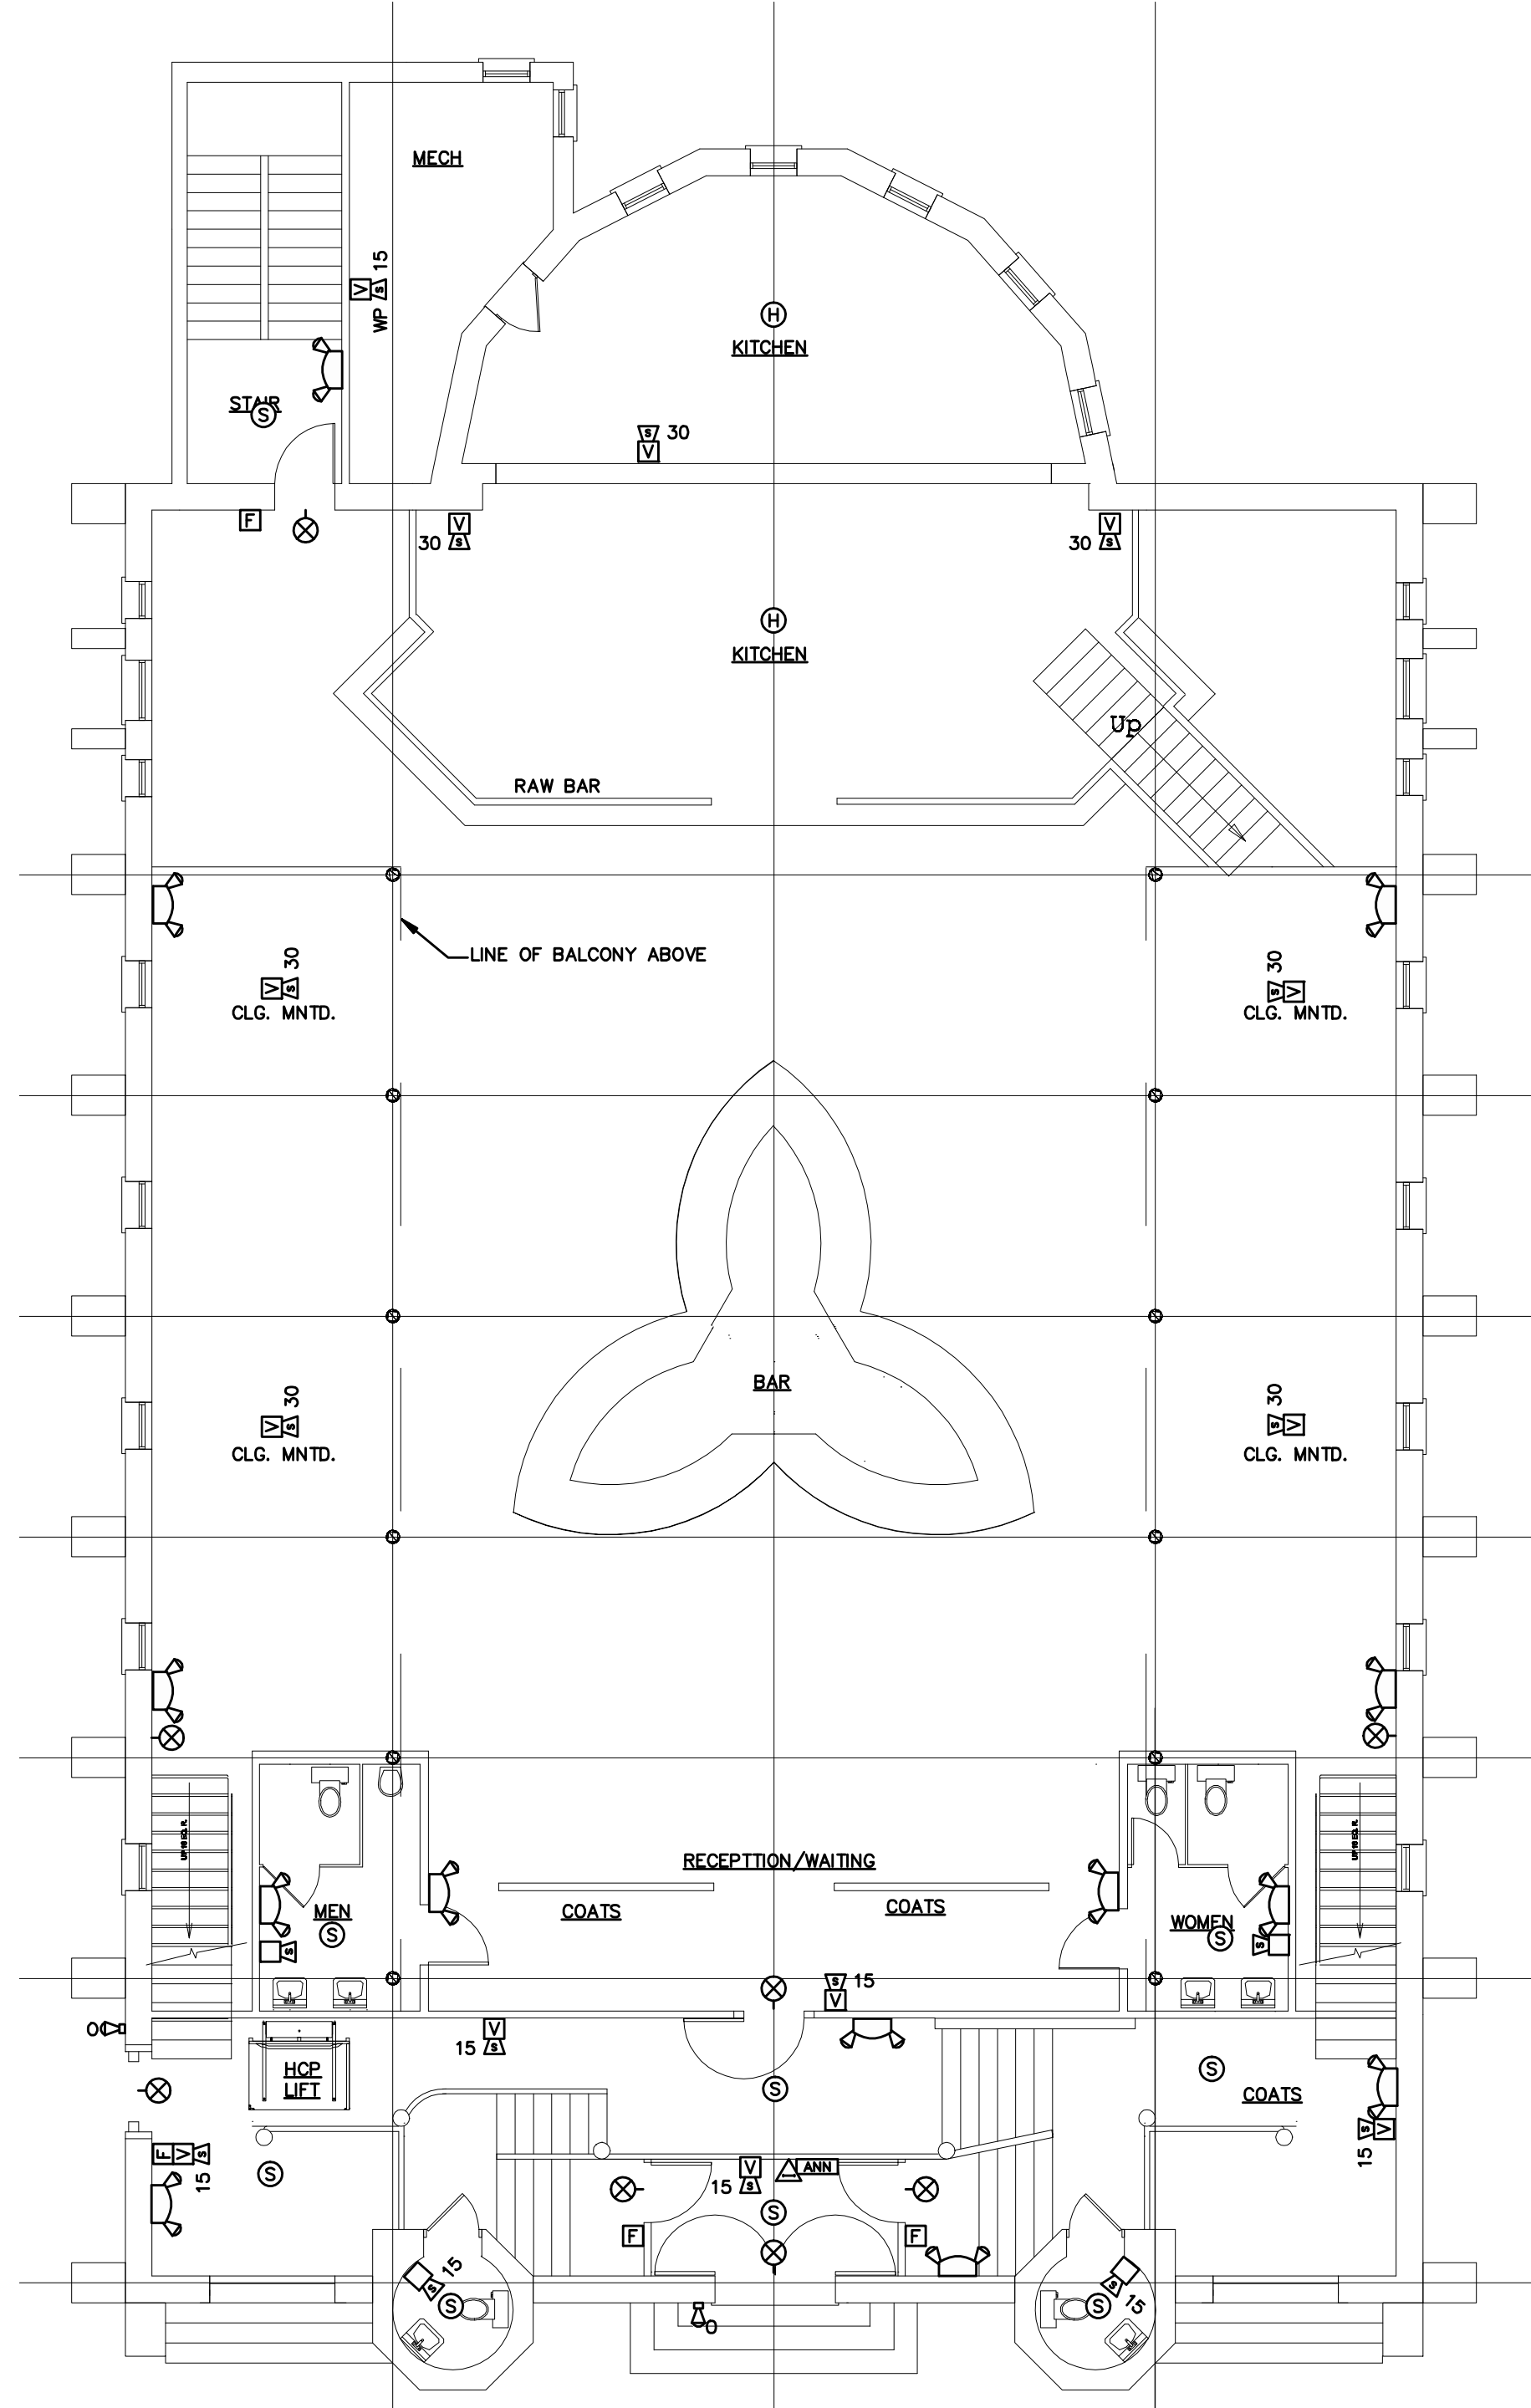

A6 FIRST FLOOR PLAN - LIGHTING
1/8"=1'-0"

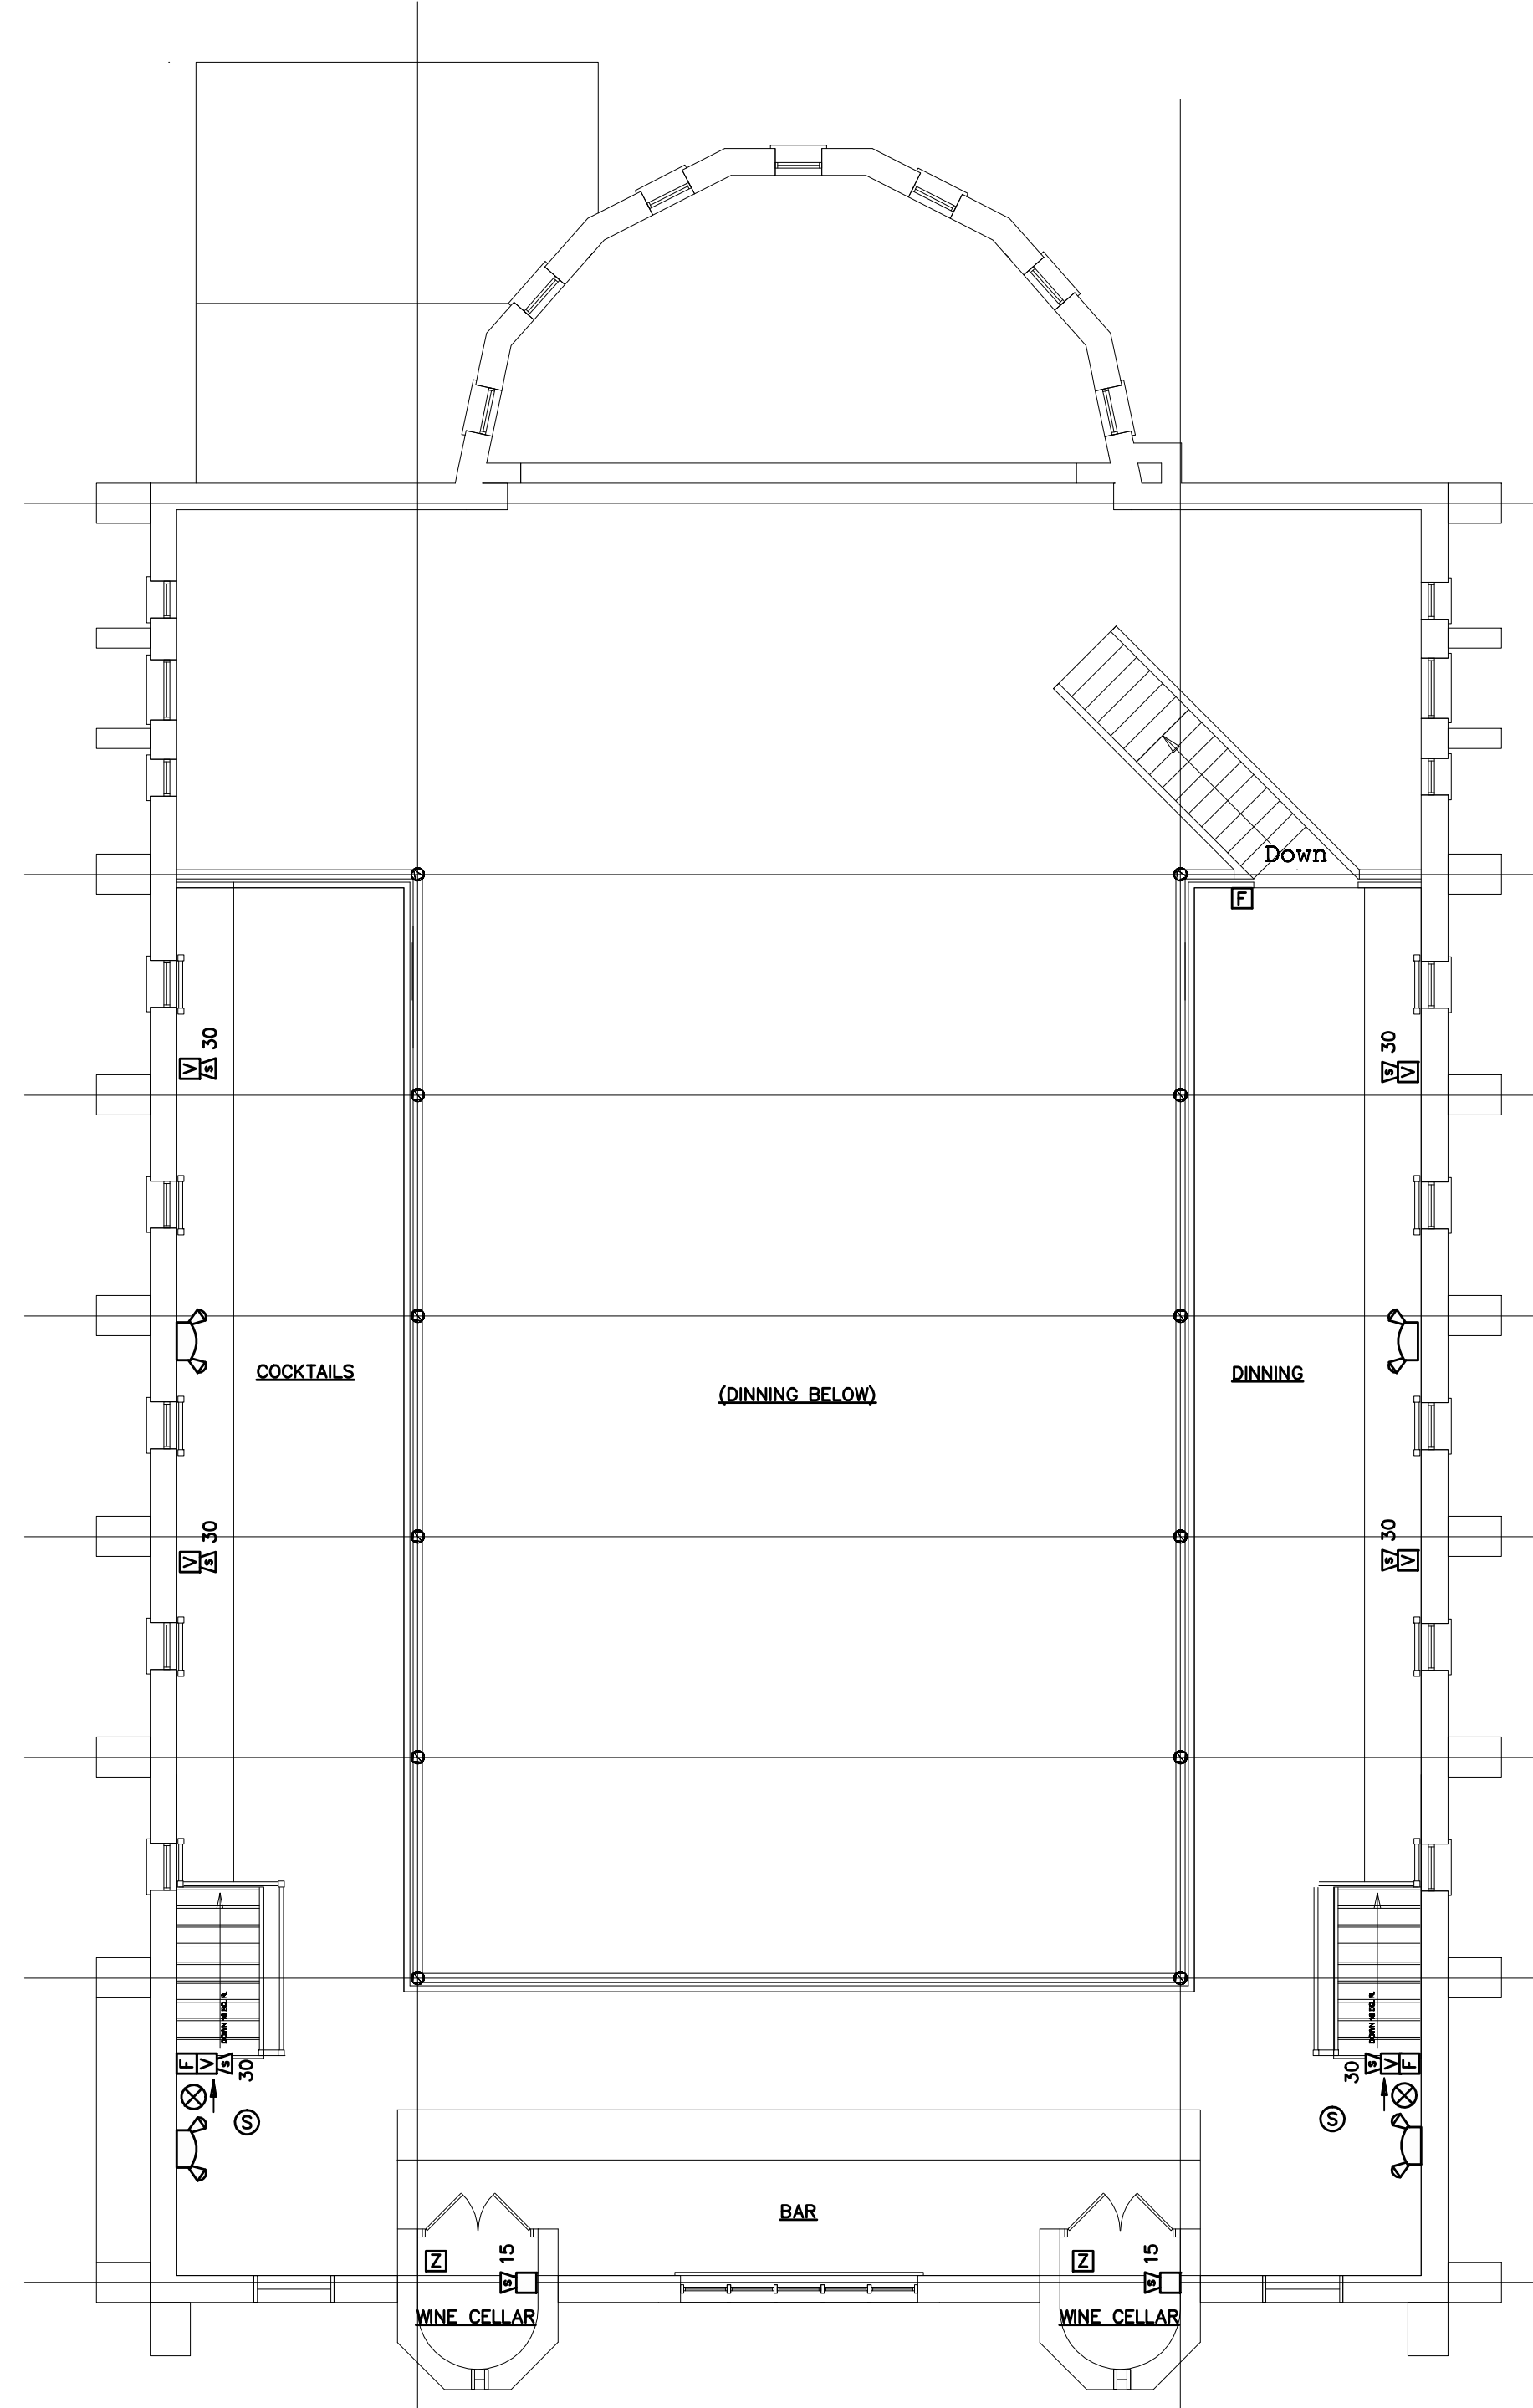

A11 BALCONY LEVEL AT SANCTUARY - LIGHTING
1/8"=1'-0"

NOTE: DRAWING MAY NOT HAVE BEEN PUBLISHED AT ORIGINAL SIZE. VERIFY DRAWING SCALE PRIOR TO USING THIS DOCUMENT.

NO.	DATE	REVISIONS	BY

Ames Hewett & Gifford
CONSULTING ENGINEERS & DESIGNERS
ELECTRICAL & MECHANICAL SYSTEMS
161 MAIN STREET WINTHROP, MAINE
Tel 207-377-6969 Fax 207-377-7584

PROJECT
GRACE CHESTNUT STREET CHURCH

SEAL
PROGRESS PRINT
NOT TO BE USED FOR CONSTRUCTION

DRAWING TITLE BASEMENT, 1ST FLOOR, BALCONY LEVEL EMERGENCY LIGHTING AND FIRE ALARM SYSTEM		GRAPHIC SCALE EL2.0
ENGINEER: TMG	APPROVED BY: —	
DRAWN BY: ARD	DATE: 06-25-08	
CHECKED BY: TMG	SCALE: —	
FILE: EL20-Ltg	JOB No: 08032	PLOT DATE: Aug 05, 2008
DRAWING NO.		

S:\A-20\08032\JAC\40\PLT\DEL20-Ltg.dwg