

**BASEMENT FLOOR PLAN**  
SCALE : 1/4" = 1'-0"

01	ISSUED FOR PERMITTING 08-08-08

AIRTEMP MECHANICAL CONTRACTORS  
11 WALLACE AVE.  
SOUTH PORTLAND, MAINE




28 MONUMENT SQUARE  
PORTLAND, MAINE

CLIENT  
DATE  
DRAWN BY  
CHECKED BY  
DATE AUG. 08, 2008  
SHEET TITLE  
BASEMENT MECHANICAL PLAN

SCALE  
N.T.S = 1'

DRAWING  
M-1

2 DX CURCUITS  
(2) 1/2" L (2) 1 1/8" S DN To 1st Floor

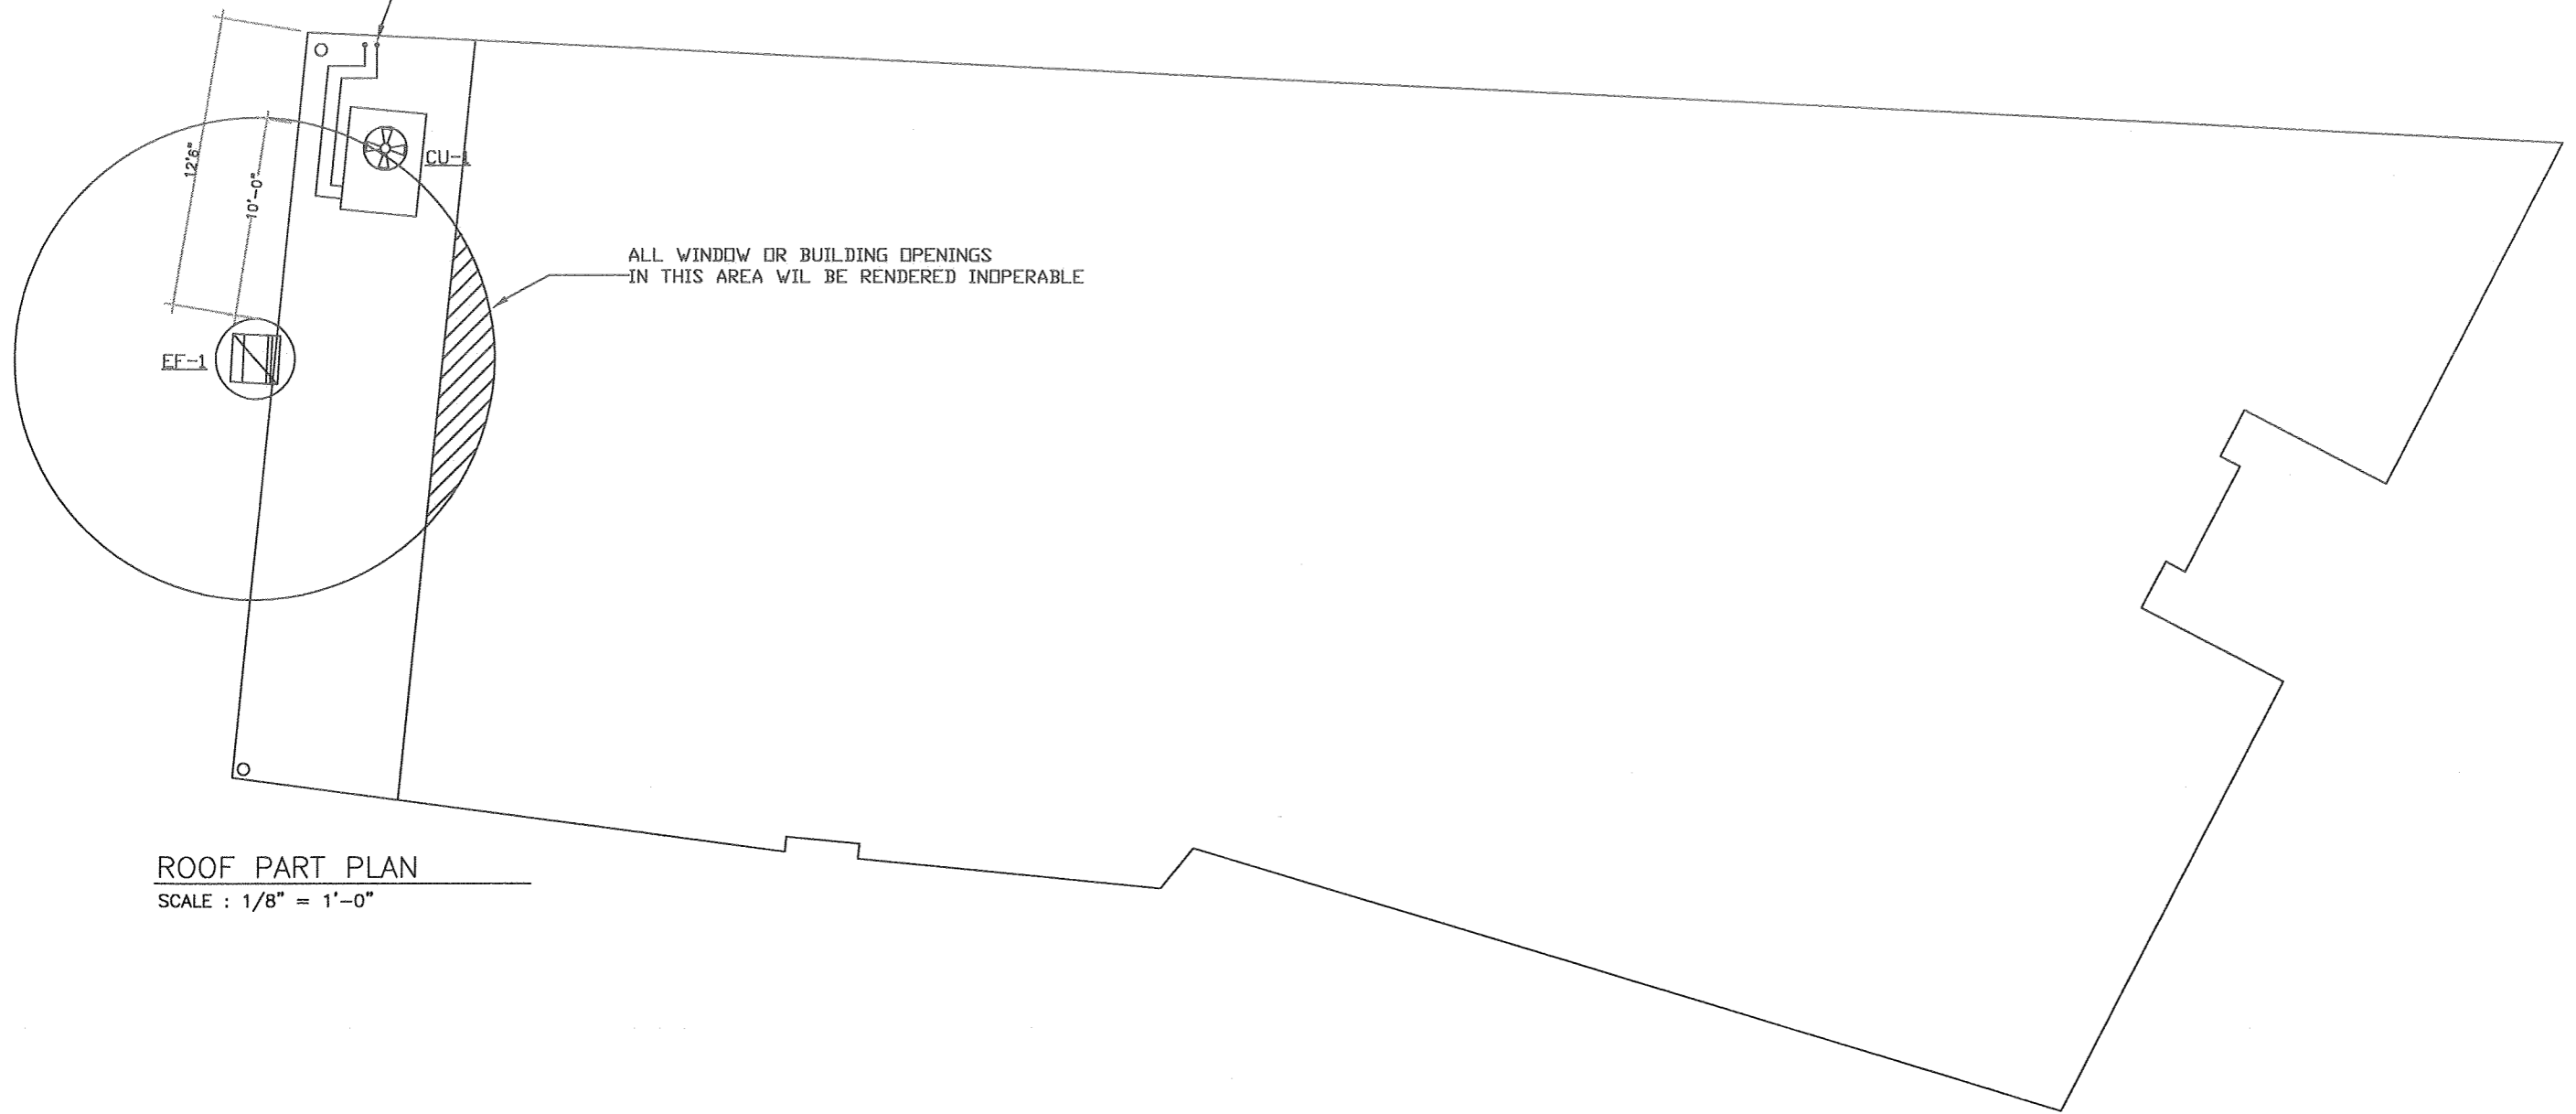

**ROOF PART PLAN**

SCALE : 1/8" = 1'-0"

01	ISSUED FOR PERMITTING 08-08-06

AIRTEMP MECHANICAL CONTRACTORS  
11 WALLACE AVE.  
SOUTH PORTLAND, MAINE



28 MONUMENT SQUARE  
PORTLAND, MAINE

CLIENT  
DATE  
DRAWN BY  
CHECKED BY  
DATE AUG. 08, 2006

SHEET TITLE  
ROOF PART PLAN

SCALE  
N.T.S

DRAWING  
M-3