

WALL LEGEND:

NEW WALL

EXISTING WALL TO REMAIN

CEILING LEGEND:

GWB ATTACHED TO HM STUD

SOUND ISOLATED GWB ATTACHED TO HM STUD. SEE DETAIL J8/AE510 FOR MORE INFO.

ACOUSTICAL CEILING SPRAY APPLIED TO STRUCTURAL DECK. SEE DETAIL A11/AE604.

NEW ACOUSTICAL TILE CEILING 2'-0" x 2'-0" ON METAL SUSPENSION GRID, APC-1 U.N.O.

ELECTRICAL SYMBOLS INDICATING LIGHTING LOCATIONS, SPEAKERS, FIRE ALARM EQUIPMENT, EXIT SIGNS AND OCCUPANCY SYMBOLS. REFER TO EL SHEETS FOR SIZE/TYPE OF FIXTURE

MECHANICAL SYMBOLS INDICATING SUPPLY DIFFUSER OR EXHAUST/RETURN GRILLE LOCATIONS. REFER TO MH SHEETS FOR SIZE/TYPE OF DIFFUSER/GRILLE.

APC-5 DESIGNATIONS:

1U = 1" UP TILE
 2U = 2" UP TILE
 3U = 3" UP TILE
 4U = 4" UP TILE

1D = 1" DOWN TILE
 2D = 2" DOWN TILE
 3D = 3" DOWN TILE
 4D = 4" DOWN TILE


KEYNOTES:

C1	NEW CEILING
C7	EXISTING CEILING TO REMAIN
C10	EXISTING CEILING TO REMAIN. REPAIR AND PATCH AS NEEDED.
C13	START FULL TILE HERE
C14	ALIGN SPECIALTY LIGHT FIXTURE IN GRID
C27	PAINT SOFFIT, PT10

GENERAL REMOVAL NOTES:

- REFER TO SHEET G1002 FOR ALL ABBREVIATIONS
- ALL HEIGHTS GIVEN ARE FROM FINISHED FLOOR OF BUILDING
- CONTRACTOR TO VERIFY LOCATION OF MAIN CEILING TEE'S BEFORE PROCEEDING WITH FIXTURE INSTALLATION. NOTIFY ARCHITECT OF INTERFERENCES
- NOTIFY ARCHITECT OF ANY DISCREPANCIES BETWEEN ARCHITECTURAL REFLECTED CEILING PLANS AND ELECTRICAL LIGHTING PLANS PRIOR TO CONSTRUCTION.
- REFER TO ELECTRICAL PLANS FOR LOCATION OF STROBES AND EXIT SIGNS.
- ALL CEILING GRILLES, TRIM EDGES, AND SLOT DIFFUSERS TO MATCH ADJACENT CEILING COLOR.
- ALL SPRINKLER HEADS TO OCCUR AT CENTER OF TILE.
- LAYOUT TILES AS SHOWN IN REFLECTED CEILING PLAN. CENTER TILES IN ROOM, UNO.
- ALL CEILINGS TO BE 8'-0" A.F.F. UNLESS NOTED OTHERWISE.
- SEE ELECTRICAL, MECHANICAL, AND PLUMBING SHEETS FOR ADDITIONAL INFORMATION.
- ALL RECESSED LIGHT FIXTURES IN ACOUSTIC PANEL CEILING GRID TO BE CENTERED IN THE TILE UNLESS NOTED OTHERWISE.
- ALL GYP CEILINGS AND SOFFITS, PT8, UNO.

REV.	DESCRIPTION	DATE
0	ISSUED FOR CONSTRUCTION	06 JUNE 2016

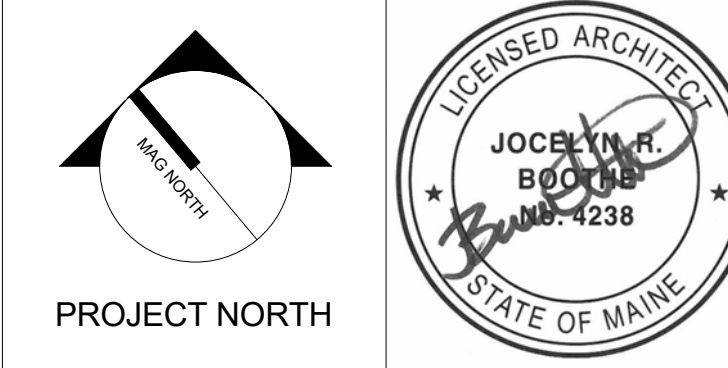


WBRC
 ARCHITECTS ENGINEERS
 WWW.WBRCAE.COM
 BANGOR, MAINE 207-947-4511
 PORTLAND, MAINE 207-528-4511
 SARASOTA, FLORIDA 941-556-0757

ASYLUM

PROJECT:
BASEMENT REFLECTED CEILING PLAN - SEGMENT A

SHEET TITLE:
 WBRC CAD FILE: C:\Users\jocelyn.booth\Documents\407110 - ASYLUM DANCE CLUB - ARCH - jocelyn.booth.rvt
 PROJECT No: 4071.10 GRAPHIC SCALE: 0" = 1"
 SCALE: As Indicated
 PROJECT MANAGER: JRB SHEET No: AE111A
 DRAWN BY: ARW
 CHECKED BY: JET/MEJ

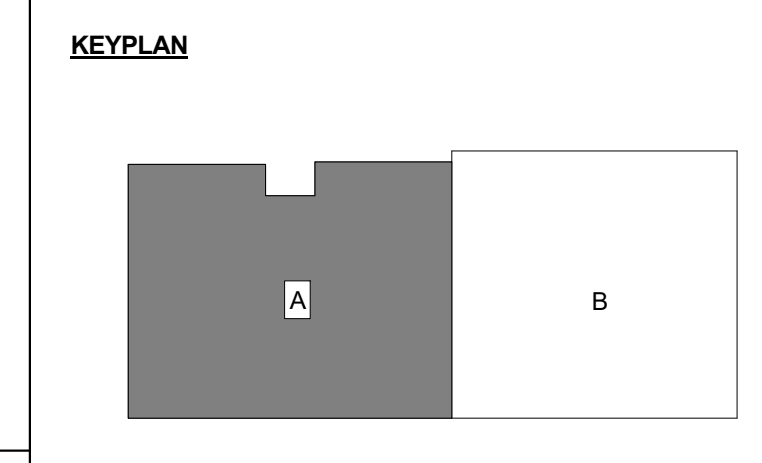

6/7/2016 8:27:40 AM C:\Users\jocelyn.booth\Documents\407110 - ASYLUM DANCE CLUB - ARCH - jocelyn.booth.rvt