

**WALL LEGEND:**

NEW WALL

EXISTING WALL TO REMAIN

**CEILING LEGEND**

GWB ATTACHED TO HM STUD

SOUND ISOLATED GWB ATTACHED TO HM STUD. SEE DETAIL J8/AE510 FOR MORE INFO.

ACOUSTICAL CEILING SPRAY APPLIED TO STRUCTURAL DECK. SEE DETAIL A11/AE604.

NEW ACOUSTICAL TILE CEILING 2'-0" x 2'-0" ON METAL SUSPENSION GRID, APC-1 U.N.O.

**ELECTRICAL SYMBOLS** INDICATING LIGHTING LOCATIONS, SPEAKERS, FIRE ALARM EQUIPMENT, EXIT SIGNS AND OCCUPANCY SYMBOLS. REFER TO EL SHEETS FOR SIZE/TYPE OF FIXTURE

LIGHTING

SPEAKER

FIRE ALARM

EXIT SIGN

OCCUPANCY

**MECHANICAL SYMBOLS** INDICATING SUPPLY DIFFUSER OR EXHAUST/ RETURN GRILLE LOCATIONS. REFER TO MH SHEETS FOR SIZE/TYPE OF DIFFUSER/ GRILLE.

SUPPLY DIFFUSER

EXHAUST/ RETURN GRILLE

**APC-5 DESIGNATIONS:**

1U = 1" UP TILE  
 2U = 2" UP TILE  
 3U = 3" UP TILE  
 4U = 4" UP TILE

1D = 1" DOWN TILE  
 2D = 2" DOWN TILE  
 3D = 3" DOWN TILE  
 4D = 4" DOWN TILE

**KEYNOTES:**

C12 CEILING HUNG TOILET PARTITIONS  
 C13 START FULL TILE HERE  
 C14 ALIGN SPECIALTY LIGHT FIXTURE IN GRID  
 C15 EXPOSED STRUCTURE ABOVE  
 C16 PAINT INSIDE OF WINDOW WELLS, PT13  
 C17 PAINT SOFFIT, PT9  
 C18 CEILING AND LIGHTS BY EQUIPMENT VENDOR  
 C23 18" X 18" CEILING ACCESS PANEL FOR PLUMBING VALVES

**GENERAL REMOVAL NOTES:**

1. REFER TO SHEET G1002 FOR ALL ABBREVIATIONS
2. ALL HEIGHTS GIVEN ARE FROM FINISHED FLOOR OF BUILDING
3. CONTRACTOR TO VERIFY LOCATION OF MAIN CEILING TEE'S BEFORE PROCEEDING WITH FIXTURE INSTALLATION. NOTIFY ARCHITECT OF INTERFERENCES
4. NOTIFY ARCHITECT OF ANY DISCREPANCIES BETWEEN ARCHITECTURAL REFLECTED CEILING PLANS AND ELECTRICAL LIGHTING PLANS PRIOR TO CONSTRUCTION.
5. REFER TO ELECTRICAL PLANS FOR LOCATION OF STROBES AND EXIT SIGNS.
6. ALL CEILING GRILLES, TRIM EDGES, AND SLOT DIFFUSERS TO MATCH ADJACENT CEILING COLOR.
7. ALL SPRINKLER HEADS TO OCCUR AT CENTER OF TILE
8. LAYOUT TILES AS SHOWN IN REFLECTED CEILING PLAN. CENTER TILES IN ROOM, UNO.
9. ALL CEILINGS TO BE 8'-0" A.F.F. UNLESS NOTED OTHERWISE.
10. SEE ELECTRICAL, MECHANICAL, AND PLUMBING SHEETS FOR ADDITIONAL INFORMATION.
11. ALL RECESSED LIGHT FIXTURES IN ACOUSTIC PANEL CEILING GRID TO BE CENTERED IN THE TILE UNLESS NOTED OTHERWISE.
12. ALL GYP CEILINGS AND SOFFITS, PT8, UNO.

REV.	DESCRIPTION	DATE
0	ISSUED FOR CONSTRUCTION	06 JUNE 2016




**WBRC**  
 ARCHITECTS ENGINEERS  
 WWW.WBRCAE.COM  
 BANGOR, MAINE 207-947-4511  
 PORTLAND, MAINE 207-428-4511  
 SARASOTA, FLORIDA 941-556-0757

**ASYLUM**

PROJECT:  
**BASEMENT REFLECTED CEILING PLAN - SEGMENT B**

SHEET TITLE:  
 WBRC CAD FILE: C:\Users\jbooth\Documents\407110 - ASYLUM DANCE CLUB - ARCH\_jbooth.rvt  
 PROJECT No: 4071.10 GRAPHIC SCALE: 0" = 1"  
 SCALE: As Indicated SHEET No: AE111B  
 PROJECT MANAGER: JRB  
 DRAWN BY: ARW  
 CHECKED BY: JET/MEJ

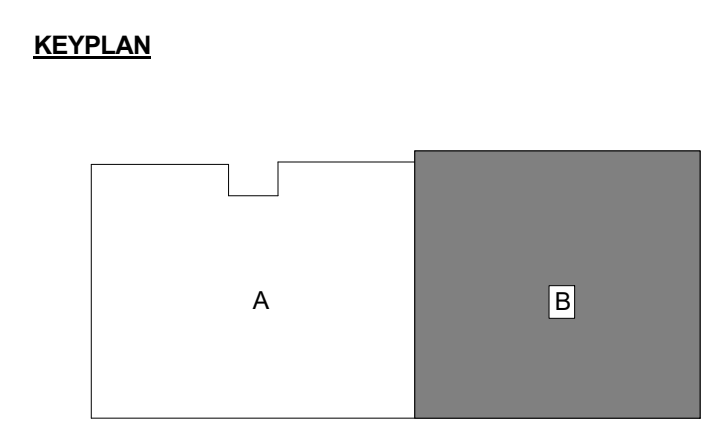

6/7/2016 8:28:06 AM C:\Users\jbooth\Documents\407110 - ASYLUM DANCE CLUB - ARCH\_jbooth.rvt