



**WALL LEGEND:**

NEW WALL	
EXISTING WALL TO REMAIN	

**CEILING LEGEND**

	GWB ATTACHED TO HM STUD
	SOUND ISOLATED GWB ATTACHED TO HM STUD. SEE DETAIL J8/AE510 FOR MORE INFO.
	ACOUSTICAL CEILING SPRAY APPLIED TO STRUCTURAL DECK. SEE DETAIL A11/AE604.
	NEW ACOUSTICAL TILE CEILING 2'-0" x 2'-0" ON METAL SUSPENSION GRID, APC-1 U.N.O.

**ELECTRICAL SYMBOLS**  
INDICATING LIGHTING LOCATIONS, SPEAKERS, FIRE ALARM EQUIPMENT, EXIT SIGNS AND OCCUPANCY SYMBOLS. REFER TO EL SHEETS FOR SIZE/TYPE OF FIXTURE

**MECHANICAL SYMBOLS**  
INDICATING SUPPLY DIFFUSER OR EXHAUST/ RETURN GRILLE LOCATIONS. REFER TO MH SHEETS FOR SIZE/TYPE OF DIFFUSER/ GRILLE.

**APC-5 DESIGNATIONS:**


1U = 1" UP TILE
2U = 2" UP TILE
3U = 3" UP TILE
4U = 4" UP TILE
1D = 1" DOWN TILE
2D = 2" DOWN TILE
3D = 3" DOWN TILE
4D = 4" DOWN TILE

**KEYNOTES:**

C1	NEW CEILING
C2	EXISTING CEILING TO REMAIN. REPLACE DAMAGED TILES AS NECESSARY
C4	REPLACE CEILING TILES, EXISTING GRID TO REMAIN
C5	EXISTING STAR CEILING TO REMAIN IN THIS AREA. SEE DEMO PLAN FOR DEMOLISHED PORTIONS OF STAR CEILING.
C10	EXISTING CEILING TO REMAIN. REPAIR AND PATCH AS NEEDED.
C11	EXISTING SKYLIGHT TO REMAIN. SEE STRUCTURAL DWGS
C13	START FULL TILE HERE
C17	PAINT SOFFIT, PT9
C18	CEILING AND LIGHTS BY EQUIPMENT VENDOR
C19	MAINTAIN FULL TILE OF FIBEROPTIC STAR CEILING. GYP SOFFIT TO ALIGN
C22	SURFACE MOUNT SALVAGED STAGE CURTAIN AND TRACK IN PLACE

**REV.**

REV.	DESCRIPTION	DATE
0	ISSUED FOR CONSTRUCTION	06 JUNE 2016

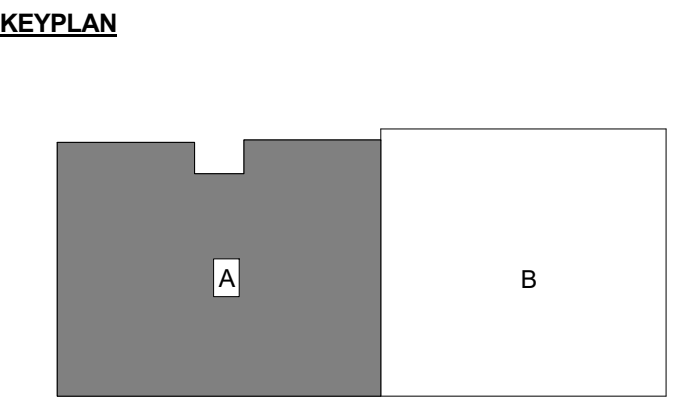

- GENERAL REMOVAL NOTES:**
1. REFER TO SHEET GI002 FOR ALL ABBREVIATIONS
  2. ALL HEIGHTS GIVEN ARE FROM FINISHED FLOOR OF BUILDING
  3. CONTRACTOR TO VERIFY LOCATION OF MAIN CEILING TEE'S BEFORE PROCEEDING WITH FIXTURE INSTALLATION. NOTIFY ARCHITECT OF INTERFERENCES
  4. NOTIFY ARCHITECT OF ANY DISCREPANCIES BETWEEN ARCHITECTURAL REFLECTED CEILING PLANS AND ELECTRICAL LIGHTING PLANS PRIOR TO CONSTRUCTION.
  5. REFER TO ELECTRICAL PLANS FOR LOCATION OF STROBES AND EXIT SIGNS.
  6. ALL CEILING GRILLES, TRIM EDGES, AND SLOT DIFFUSERS TO MATCH ADJACENT CEILING COLOR.
  7. ALL SPRINKLER HEADS TO OCCUR AT CENTER OF TILE.
  8. LAYOUT TILES AS SHOWN IN REFLECTED CEILING PLAN. CENTER TILES IN ROOM. UNO.
  9. ALL CEILINGS TO BE 8'-0" A.F.F. UNLESS NOTED OTHERWISE.
  10. SEE ELECTRICAL, MECHANICAL, AND PLUMBING SHEETS FOR ADDITIONAL INFORMATION.
  11. ALL RECESSED LIGHT FIXTURES IN ACOUSTIC PANEL CEILING GRID TO BE CENTERED IN THE TILE UNLESS NOTED OTHERWISE.
  12. ALL GYP CEILINGS AND SOFFITS, PT8, UNO.



**WBRC**  
ARCHITECTS ENGINEERS  
WWW.WBRCAE.COM  
BANGOR, MAINE 207-947-4511  
PORTLAND, MAINE 207-528-4511  
SARASOTA, FLORIDA 941-556-0757

**ASYLUM**  
PROJECT:  
**FIRST FLOOR REFLECTED CEILING PLAN - SEGMENT A**

SHEET TITLE:  
WBRC CAD FILE: C:\Users\jbooth\Documents\407110 - ASYLUM DANCE CLUB - ARCH - JOCELYN BOOTH.rvt  
PROJECT No: 4071.10 GRAPHIC SCALE: 0" = 1"  
SCALE: As Indicated  
PROJECT MANAGER: JRB SHEET No:  
DRAWN BY: ARW  
CHECKED BY: JET/MEJ  
**AE112A**

6/17/2016 8:28:27 AM C:\Users\jbooth\Documents\407110 - ASYLUM DANCE CLUB - ARCH - JOCELYN BOOTH.rvt