

WALL LEGEND:

NEW WALL

EXISTING WALL TO REMAIN

CEILING LEGEND

GWB ATTACHED TO HM STUD

SOUND ISOLATED GWB ATTACHED TO HM STUD. SEE DETAIL J8/AE510 FOR MORE INFO.

ACOUSTICAL CEILING SPRAY APPLIED TO STRUCTURAL DECK. SEE DETAIL A11/AE604.

NEW ACOUSTICAL TILE CEILING 2'-0" x 2'-0" ON METAL SUSPENSION GRID, APC-1 U.N.O.

ELECTRICAL SYMBOLS INDICATING LIGHTING LOCATIONS, SPEAKERS, FIRE ALARM EQUIPMENT, EXIT SIGNS AND OCCUPANCY SYMBOLS. REFER TO EL SHEETS FOR SIZE/TYPE OF FIXTURE

MECHANICAL SYMBOLS INDICATING SUPPLY DIFFUSER OR EXHAUST/ RETURN GRILLE LOCATIONS. REFER TO MH SHEETS FOR SIZE/TYPE OF DIFFUSER/ GRILLE.

APC-5 DESIGNATIONS:

1U = 1" UP TILE
 2U = 2" UP TILE
 3U = 3" UP TILE
 4U = 4" UP TILE

1D = 1" DOWN TILE
 2D = 2" DOWN TILE
 3D = 3" DOWN TILE
 4D = 4" DOWN TILE

KEYNOTES:

C24 PAINT SOFFIT, PT8

- GENERAL REMOVAL NOTES:**
- REFER TO SHEET G1002 FOR ALL ABBREVIATIONS
 - ALL HEIGHTS GIVEN ARE FROM FINISHED FLOOR OF BUILDING
 - CONTRACTOR TO VERIFY LOCATION OF MAIN CEILING TEES BEFORE PROCEEDING WITH FIXTURE INSTALLATION. NOTIFY ARCHITECT OF INTERFERENCES
 - NOTIFY ARCHITECT OF ANY DISCREPANCIES BETWEEN ARCHITECTURAL REFLECTED CEILING PLANS AND ELECTRICAL LIGHTING PLANS PRIOR TO CONSTRUCTION.
 - REFER TO ELECTRICAL PLANS FOR LOCATION OF STROBES AND EXIT SIGNS.
 - ALL CEILING GRILLES, TRIM EDGES, AND SLOT DIFFUSERS TO MATCH ADJACENT CEILING COLOR.
 - ALL SPRINKLER HEADS TO OCCUR AT CENTER OF TILE. CENTER TILES IN ROOM, UNO.
 - LAYOUT TILES AS SHOWN IN REFLECTED CEILING PLAN. CENTER TILES IN ROOM, UNO.
 - ALL CEILINGS TO BE 8'-0" A.F.F. UNLESS NOTED OTHERWISE.
 - SEE ELECTRICAL, MECHANICAL, AND PLUMBING SHEETS FOR ADDITIONAL INFORMATION.
 - ALL RECESSED LIGHT FIXTURES IN ACOUSTIC PANEL CEILING GRID TO BE CENTERED IN THE TILE UNLESS NOTED OTHERWISE.
 - ALL GYP CEILINGS AND SOFFITS, PT8, UNO.

REV.	DESCRIPTION	DATE
0	ISSUED FOR CONSTRUCTION	06 JUNE 2016


PROJECT NORTH

WBRC
 ARCHITECTS ENGINEERS

WWW.WBRCAE.COM
 BANGOR, MAINE 207-947-4511
 PORTLAND, MAINE 207-528-4511
 SARASOTA, FLORIDA 941-556-0757

ASYLUM

PROJECT:
LOWER BALCONY REFLECTED CEILING PLAN - SEGMENT B

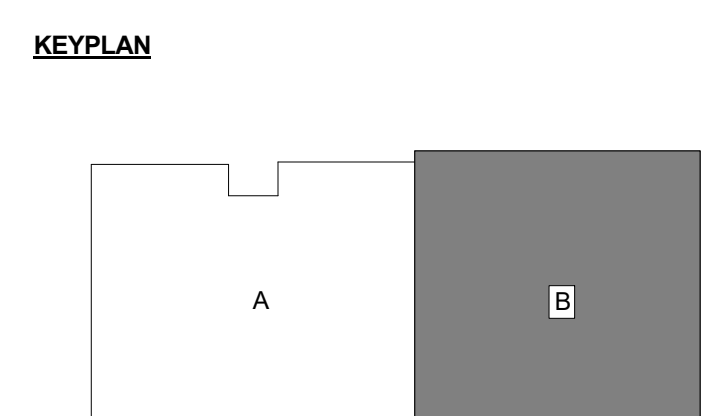

SHEET TITLE:
AE113B

WBRC CAD FILE: C:\Users\jocelyn.booth\Documents\407110 - ASYLUM DANCE CLUB - ARCH - jocelyn.booth.rvt

PROJECT No: 4071.10 GRAPHIC SCALE: 0" = 1"

SCALE: As Indicated

PROJECT MANAGER: JRB SHEET No.

DRAWN BY: ARW

CHECKED BY: JET/MEJ

6/7/2016 8:29:06 AM C:\Users\jocelyn.booth\Documents\407110 - ASYLUM DANCE CLUB - ARCH - jocelyn.booth.rvt