

**WALL LEGEND:**

NEW WALL

EXISTING WALL TO REMAIN

**CEILING LEGEND**

GWP ATTACHED TO HM STUD

SOUND ISOLATED GWP ATTACHED TO HM STUD. SEE DETAIL J8/AE510 FOR MORE INFO.

ACoustICAL CEILING SPRAY APPLIED TO STRUCTURAL DECK. SEE DETAIL A11/AE604.

NEW ACoustICAL TILE CEILING 2'-0" x 2'-0" ON METAL SUSPENSION GRID, APC-1 U.N.O.

ELECTRICAL SYMBOLS INDICATING LIGHTING LOCATIONS. SPEAKERS, FIRE ALARM EQUIPMENT, EXIT SIGNS AND OCCUPANCY SYMBOLS. REFER TO EL SHEETS FOR SIZE/TYPE OF FIXTURE

MECHANICAL SYMBOLS INDICATING SUPPLY DIFFUSER OR EXHAUST/ RETURN GRILLE LOCATIONS. REFER TO MH SHEETS FOR SIZE/ TYPE OF DIFFUSER/ GRILLE.

**APC-5 DESIGNATIONS:**


1U = 1" UP TILE  
 2U = 2" UP TILE  
 3U = 3" UP TILE  
 4U = 4" UP TILE

1D = 1" DOWN TILE  
 2D = 2" DOWN TILE  
 3D = 3" DOWN TILE  
 4D = 4" DOWN TILE

**KEYNOTES:**

C13	START FULL TILE HERE
C21	1-HR RATED GYP CEILING
C24	PAINT SOFFIT, PT8
C25	PAINT SOFFIT, PT1

- GENERAL REMOVAL NOTES:**
- REFER TO SHEET G1002 FOR ALL ABBREVIATIONS
  - ALL HEIGHTS GIVEN ARE FROM FINISHED FLOOR OF BUILDING
  - CONTRACTOR TO VERIFY LOCATION OF MAIN CEILING TEE'S BEFORE PROCEEDING WITH FIXTURE INSTALLATION. NOTIFY ARCHITECT OF INTERFERENCES
  - NOTIFY ARCHITECT OF ANY DISCREPANCIES BETWEEN ARCHITECTURAL REFLECTED CEILING PLANS AND ELECTRICAL LIGHTING PLANS PRIOR TO CONSTRUCTION.
  - REFER TO ELECTRICAL PLANS FOR LOCATION OF STROBES AND EXIT SIGNS.
  - ALL CEILING GRILLES, TRIM EDGES, AND SLOT DIFFUSERS TO MATCH ADJACENT CEILING COLOR.
  - ALL SPRINKLER HEADS TO OCCUR AT CENTER OF TILE.
  - LAYOUT TILES AS SHOWN IN REFLECTED CEILING PLAN. CENTER TILES IN ROOM, UNO.
  - ALL CEILINGS TO BE 8'-0" A.F.F. UNLESS NOTED OTHERWISE.
  - SEE ELECTRICAL, MECHANICAL, AND PLUMBING SHEETS FOR ADDITIONAL INFORMATION.
  - ALL RECESSED LIGHT FIXTURES IN ACoustICAL PANEL CEILING GRID TO BE CENTERED IN THE TILE UNLESS NOTED OTHERWISE.
  - ALL GYP CEILINGS AND SOFFITS, PT8, UNO.

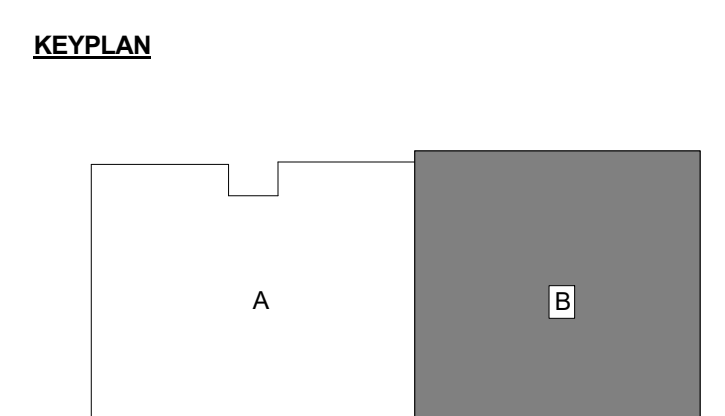

0	ISSUED FOR CONSTRUCTION	06 JUNE 2016
REV.	DESCRIPTION	DATE



**WBRC**  
 ARCHITECTS ENGINEERS  
 WWW.WBRCAE.COM  
 BANGOR, MAINE 207-947-4511  
 PORTLAND, MAINE 207-528-4511  
 SARASOTA, FLORIDA 941-556-0757

**ASYLUM**

PROJECT:  
**BALCONY REFLECTED CEILING PLAN - SEGMENT B**

SHEET TITLE:  
 WBRC CAD FILE: C:\Users\jocelyn.booth\Documents\407110 - ASYLUM DANCE CLUB - ARCH - jocelyn.booth.rvt

PROJECT No: 4071.10	GRAPHIC SCALE: 0" = 1"
SCALE: As Indicated	SHEET No: AE114B
PROJECT MANAGER: JRB	CHECKED BY: JET/MEJ
DRAWN BY: ARW	

A1 UPPER BALCONY  
 1/4" = 1'-0"

6/7/2016 8:29:26 AM C:\Users\jocelyn.booth\Documents\407110 - ASYLUM DANCE CLUB - ARCH - jocelyn.booth.rvt