


- TECHNICAL NOTES:**
- 1 LIGHTING CONTROL SYSTEM TOUCHSCREEN - PROVIDE CAT. 5 TO DMX CONTROLLER IN ELECT. 009. REFER TO DETAIL A7/E-502 FOR LIGHTING CONTROL SYSTEM RISER.
 - 2 NOT USED.
 - 3 EMERGENCY LIGHTING UL924 SWITCHING RELAY - RELAY SHALL BE EQUAL TO LVS, CAT. NO. EPC-A-1/ REFER TO DETAIL A7/E-502 FOR ADDITIONAL WIRING INFORMATION.
 - 4 0-10V LOW VOLTAGE DIMMER EQUAL TO PHILIPS, CAT. NO. SR1200ZTUNV. ENSURE COMPATIBILITY WITH DRIVER. DIMMER SHALL BE CONNECTED TO TYPE L FIXTURE
 - 5 ELECTRONIC LOW VOLTAGE DIMMER EQUAL TO LEGRAND, CAT. NO. ADTP793TU. CONNECT TO TYPE K FIXTURE.
 - 6 OCCUPANCY SENSOR CONNECTED TO LIGHTING CONTROL SYSTEM. LOW VOLTAGE WIRING NOT SHOWN FOR CLARITY. REFER TO DETAIL A7/E-502 FOR ADDITIONAL CONNECTION INFORMATION.
 - 7 RECESSED AT TOP OF WINDOW BOX OUT - REFER TO REFLECTED CEILING PLANS FOR MORE INFORMATION.
 - 8 JUNCTION BOX FOR WALK-IN LIGHTS - LIGHTS AND SWITCH PROVIDED BY FOOD SERVICE VENDOR. ALL WIRING ASSOCIATED WITH WALK-IN BY DIV. 26.

REV.	DESCRIPTION	DATE
0	ISSUED FOR BID	06 JUNE 2016

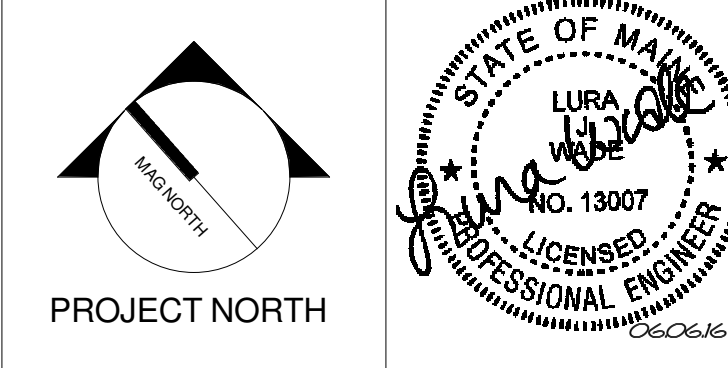


WBRC
ARCHITECTS ENGINEERS
WWW.WBRCAE.COM
BANGOR, MAINE 207-947-4511
PORTLAND, MAINE 207-628-4511
SARASOTA, FLORIDA 941-556-0757

PROJECT:
ASYLUM

SHEET TITLE:
BASEMENT LIGHTING PLAN - SEGMENT B

WBRC CAD FILE: C:\Users\laura.mahar\Documents\407110 - ASYLUM DANCE CLUB - ELEC. lyle.mahar.rvt	GRAPHIC SCALE: 0" = 1"
PROJECT No 4071.10	SHEET No.
SCALE: 1/4" = 1'-0"	EL101B
PROJECT MANAGER JRB	CHECKED BY: LW
DRAWN BY: KRM	

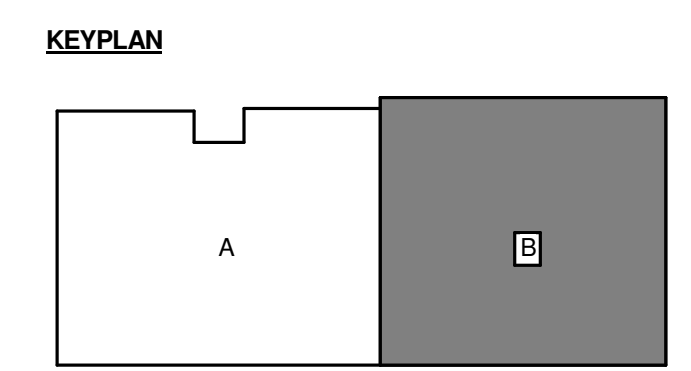

6/3/2016 4:04:08 PM
 C:\Users\laura.mahar\Documents\407110 - ASYLUM DANCE CLUB - ELEC. lyle.mahar.rvt

A1 BASEMENT LIGHTING PLAN - SEGMENT B
1/4" = 1'-0"