

TECHNICAL NOTES:

- 1 LIGHTING CONTROL SYSTEM TOUCHSCREEN - PROVIDE CAT. 5 TO DMX CONTROLLER IN ELEC. 009. REFER TO DETAIL A7/E-502 FOR LIGHTING CONTROL SYSTEM RISER.
- 2 DECORATIVE CEMENT COUNTERTOP WITH INTEGRAL LED LIGHTING - COUNTER, POWER SUPPLY AND CONTROLLER BY DIV. 12. ALL POWER AND CONTROLS CONNECTIONS BY DIV. 26.
- 3 EMERGENCY LIGHTING UL924 SWITCHING RELAY - RELAY SHALL BE EQUAL TO LVS. CAT. NO. EPC-A-1/ REFER TO DETAIL A7/E-502 FOR ADDITIONAL WIRING INFORMATION.
- 4 STAIR TREAD LIGHTING TRANSFORMER - WALL MOUNT ABOVE ACCESSIBLE CEILING. TRANSFORMER SHALL BE CALL LIGHTING. CAT. NO. TR1150-120V-12V. LOW VOLTAGE WIRING TO TREADS SHALL BE CONCEALED WITHIN WALL.
- 5 LIGHTING CONTROL SYSTEM SWITCHING CEILING. REFER TO LIGHTING CONTROL SCHEDULES FOR MORE INFORMATION.
- 6 OCCUPANCY SENSOR CONNECTED TO LIGHTING CONTROL SYSTEM. LOW VOLTAGE WIRING NOT SHOWN FOR CLARITY. REFER TO DETAIL A7/E-502 FOR ADDITIONAL CONNECTION INFORMATION.
- 7 JUNCTION BOX FOR BUILDING SIGNAGE - COORDINATE REQUIREMENTS WITH OWNER'S VENDOR. SIGNAGE PROVIDED BY OWNER'S VENDOR. POWER AND CONTROL CONNECTIONS BY DIV. 26.

REV.	DESCRIPTION	DATE
0	ISSUED FOR BID	06 JUNE 2016

PROJECT NORTH


WBRC
ARCHITECTS ENGINEERS

WWW.WBRCAE.COM
BANGOR, MAINE 207-947-4511
PORTLAND, MAINE 207-828-4511
SARASOTA, FLORIDA 941-556-0757

PROJECT:
ASYLUM

UPPER BALCONY LIGHTING PLAN

SHEET TITLE:	
PROJECT No: 4071.10	GRAPHIC SCALE: 0" = 1"
SCALE: 1/4" = 1'-0"	SHEET No:
PROJECT MANAGER: JRB	
DRAWN BY: KRM	EL104
CHECKED BY: LWJ	

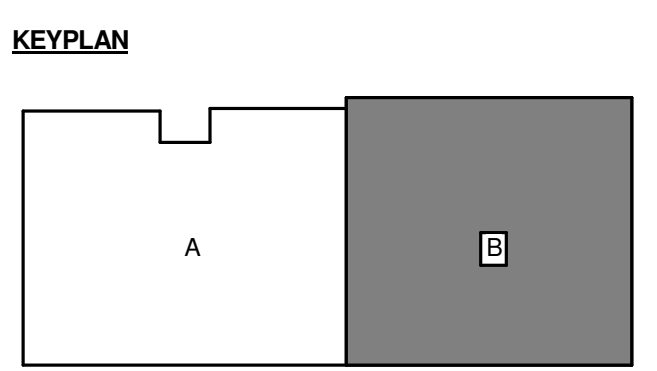

6/3/2016 4:04:14 PM
C:\Users\lwm\Documents\407110 - ASYLUM DANCE CLUB - ELEC. lwm\lwm.rvt