


- TECHNICAL NOTES:**
- LOCATE POWER JACKS FOR POS SYSTEM BENEATH WORKTOP, BEHIND BAR TOP
 - EXISTING DEVICES ON EXISTING SURFACES SHALL REMAIN UNLESS NOTED OTHERWISE
 - EXISTING PANEL RENAMED L2. UPDATE LABEL AT PANEL MDP.
 - REFER TO DETAIL K1/PL503 FOR MORE INFORMATION.
 - REFER TO TECH NOTE IN THIS LOCATION ON SHEET EY101A FOR WALL BOX INFORMATION.
 - PROPOSED ROUTE FOR UNDERSLAB SECONDARY CONDUITS. FIELD COORDINATE ACTUAL ROUTE WITH ALL TRADES.
 - HVAC CONTROL POWER. LOCATE WITHIN JUNCTION BOX AT CEILING. COORDINATE WITH DIV. 23 CONTRACTOR FOR EXACT LOCATION.
 - CIRCUIT FOR DOOR HARDWARE POWER SUPPLY. LOCATE ABOVE ACCESSIBLE CEILING. COORDINATE EXACT LOCATION IN FIELD WITH SECURITY VENDOR.

REV.	DESCRIPTION	DATE
0	ISSUED FOR BID	06 JUNE 2016

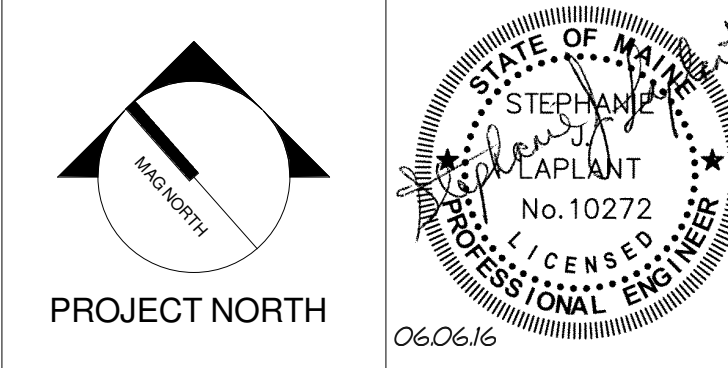


WBRC
ARCHITECTS ENGINEERS
WWW.WBRCAE.COM
BANGOR, MAINE 207-947-4511
PORTLAND, MAINE 207-828-4511
SARASOTA, FLORIDA 941-556-0757

PROJECT:
ASYLUM

SHEET TITLE:
BASEMENT POWER PLAN - SEGMENT A

WBRC CAD FILE: C:\Users\lyfe.mahar\Documents\407110 - ASYLUM DANCE CLUB - ELEC_lyfe.mahar.rvt	GRAPHIC SCALE: 0" = 1"
PROJECT No: 4071.10	SHEET No:
SCALE: 1/4" = 1'-0"	EP101A
PROJECT MANAGER: JRB	CHECKED BY: SJL
DRAWN BY: KRM	

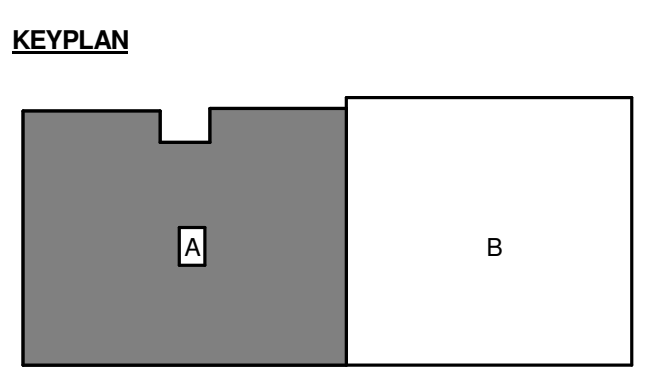

6/3/2016 3:16:36 PM C:\Users\lyfe.mahar\Documents\407110 - ASYLUM DANCE CLUB - ELEC_lyfe.mahar.rvt

A1 BASEMENT POWER PLAN - SEGMENT A
1/4" = 1'-0"