


- TECHNICAL NOTES:**
- LOCATE POWER JACKS FOR POS SYSTEM BENEATH WORKTOP.
 - REFER TO TECH NOTE IN THIS LOCATION ON SHEET EY101B FOR WALL BOX INFORMATION.
 - SINGLE GANG JUNCTION BOX WITH (2) PILOT LIGHTS. LABEL "LIGHTS AND OUTLETS". CONNECT TO SWITCHES AT MAKE UP TABLE PER REQUIREMENT OF NEC ART. 520.73. SWITCH FOR MAKEUP LIGHTS SHOWN ON SHEET EL101B.
 - CONNECT TO PILOT LIGHT "OUTLETS" ADJACENT TO DOOR. LOCATE ADJACENT TO LIGHT SWITCH UNDER SAME FACEPLATE. LABEL BOTH SWITCHES TO MATCH PILOT LIGHTS. REFER TO TECH NOTE 3.
 - EG SHALL CONNECT LINE VOLTAGE ON BOTH SIDES OF SUMP PUMP CONTROLLER.
 - PROPOSED ROUTE FOR SECONDARY CONDUITS. FIELD COORDINATE ACTUAL ROUTE WITH ALL TRADES.
 - HVAC CONTROL POWER. LOCATE WITHIN JUNCTION BOX ABOVE CEILING. COORDINATE WITH DIV. 23 CONTRACTOR FOR EXACT LOCATION.
 - CIRCUIT FOR DOOR HARDWARE POWER SUPPLY. LOCATE ABOVE ACCESSIBLE CEILING. COORDINATE EXACT LOCATION IN FIELD WITH SECURITY VENDOR.
 - WINDOW SHADE CONNECTION - REFER TO DETAIL A1/E-302.

REV.	DESCRIPTION	DATE
0	ISSUED FOR BID	06 JUNE 2016

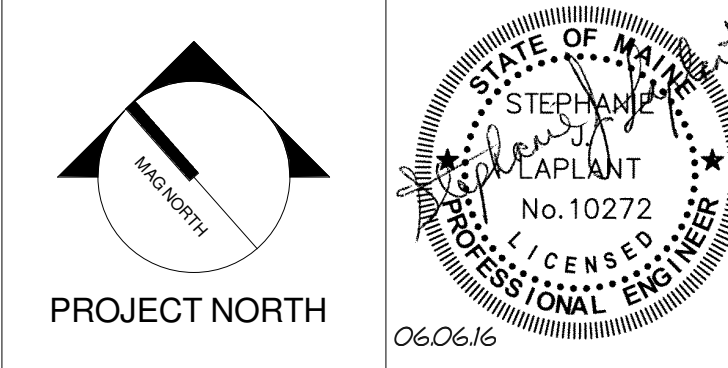

WBRC
 ARCHITECTS ENGINEERS
 WWW.WBRCAE.COM
 BANGOR, MAINE 207-947-4511
 PORTLAND, MAINE 207-828-4511
 SARASOTA, FLORIDA 941-556-0757

PROJECT:
ASYLUM

SHEET TITLE:
BASEMENT POWER PLAN - SEGMENT B

WBRC CAD FILE: C:\Users\jlaplant\Documents\407110 - ASYLUM DANCE CLUB - ELEC - Asylum.rvt	GRAPHIC SCALE: 0" = 1"
PROJECT No: 4071.10	SHEET No:
SCALE: 1/4" = 1'-0"	EP101B
PROJECT MANAGER: JRB	CHECKED BY: SJL
DRAWN BY: KRM	

6/3/2016 4:14:38 PM
 C:\Users\jlaplant\Documents\407110 - ASYLUM DANCE CLUB - ELEC - Asylum.rvt

A1 BASEMENT PLWER PLAN - SEGMENT B
 1/4" = 1'-0"