


TECHNICAL NOTES:
 ① HVAC CONTROL POWER. LOCATE WITHIN JUNCTION BOX ABOVE CEILING. COORDINATE WITH DIV. 23 CONTRACTOR FOR EXACT LOCATION.
 ② CIRCUIT FOR DOOR HARDWARE POWER SUPPLY LOCATE AT CEILING. COORDINATE EXACT LOCATION IN FIELD WITH SECURITY VENDOR.

REV.	DESCRIPTION	DATE
0	ISSUED FOR BID	06 JUNE 2016

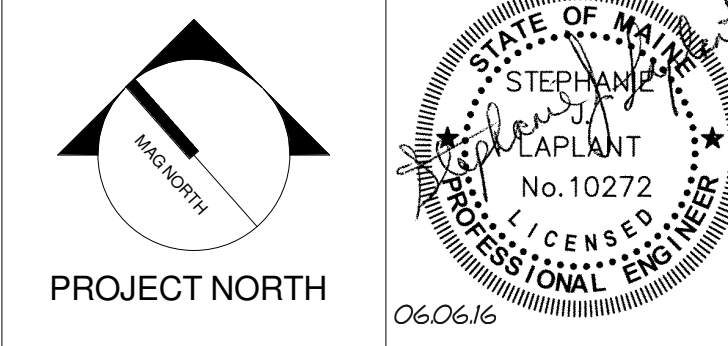

WBRC
 ARCHITECTS ENGINEERS
 WWW.WBRCAE.COM
 BANGOR, MAINE 207-947-4511
 PORTLAND, MAINE 207-428-4511
 SARASOTA, FLORIDA 941-556-0757

PROJECT:
ASYLUM

SHEET TITLE:
LOWER BALCONY POWER PLAN

WBRC CAD FILE: C:\Users\jlaplant\Documents\407110 - ASYLUM DANCE CLUB - ELEC. lyfe.mahar.rvt	GRAPHIC SCALE: 0" = 1"
PROJECT No: 4071.10	SHEET No. EP103
SCALE: 1/4" = 1'-0"	CHECKED BY: SJL
PROJECT MANAGER: JRB	
DRAWN BY: KRM	

