



TECHNICAL NOTES:


- ① FIELD LOCATE SMOKE DETECTORS TO AVOID LIGHTING FIXTURES AND OTHER UTILITIES IN THIS SPACE. REFER TO SPECIFICATION FOR SPACING REQUIREMENTS.
- ② EXISTING DEVICES ON EXISTING SURFACES SHALL REMAIN UNLESS SPECIFICALLY NOTED OTHERWISE.

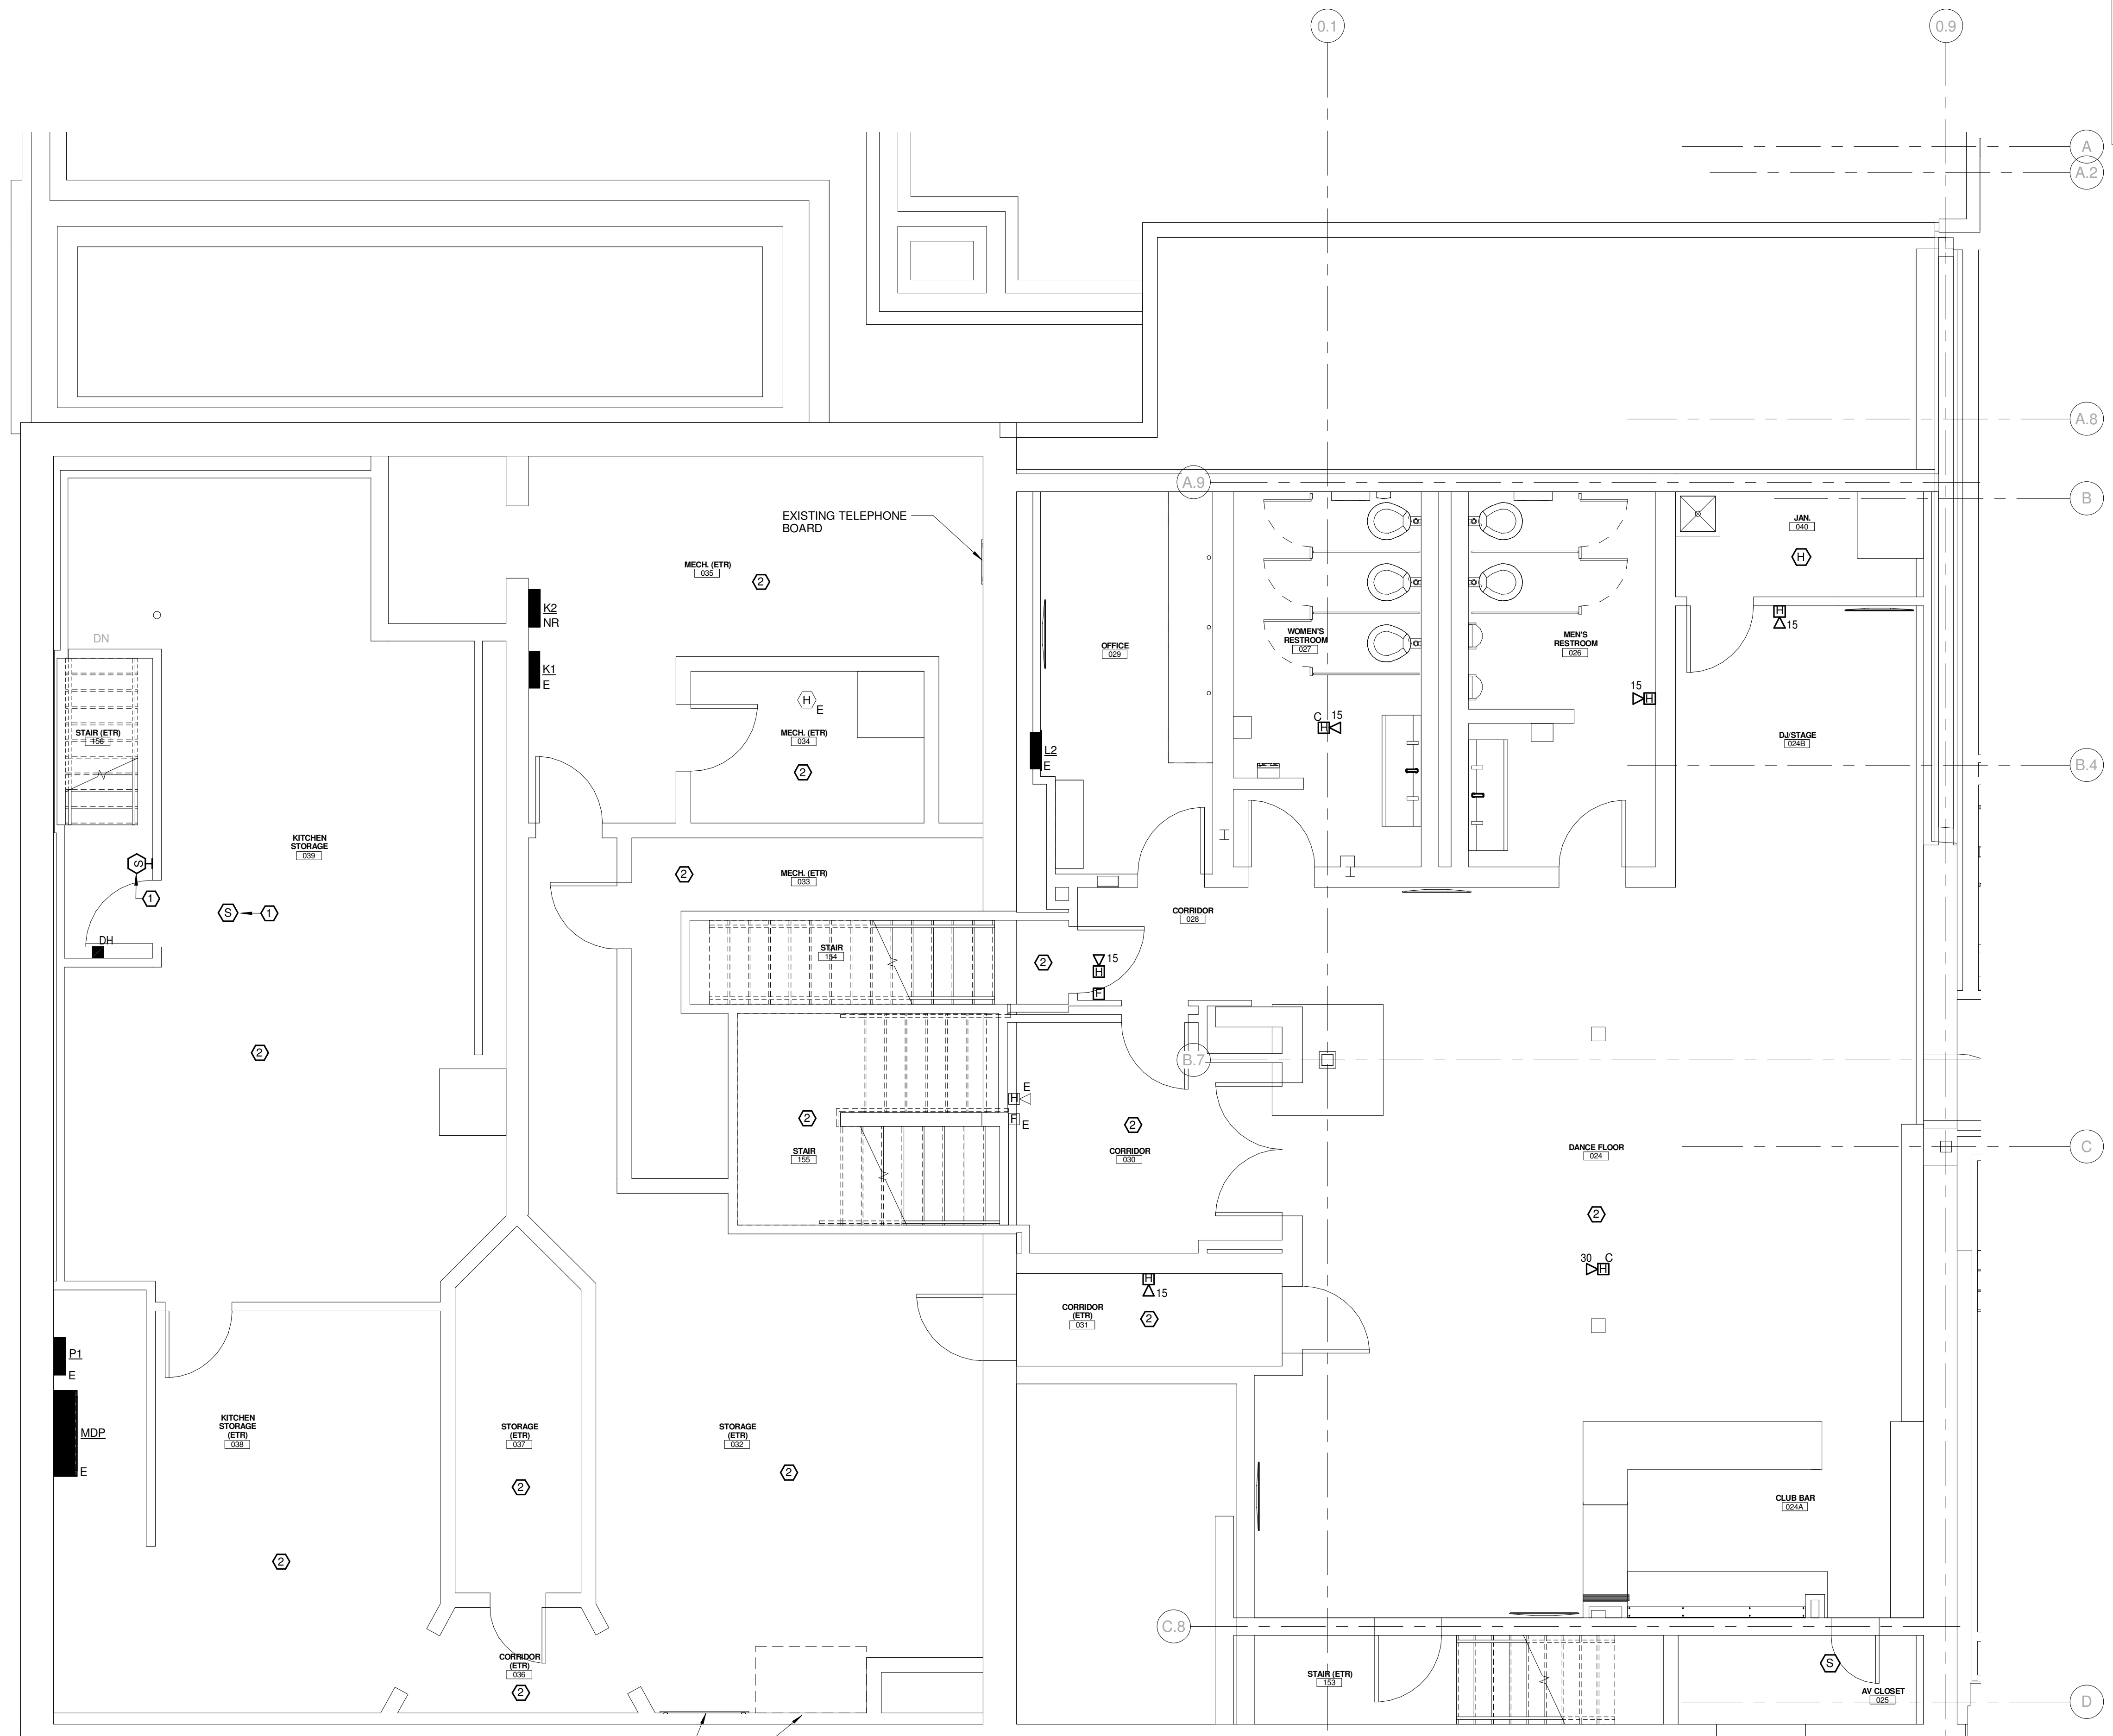

REV.	DESCRIPTION	DATE
0	ISSUED FOR BID	06 JUNE 2016

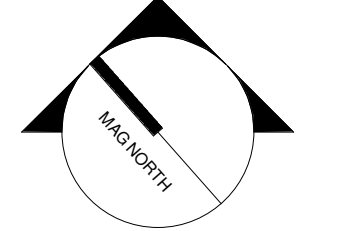

PROJECT NORTH

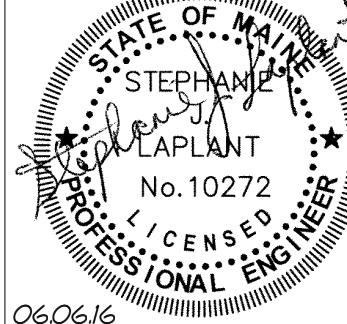

STEPHANE LAPLANT
No. 10272
LICENSED PROFESSIONAL ENGINEER

WBRC
ARCHITECTS ENGINEERS

WWW.WBRCAE.COM
BANGOR, MAINE 207-947-4511
PORTLAND, MAINE 207-428-4511
SARASOTA, FLORIDA 941-556-0757


PROJECT: ASYLUM

BASEMENT FIRE ALARM PLAN - SEGMENT A

SHEET TITLE:

WBRC CAD FILE: C:\Users\jyle\mshar\Documents\407110 - ASYLUM DANCE CLUB - ELEC. \jyle.mshar.rvt

PROJECT No. 4071.10	GRAPHIC SCALE: 0" = 1"
SCALE: 1/4" = 1'-0"	SHEET No.
PROJECT MANAGER: JRB	FA101A
DRAWN BY: KRM	CHECKED BY: SJL

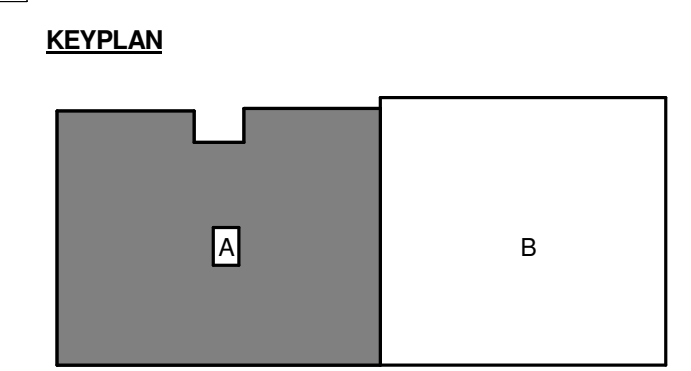

6/3/2016 3:17:06 PM C:\Users\jyle\mshar\Documents\407110 - ASYLUM DANCE CLUB - ELEC. \jyle.mshar.rvt