



TECHNICAL NOTES:
 ① EXISTING DEVICES ON EXISTING SURFACES SHALL REMAIN UNLESS SPECIFICALLY NOTED OTHERWISE.

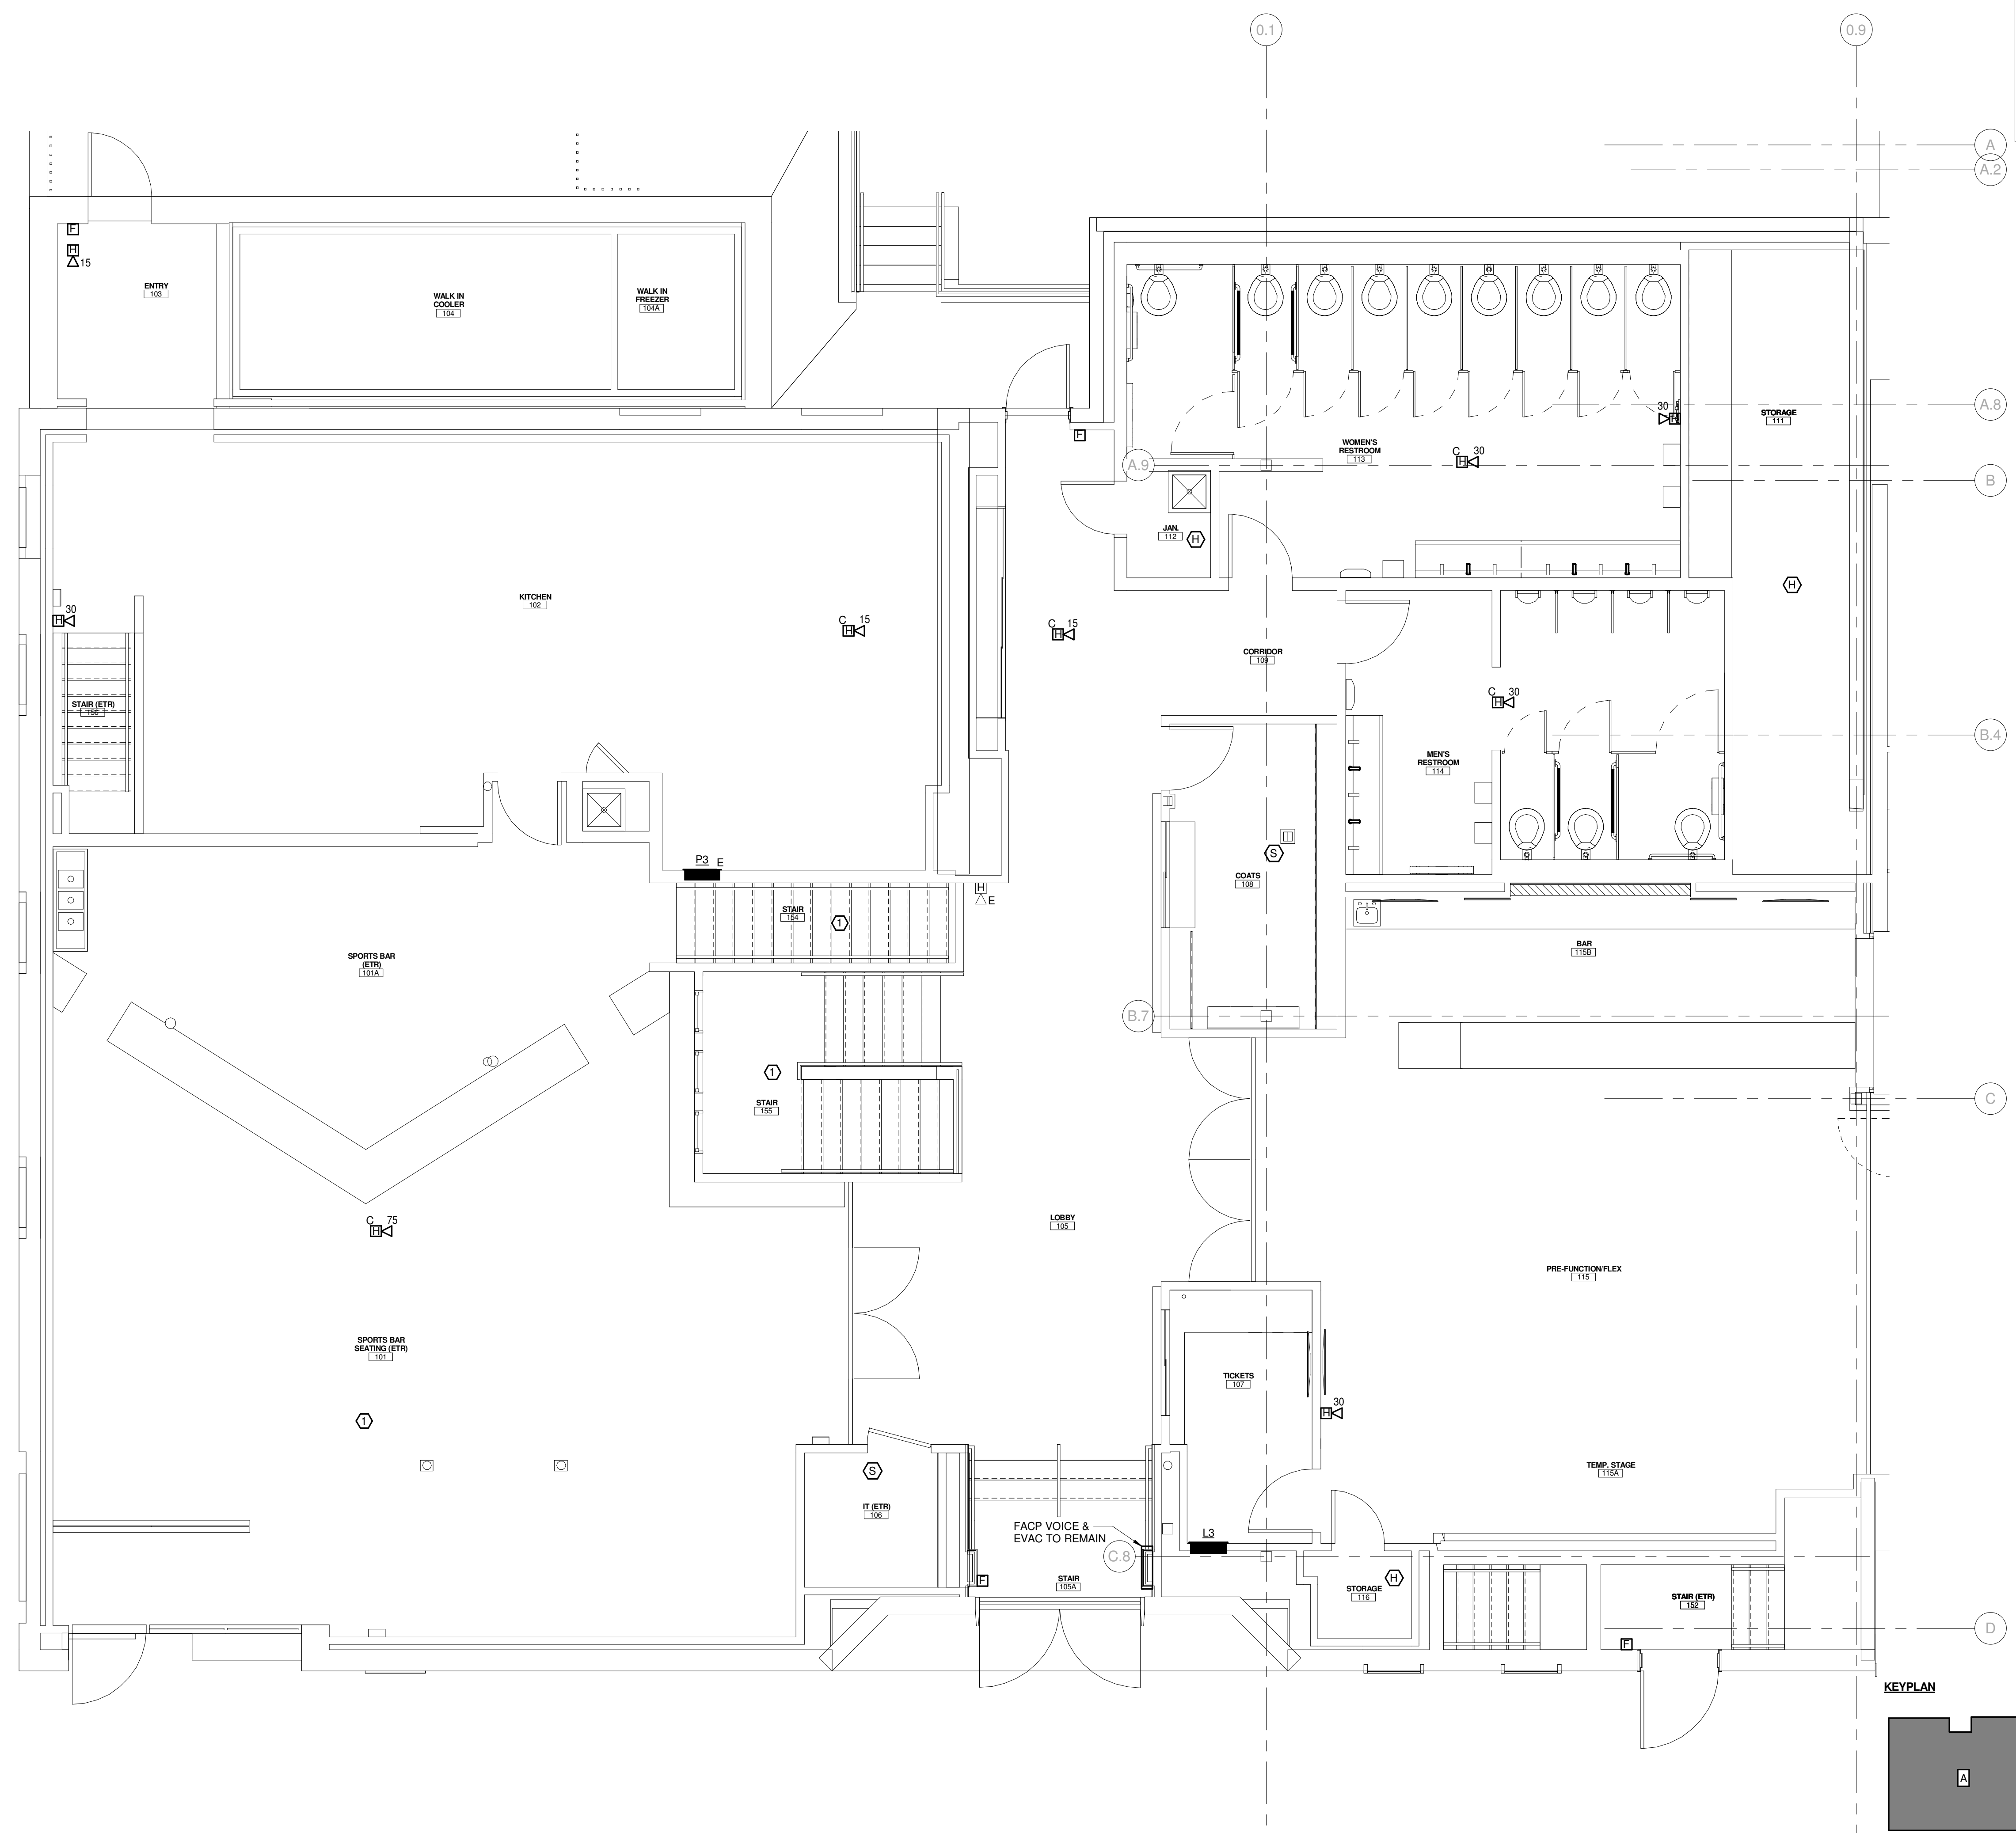

| REV. | DESCRIPTION | DATE |
|------|----------------|--------------|
| 0 | ISSUED FOR BID | 06 JUNE 2016 |

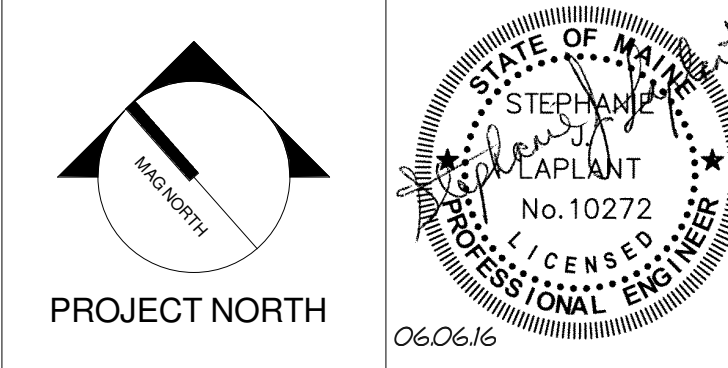

WBRC
 ARCHITECTS ENGINEERS
 WWW.WBRCAE.COM
 BANGOR, MAINE 207-947-4511
 PORTLAND, MAINE 207-428-4511
 SARASOTA, FLORIDA 941-556-0757

ASYLUM

PROJECT:
FIRST FLOOR FIRE ALARM PLAN - SEGMENT A

| | |
|--|------------------------|
| SHEET TITLE: | |
| WBRC CAD FILE: C:\Users\jle\mshar\Documents\407110 - ASYLUM DANCE CLUB - ELEC_lyle.mshar.rvt | GRAPHIC SCALE: 0" = 1" |
| PROJECT No 4071.10 | SCALE: 1/4" = 1'-0" |
| PROJECT MANAGER JRB | SHEET No: |
| DRAWN BY KRM | FA102A |
| CHECKED BY: SJL | |

A1 FIRST FLOOR SYSTEMS PLAN - SEGMENT A
 1/4" = 1'-0"

6/3/2016 3:17:10 PM
 C:\Users\jle\mshar\Documents\407110 - ASYLUM DANCE CLUB - ELEC_lyle.mshar.rvt