



**TECHNICAL NOTES:**


① FIRE ALARM CONNECTION TO AUDIO SHUNT SYSTEM IN THIS RACK.

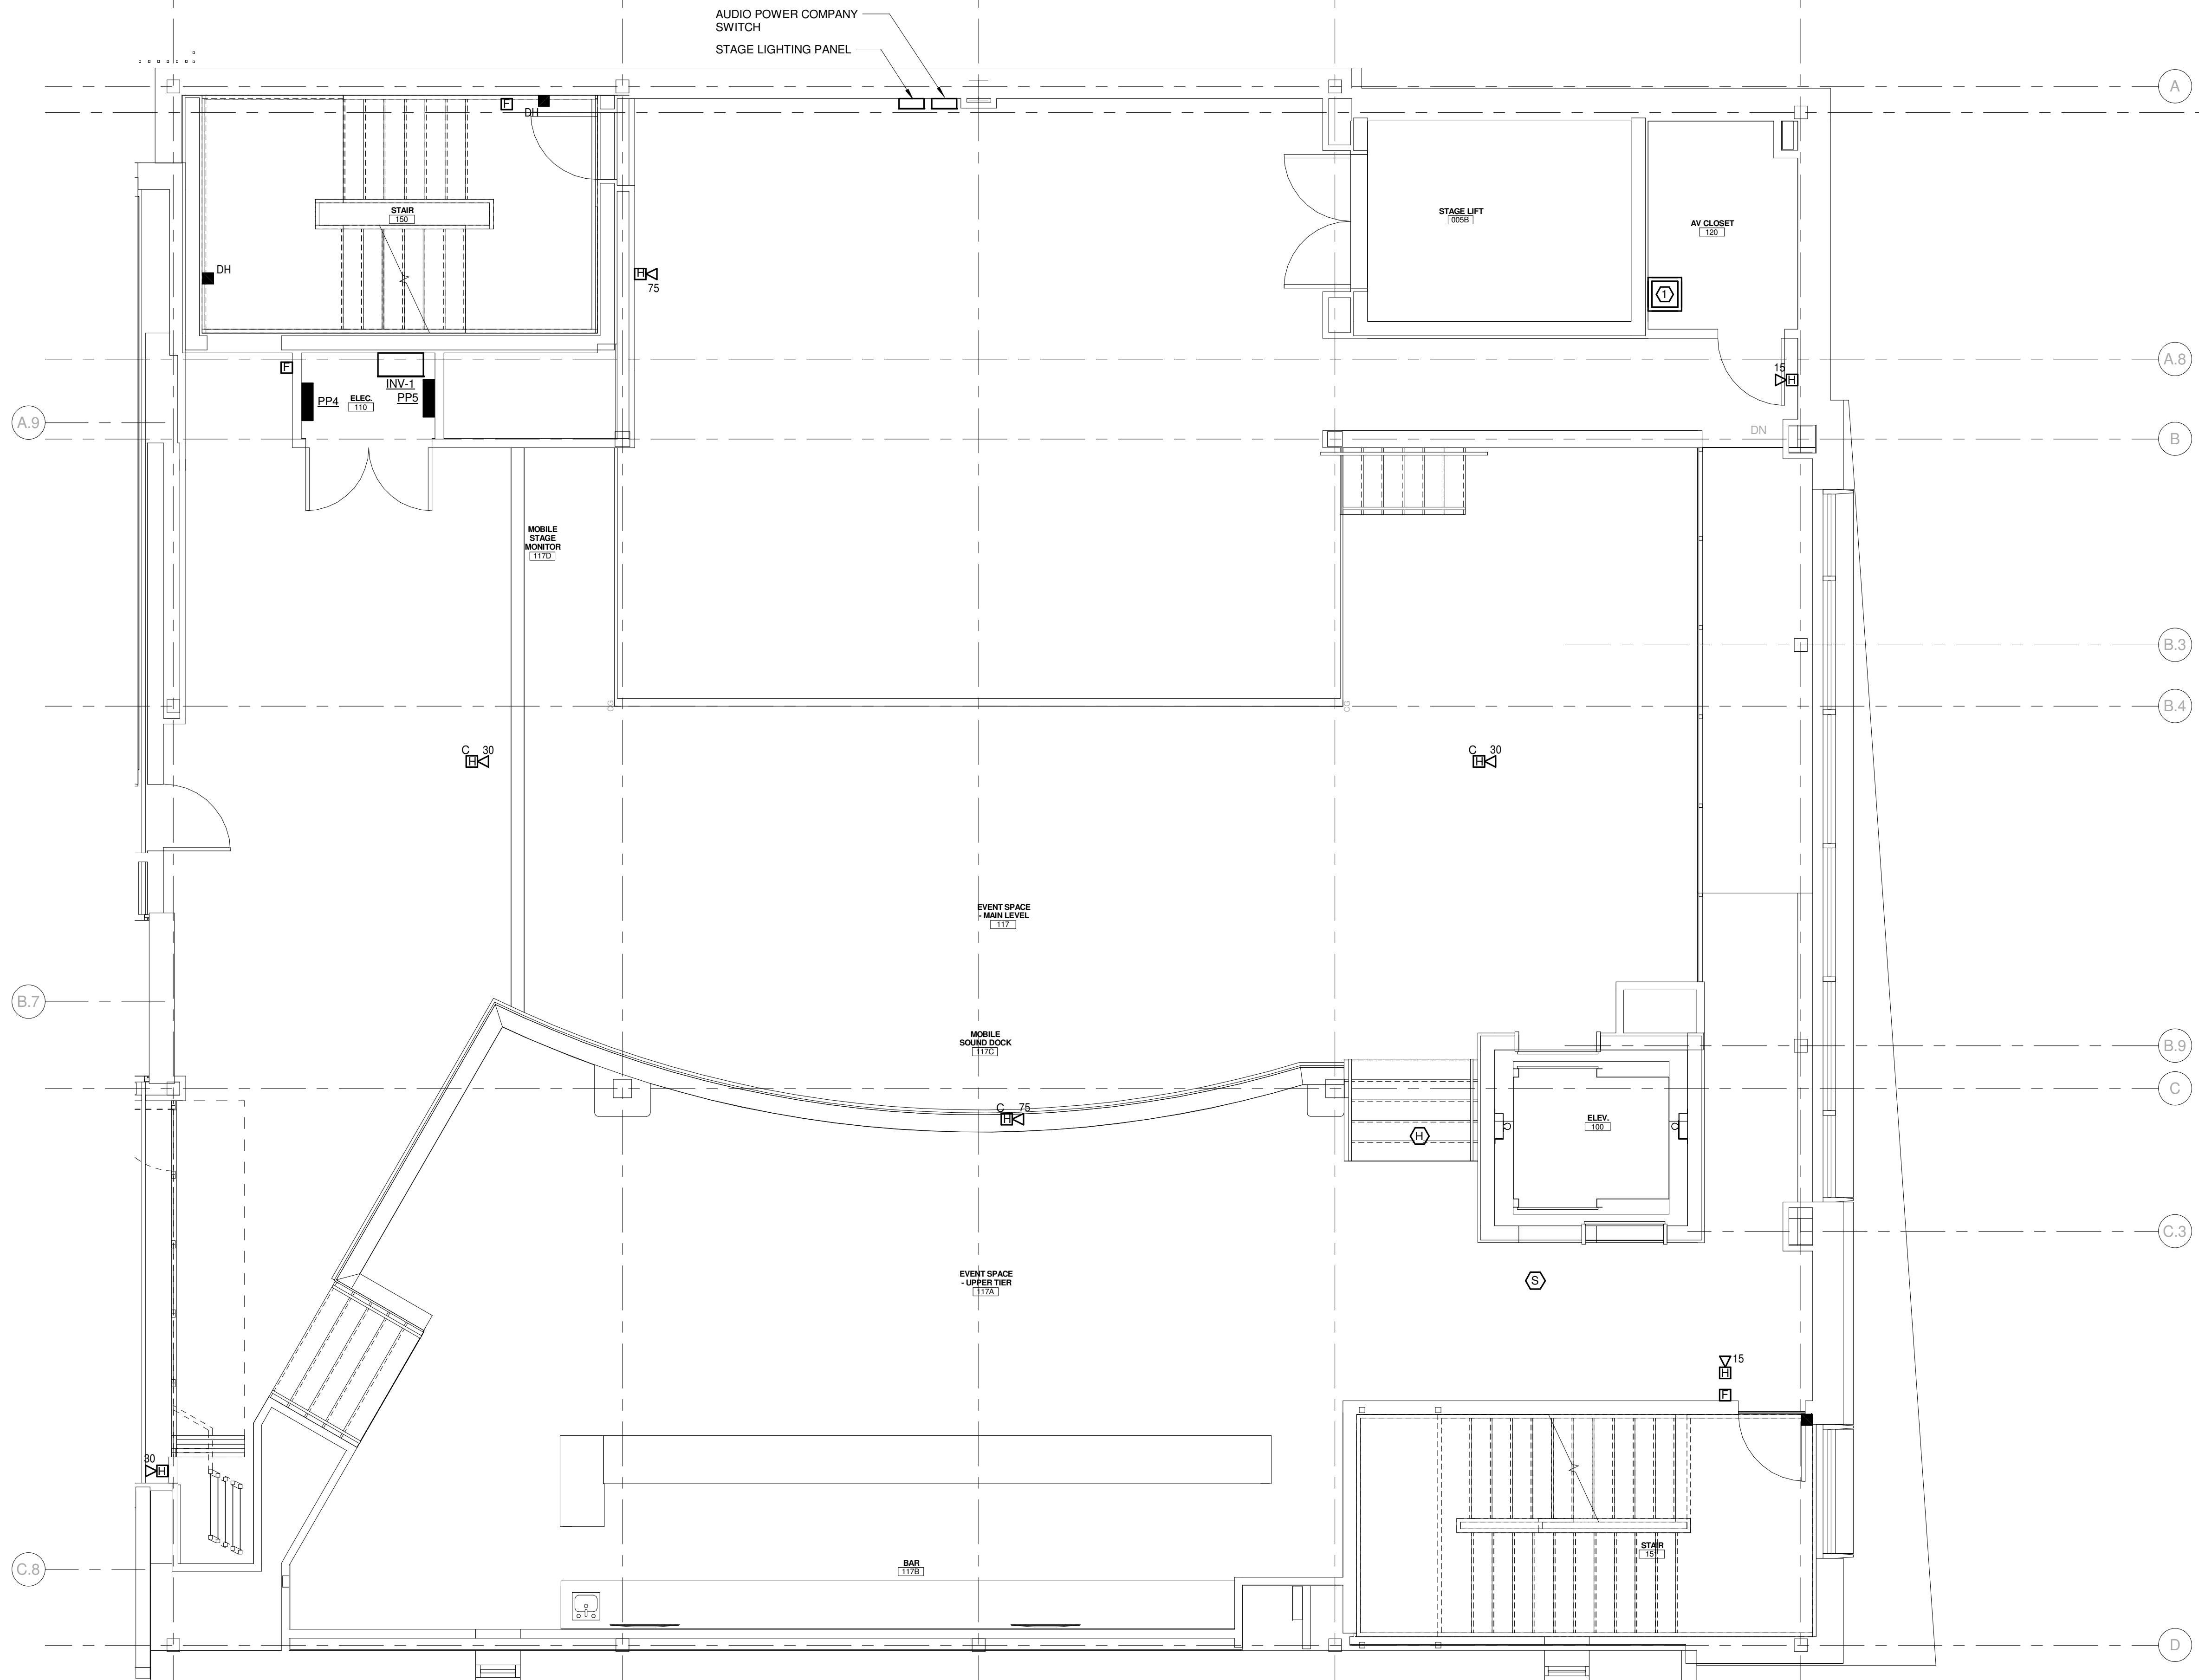


**KEYPLAN**

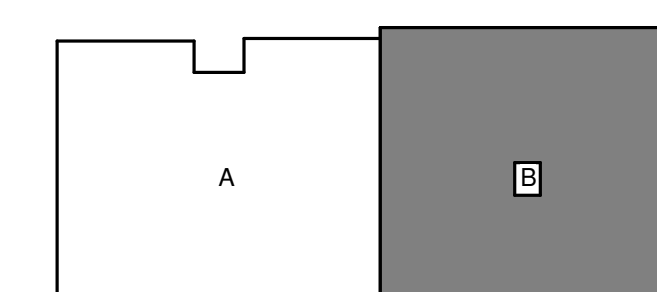

REV.	DESCRIPTION	DATE
0	ISSUED FOR BID	06 JUNE 2016

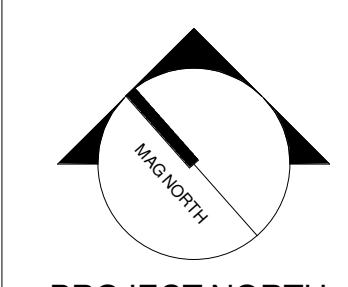

PROJECT NORTH

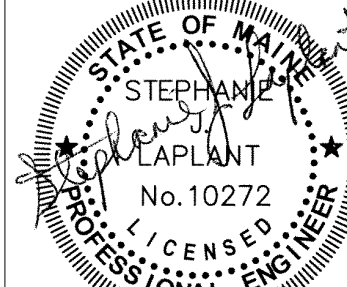

06/06/16

**WBRC**  
ARCHITECTS ENGINEERS  
WWW.WBRCAE.COM  
BANGOR, MAINE 207-947-4511  
PORTLAND, MAINE 207-428-4511  
SARASOTA, FLORIDA 941-556-0757

ASYLUM

PROJECT:  
**FIRST FLOOR FIRE ALARM PLAN - SEGMENT B**

SHEET TITLE:  
WBRC CAD FILE: C:\Users\lyle.mahar\Documents\407110 - ASYLUM DANCE CLUB - ELEC.lyle.mahar.rvt  
PROJECT No: 4071.10 GRAPHIC SCALE: 0" 1"  
SCALE: 1/4" = 1'-0"  
PROJECT MANAGER: JRB SHEET No:  
DRAWN BY: KRM **FA102B**  
CHECKED BY: SJL

**A1** FIRST FLOOR SYSTEMS PLAN - SEGMENT B  
1/4" = 1'-0"

6/3/2016 3:17:13 PM C:\Users\lyle.mahar\Documents\407110 - ASYLUM DANCE CLUB - ELEC.lyle.mahar.rvt