




FACTORY MOUNTED SMOKE DETECTORS
CONNECT TO FIRE ALARM SYSTEM

RTU-7
(ON ROOF ABOVE)

KEYPLAN

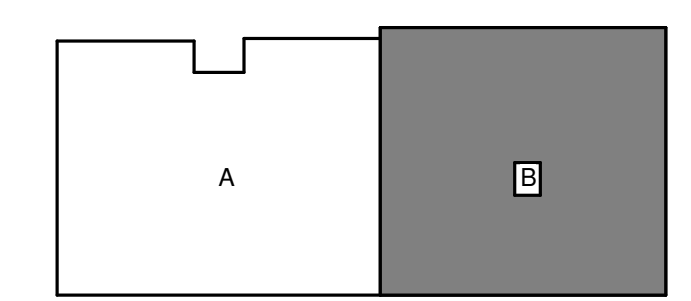

| REV. | DESCRIPTION | DATE |
|------|----------------|--------------|
| 0 | ISSUED FOR BID | 06 JUNE 2016 |

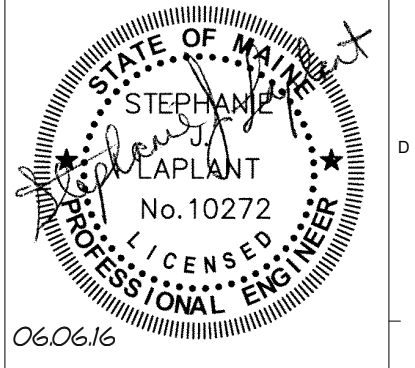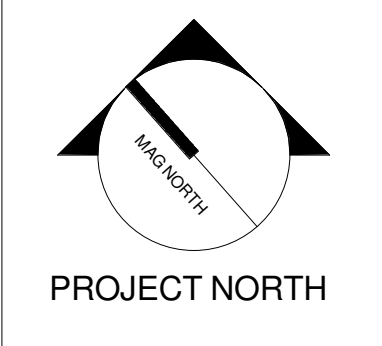

WBRC
ARCHITECTS ENGINEERS
WWW.WBRCAE.COM
BANGOR, MAINE 207-947-4511
PORTLAND, MAINE 207-428-4511
SARASOTA, FLORIDA 941-556-0757

PROJECT:
ASYLUM

SHEET TITLE:
UPPER BALCONY FIRE ALARM PLAN

WBRC CAD FILE: C:\Users\jlmahar\Documents\407110 - ASYLUM DANCE CLUB - ELEC - jlmahar.rvt
PROJECT No: 4071.10
SCALE: 1/4" = 1'-0"

PROJECT MANAGER: JRB
DRAWN BY: KRM
CHECKED BY: SJL

SHEET No:
FA104

6/3/2016 3:17:19 PM
C:\Users\jlmahar\Documents\407110 - ASYLUM DANCE CLUB - ELEC - jlmahar.rvt

A1 LOWER BALCONY SYSTEMS PLAN
1/4" = 1'-0"