


ASYLUM

121 CENTER STREET
PORTLAND, MAINE 04101

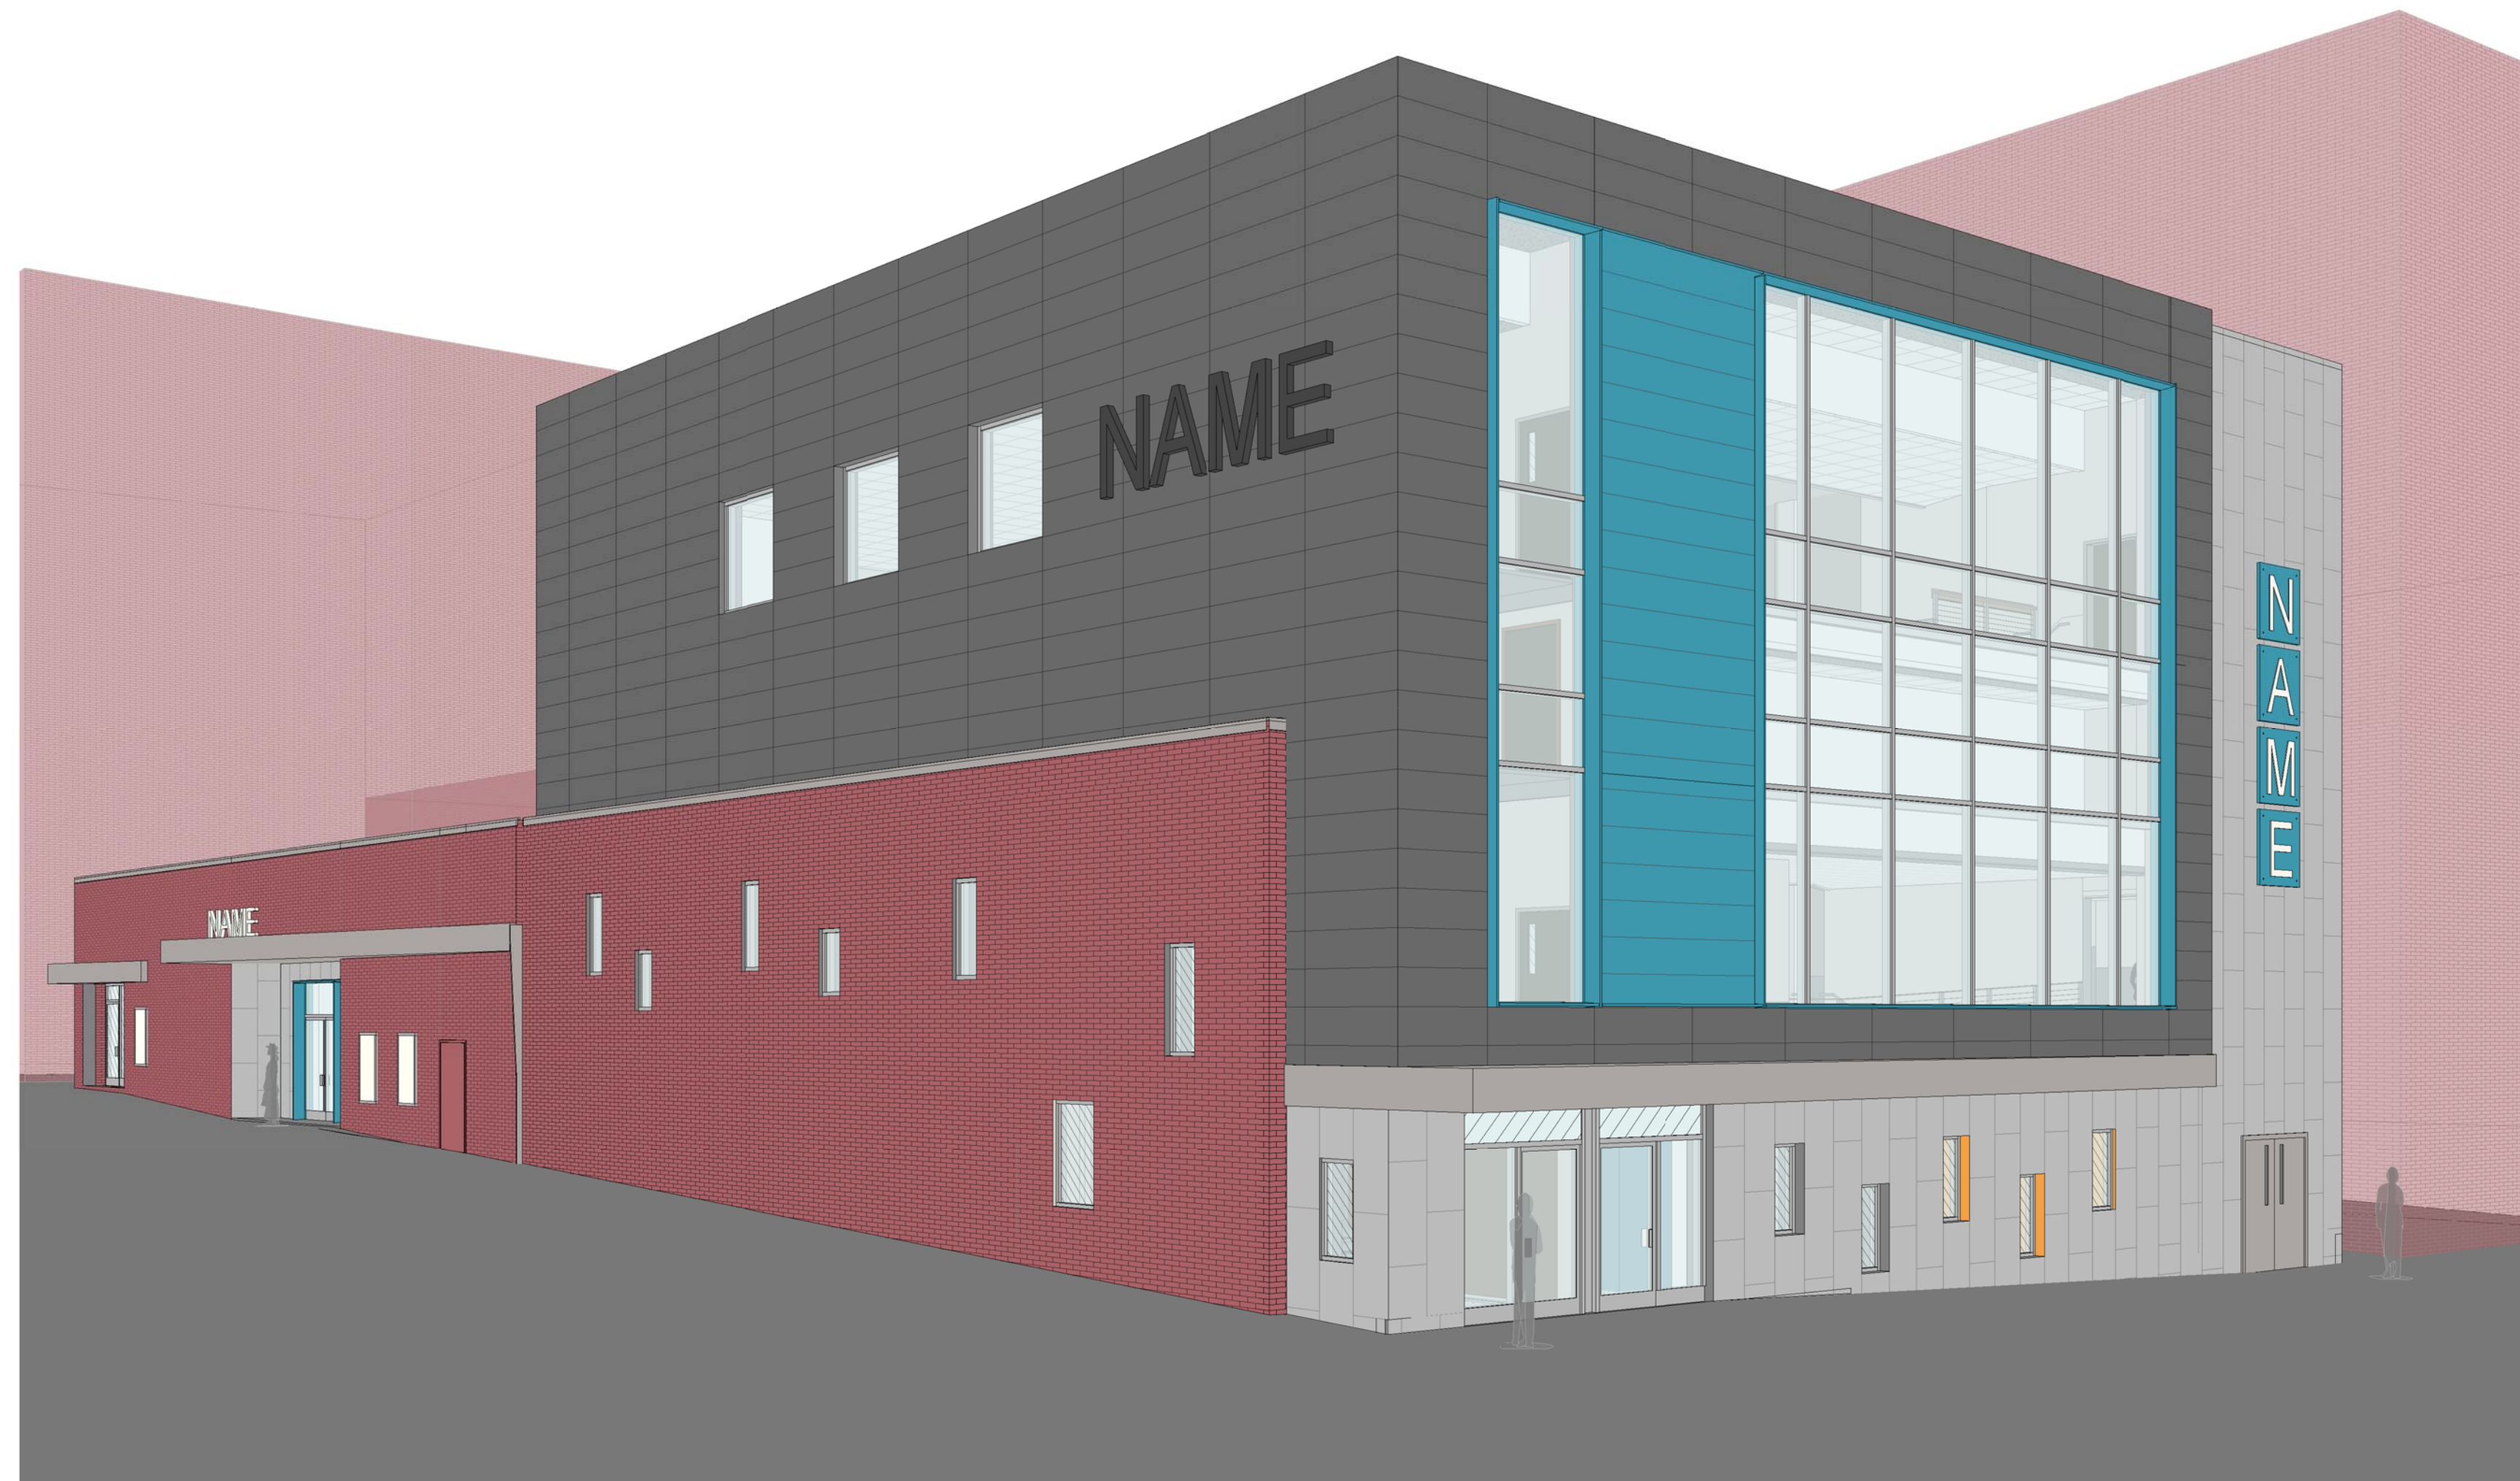

SHEET INDEX

GENERAL DRAWING

GI001	COVER SHEET
GI002	SYMBOLS AND ABBREVIATIONS
GI003	CODE REVIEW NOTES
GI004	CODE REVIEW BASEMENT AND FIRST FLOOR PLANS
GI005	CODE REVIEW BALCONY PLAN AND CALCULATIONS
GI006	PHASING PLANS

CIVIL DRAWINGS

C-001	SITE GENERAL NOTES AND ABBREVIATIONS
CS101	BOUNDARY & TOPOGRAPHIC SURVEY
CD101	SITE REMOVALS PLAN
CP101	SITE LAYOUT AND MATERIALS PLAN
CG101	SITE GRADING AND EROSION CONTROL PLAN
CU101	SITE UTILITY PLAN
C501	SITE DETAILS
C502	SITE DETAILS
C503	SITE DETAILS
C504	SITE DETAILS
C505	SITE DETAILS
C601	SITE BORING LOGS
C602	SITE BORING LOGS

STRUCTURAL DRAWINGS

S-000	STRUCTURAL TESTS AND SPECIAL INSPECTIONS
S-001	STRUCTURAL GENERAL NOTES
S-101	FOUNDATION AND FLOOR SLAB PLAN
S-101B	FOUNDATION AND FLOOR SLAB PLAN - SEG B
S-102	FIRST FLOOR FOUNDATION AND FRAMING PLAN
S-102B	FIRST FLOOR FOUNDATION AND FRAMING PLAN - SEG B
S-102C	STAGE AND UPPER TIER EVENT FLOOR FRAMING PLAN
S-103	EXISTING ROOF AND LOWER BALCONY FLOOR FRAMING PLAN
S-103A	EXISTING ROOF FRAMING PLAN - SEG A
S-103B	LOWER BALCONY FLOOR FRAMING PLAN - SEG B
S-104B	UPPER BALCONY AND TIERED SEATING FLOOR FRAMING PLAN - SEG B
S-105B	ROOF FRAMING PLAN - SEG B
S-105C	STAGE RIGGING FRAMING PLAN
S-200	TYPICAL BRACING DETAILS AND NOTES
S-201	BRACING ELEVATIONS
S-300	TYPICAL FOUNDATION SECTIONS AND DETAILS
S-301	TYPICAL FOUNDATION SECTIONS AND DETAILS
S-302	FOUNDATION SECTIONS AND DETAILS
S-303	FOUNDATION SECTIONS AND DETAILS
S-304	FOUNDATION SECTIONS AND DETAILS
S-400	BALCONY FRAMING SECTIONS
S-401	BALCONY FRAMING DETAILS
S-500	TYPICAL FRAMING SECTIONS AND DETAILS
S-501	TYPICAL FRAMING SECTIONS AND DETAILS
S-502	FRAMING SECTIONS AND DETAILS
S-503	FRAMING SECTIONS AND DETAILS
S-504	FRAMING SECTIONS AND DETAILS
S-505	FRAMING SECTIONS AND DETAILS
S-506	FRAMING SECTIONS AND DETAILS
S-507	FRAMING SECTIONS AND DETAILS

ARCHITECTURAL DRAWINGS

AD101	BASEMENT & FIRST FLOOR REMOVALS PLAN
AD102	ROOF REMOVALS PLAN
AE100	ARCHITECTURAL SITE PLAN
AE101	BASEMENT FLOOR PLAN - OVERALL
AE101A	BASEMENT FLOOR PLAN - SEGMENT A
AE101B	BASEMENT FLOOR PLAN - SEGMENT B
AE102	FIRST FLOOR PLAN - OVERALL
AE102A	FIRST FLOOR PLAN - SEGMENT A
AE102B	FIRST FLOOR PLAN - SEGMENT B
AE103	LOWER BALCONY AND ROOF PLAN - OVERALL
AE103B	LOWER BALCONY PLAN - SEGMENT B
AE104	UPPER BALCONY PLAN - SEGMENT B
AE105	ROOF PLAN - OVERALL

AE111A	BASEMENT REFLECTED CEILING PLAN - SEGMENT A
AE111B	BASEMENT REFLECTED CEILING PLAN - SEGMENT B
AE112A	FIRST FLOOR REFLECTED CEILING PLAN - SEGMENT A
AE112B	FIRST FLOOR REFLECTED CEILING PLAN - SEGMENT B
AE113B	LOWER BALCONY REFLECTED CEILING PLAN - SEGMENT B
AE114B	BALCONY REFLECTED CEILING PLAN - SEGMENT B
AE201	BUILDING PERSPECTIVES
AE202	BUILDING ELEVATIONS
AE203	BUILDING ELEVATIONS
AE205	INTERIOR ELEVATIONS
AE206	INTERIOR ELEVATIONS
AE207	INTERIOR ELEVATIONS
AE208	INTERIOR ELEVATIONS
AE301	BUILDING SECTIONS
AE302	BUILDING SECTIONS
AE303	BUILDING SECTIONS
AE304	NOT IN USE
AE305	WALL SECTIONS
AE306	WALL SECTIONS
AE307	WALL SECTIONS
AE308	WALL SECTIONS
AE309	WALL SECTIONS
AE310	SPORTS BAR CANOPY
AE311	MAIN ENTRY CANOPY
AE312	VIP ENTRY CANOPY
AE313	BALCONY WALL SECTIONS
AE401	ENLARGED RESTROOM PLANS & ELEVATIONS
AE402	ENLARGED RESTROOM PLANS & ELEVATIONS
AE403	ENLARGED RESTROOM PLANS & ELEVATIONS
AE404	ENLARGED RESTROOM PLANS & ELEVATIONS
AE405	RESTROOM TILE PATTERNS
AE406	ENLARGED BAR PLANS & ELEVATIONS
AE407	ENLARGED BAR PLANS & ELEVATIONS
AE503	EXTERIOR SECTION DETAILS
AE504	EXTERIOR SECTION DETAILS
AE505	CAST STONE PANEL FLASHING DETAILS
AE506	ROOF DETAILS
AE508	INTERIOR PLAN DETAILS & TRANSITION DETAILS
AE510	INTERIOR CEILING DETAILS
AE511	INTERIOR CEILING DETAILS
AE512	MILLWORK DETAILS
AE513	MILLWORK DETAILS
AE514	MILLWORK DETAILS
AE515	STAIR 151 SECTIONS & PLANS
AE516	STAIR 150 SECTIONS & PLANS
AE517	MISC STAIR SECTIONS & PLANS
AE518	STAIR 151 DETAILS
AE519	TYPICAL STAIR DETAILS
AE520	STAIR DETAILS
AE521	ELEVATOR SECTIONS & DETAILS
AE522	STAGE LIFT SECTIONS & DETAILS
AE601	DOOR TYPES & SCHEDULE
AE602	DOOR DETAILS
AE603	PARTITION TYPES AND TYPICAL DETAILS
AE604	WALL AND ROOF TYPES
AE605	SPECIALTY DOOR AND WINDOW TYPES
AE606	WINDOW DETAILS
AE607	CURTAIN WALL DETAILS
AE608	TYPICAL RAILING TYPES
AE610	BASEMENT FINISH SCHEDULE
AE611	FIRST FLOOR AND BALCONY FINISH SCHEDULE
AF101A	BASEMENT FINISH PLAN - SEGMENT A
AF101B	BASEMENT FINISH PLAN - SEGMENT B
AF102A	FIRST FLOOR FINISH PLAN - SEGMENT A
AF102B	FIRST FLOOR FINISH PLAN - SEGMENT B
AF104B	BALCONY FINISH PLAN

PLUMBING DRAWINGS

PD101	BASEMENT & FIRST FLOOR PLUMBING DEMO PLANS
PL101	BASEMENT PLUMBING PLAN
PL102	FIRST FLOOR PLUMBING PLANS
PL103	BALCONY AND ROOF PLUMBING PLAN
PL104	UPPER BALCONY PLUMBING PLAN
PL501	PLUMBING RISER DIAGRAMS
PL502	PLUMBING RISER DIAGRAMS
PL503	PLUMBING DETAILS
PL504	PLUMBING DETAILS
PL601	PLUMBING SCHEDULES

MECHANICAL DRAWINGS

M-001	MECHANICAL LEGEND
MD101	BASEMENT & FIRST FLOOR REMOVALS PLAN
MD102	ROOF MECHANICAL REMOVALS PLAN
MH101	BASEMENT MECHANICAL DUCTWORK PLAN
MP101	BASEMENT MECHANICAL PIPING PLAN
M-102	FIRST FLOOR MECHANICAL PLAN
M-103	BALCONY MECHANICAL PLAN
M-104	UPPER BALCONY MECHANICAL PLAN
M-105	MECHANICAL ROOF PLAN
M-501	MECHANICAL DETAILS
M-601	MECHANICAL SCHEDULES
M-602	MECHANICAL SCHEDULES

ELECTRICAL DRAWINGS

E-001	ELECTRICAL LEGEND & LIGHT FIXTURE SCHEDULE
ED101	BASEMENT & FIRST FLOOR ELECTRICAL REMOVALS PLANS
EL101A	BASEMENT LIGHTING PLAN - SEGMENT A
EL101B	BASEMENT LIGHTING PLAN - SEGMENT B
EL102A	FIRST FLOOR LIGHTING PLAN - SEGMENT A
EL102B	FIRST FLOOR LIGHTING PLAN - SEGMENT B
EL103	LOWER BALCONY LIGHTING PLAN
EL104	UPPER BALCONY LIGHTING PLAN
EP101A	BASEMENT POWER PLAN - SEGMENT A
EP101B	BASEMENT POWER PLAN - SEGMENT B
EP102A	FIRST FLOOR POWER PLAN - SEGMENT A
EP102B	FIRST FLOOR POWER PLAN - SEGMENT B
EP103	LOWER BALCONY POWER PLAN
EP104	UPPER BALCONY POWER PLAN
EP105	ROOF ELECTRICAL POWER PLAN
EY101A	BASEMENT SYSTEMS PLAN - SEGMENT A
EY101B	BASEMENT SYSTEMS PLAN - SEGMENT B
EY102A	FIRST FLOOR SYSTEMS PLAN - SEGMENT A
EY102B	FIRST FLOOR SYSTEMS PLAN - SEGMENT B
EY103	LOWER BALCONY SYSTEMS PLAN
EY104	UPPER BALCONY SYSTEMS PLAN
E-301	ELECTRICAL SECTIONS & ELEVATIONS
E-302	ELECTRICAL SECTIONS & ELEVATIONS
E-401	ELECTRICAL PART PLANS
E-501	ELECTRICAL DETAILS
E-502	ELECTRICAL DETAILS
E-601	LIGHTING CONTROL SCHEDULES
E-602	PANELBOARD SCHEDULES
E-603	PANELBOARD SCHEDULES
FA101A	BASEMENT FIRE ALARM PLAN - SEGMENT A
FA101B	BASEMENT FIRE ALARM PLAN - SEGMENT B
FA102A	FIRST FLOOR FIRE ALARM PLAN - SEGMENT A
FA102B	FIRST FLOOR FIRE ALARM PLAN - SEGMENT B
FA103	LOWER BALCONY FIRE ALARM PLAN
FA104	UPPER BALCONY FIRE ALARM PLAN


CONSULTANT DRAWINGS

FS001	FOOD SERVICE EQUIPMENT PLANS
FS002	FOOD SERVICE EQUIPMENT SCHEDULE
SP002	FIXED SEATING PLAN
DT01	FIXED SEATING DETAILS

ISSUED FOR BID
06 JUNE 2016

Signature	Date
Owner:	
Architect:	
Contractor:	

REV.	DESCRIPTION	DATE

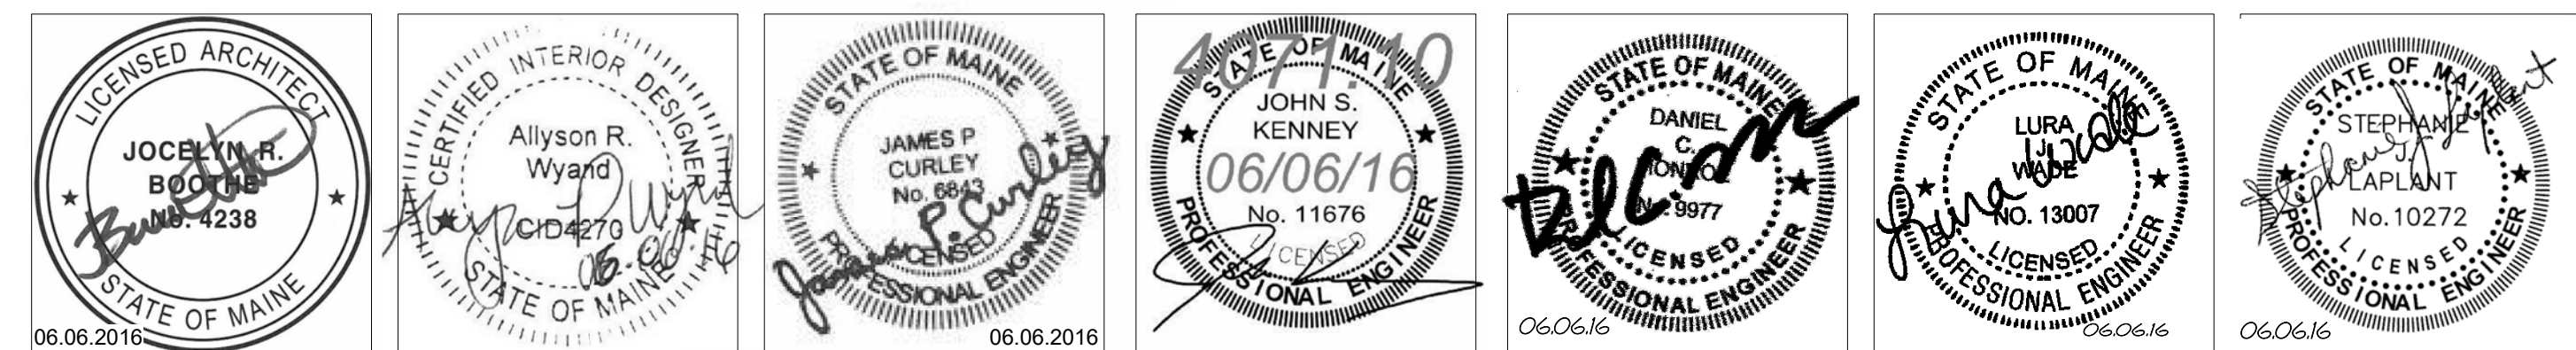

COMM No.
4071.10

SHEET No.
GI001



BANGOR, MAINE
(207) 947-4511
PORTLAND, MAINE
(207) 828-4511
SARASOTA, FLORIDA
(941) 556-0757
WWW.WBRCAE.COM