



TECHNICAL NOTES:

- ① ELECTRICAL SPACE - NO PIPING PERMITTED IN THIS AREA
- ② ELEVATOR SPACE - NO PIPING PERMITTED IN THIS AREA
- ③ SKYLIGHT - NO PIPING PERMITTED IN THIS AREA
- ④ EXISTING SUPPLY GRILLE TO REMAIN. CLEAN & RECONNECT TO NEW BRANCH DUCT.
- ⑤ EXISTING DUCTWORK TO REMAIN. CLEAN AND INSPECT DUCTWORK. COORDINATE WITH EXISTING CEILING TO REMAIN. PROVIDE NEW FLEX - DUCTS & DIFFUSERS.
- ⑥ HVAC CONTROL POWER, REFER TO ELECTRICAL DRAWINGS.
- ⑦ COORDINATE WITH DIV. 26 SYSTEMS CONTROLLER

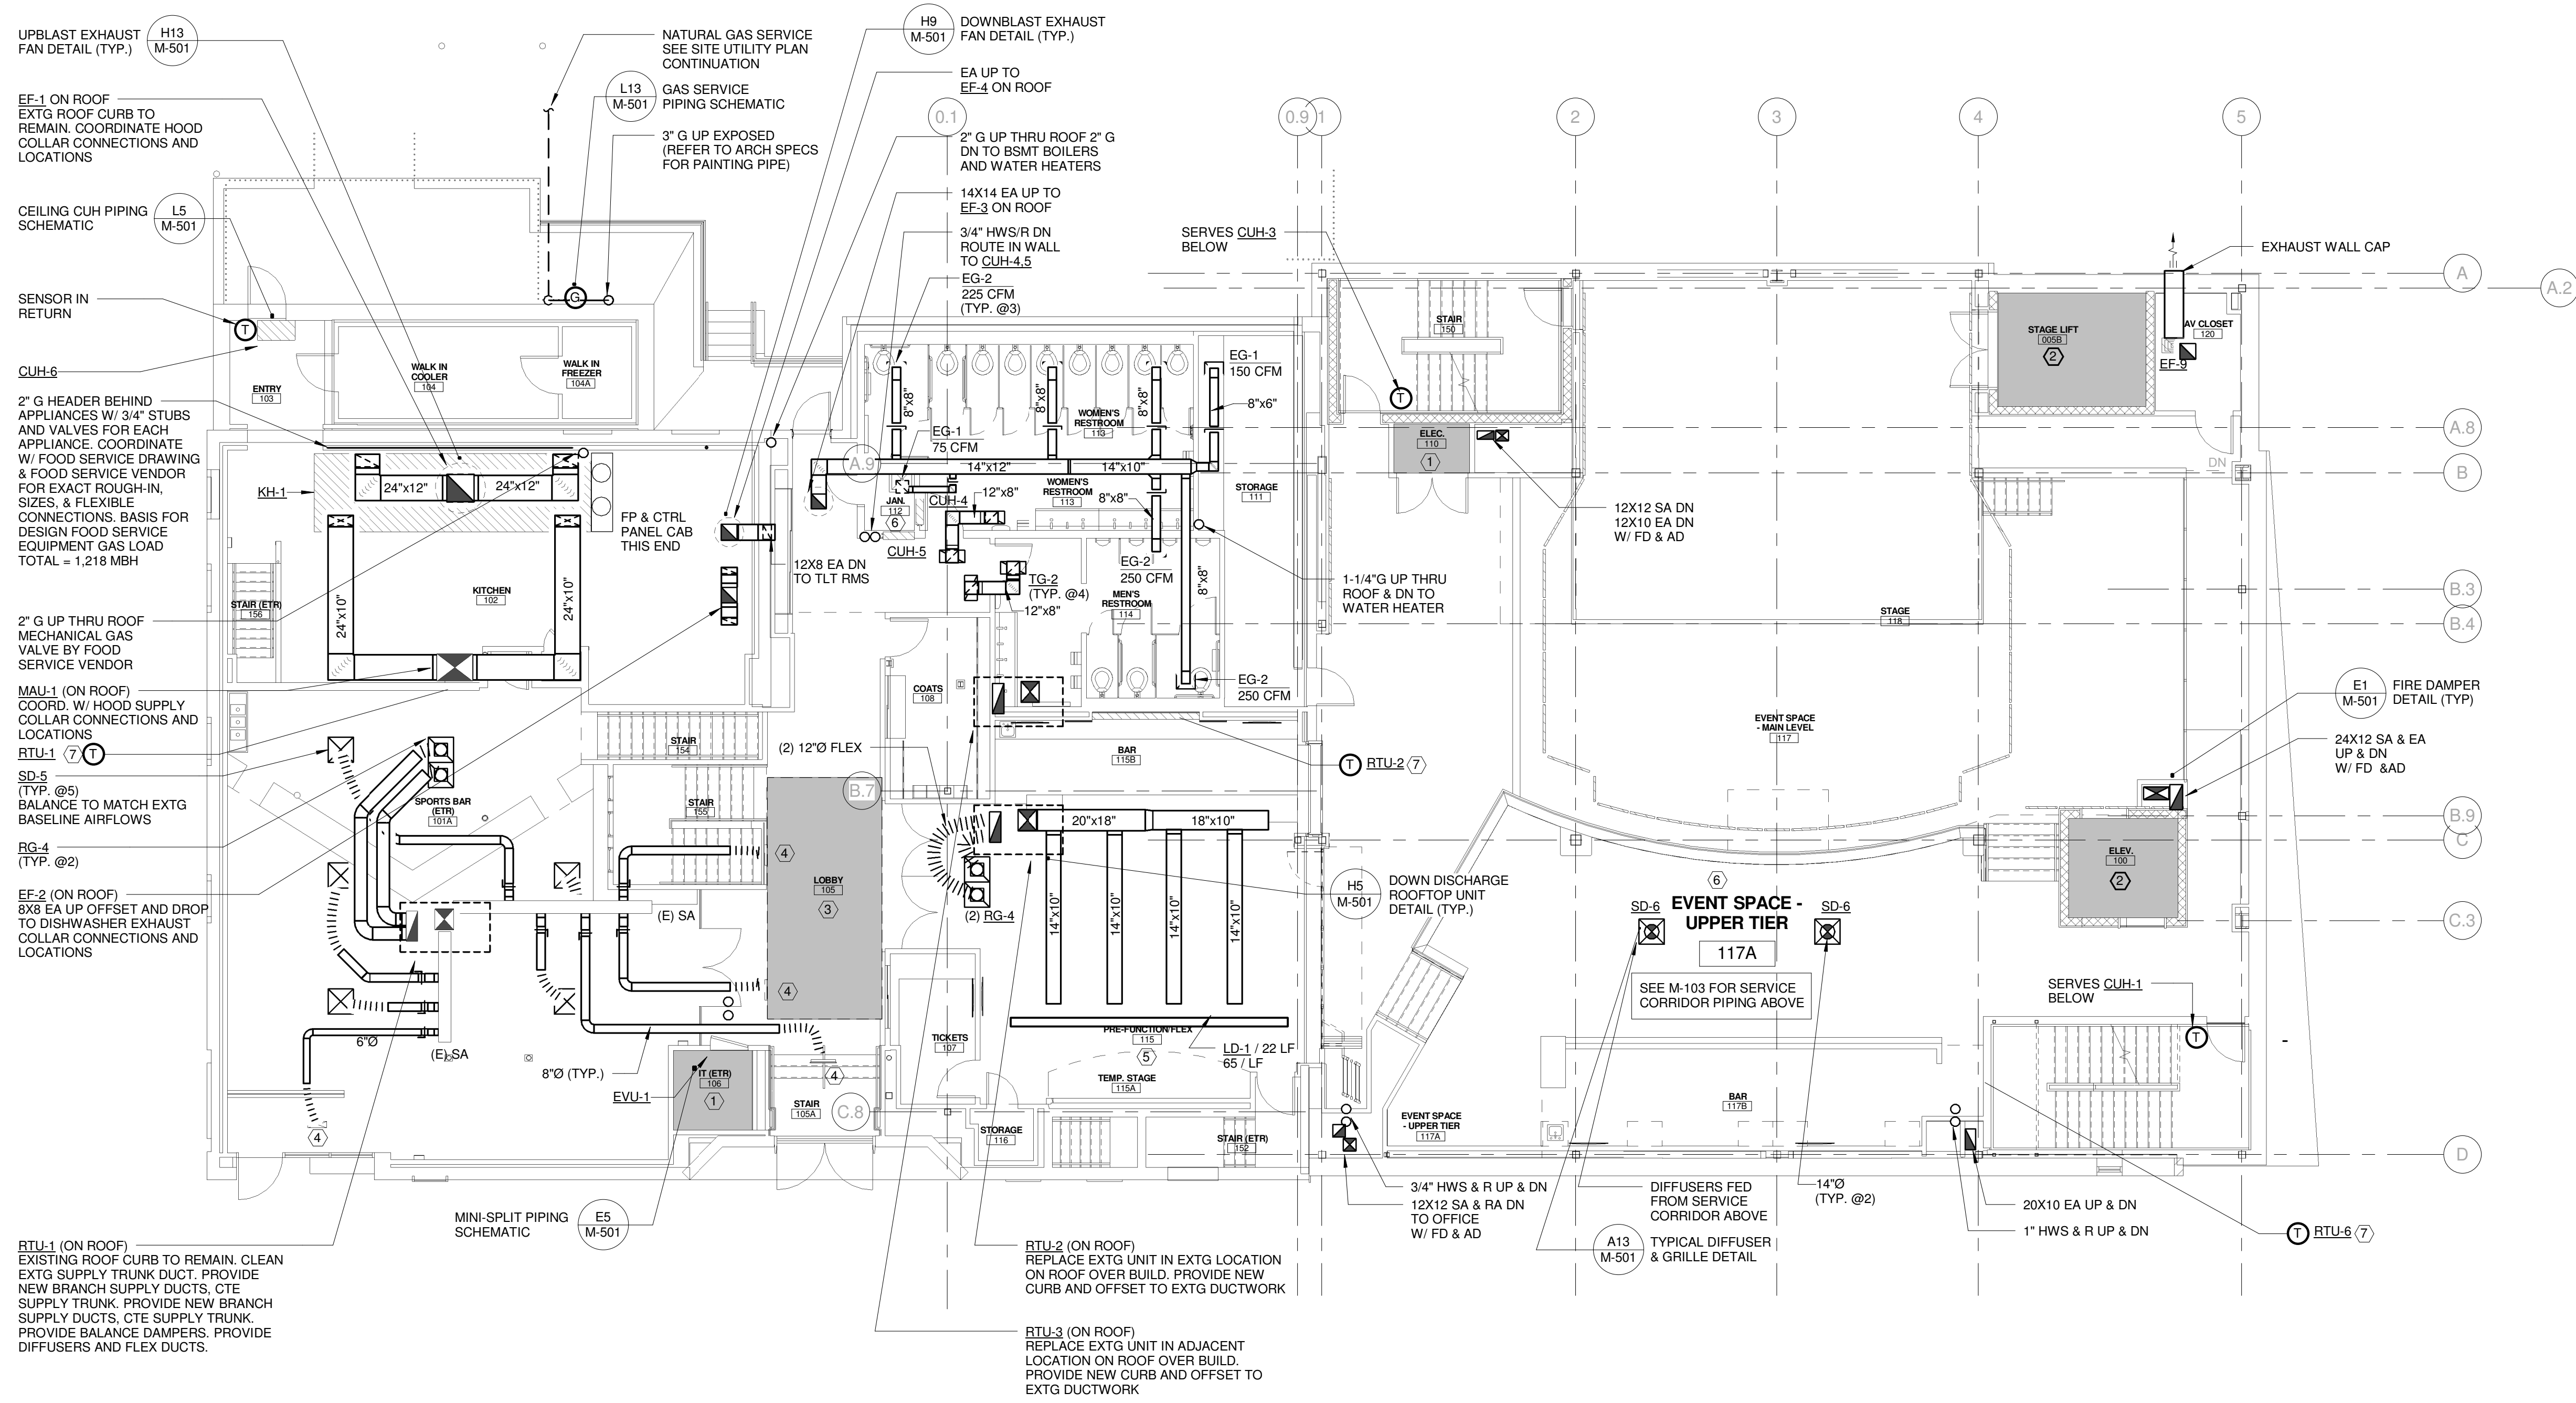

REV.	DESCRIPTION	DATE
0	ISSUED FOR BID	06 JUNE 2016

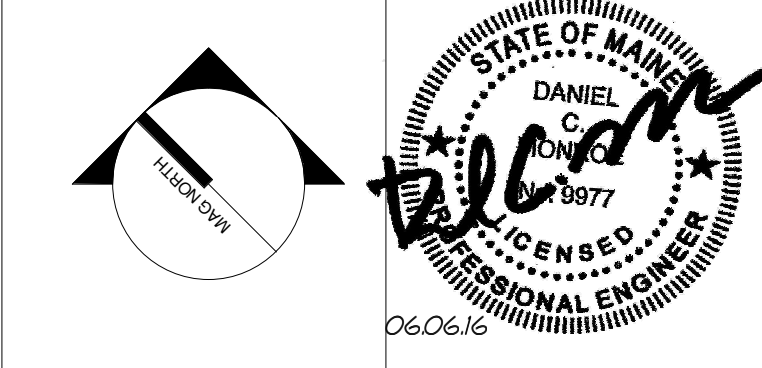

WBRC
ARCHITECTS ENGINEERS
WWW.WBRCAE.COM
BANGOR, MAINE 207-947-4511
PORTLAND, MAINE 207-828-4511
SARASOTA, FLORIDA 941-556-0757

ASYLUM
PROJECT:
FIRST FLOOR MECHANICAL PLAN

SHEET TITLE:

WBRC CAD FILE: 407110 - ASYLUM DANCE CLUB - MECH-INT

PROJECT No. 4071.10 GRAPHIC SCALE: 0" 1"

SCALE: 1/8" = 1'-0"

PROJECT MANAGER: JRB SHEET No. **M-102**

DRAWN BY: CGB

CHECKED BY: DMON

6/3/2016 4:14:38 PM C:\Users\courmey\Documents\407110 - ASYLUM DANCE CLUB - MECH_courmey\wbrc.rvt