



TECHNICAL NOTES:

- ① ELECTRICAL SPACE - NO PIPING PERMITTED IN THIS AREA
- ② ELEVATOR SPACE - NO PIPING PERMITTED IN THIS AREA
- ③ HVAC CONTROL POWER, REFER TO ELECTRICAL DRAWINGS.

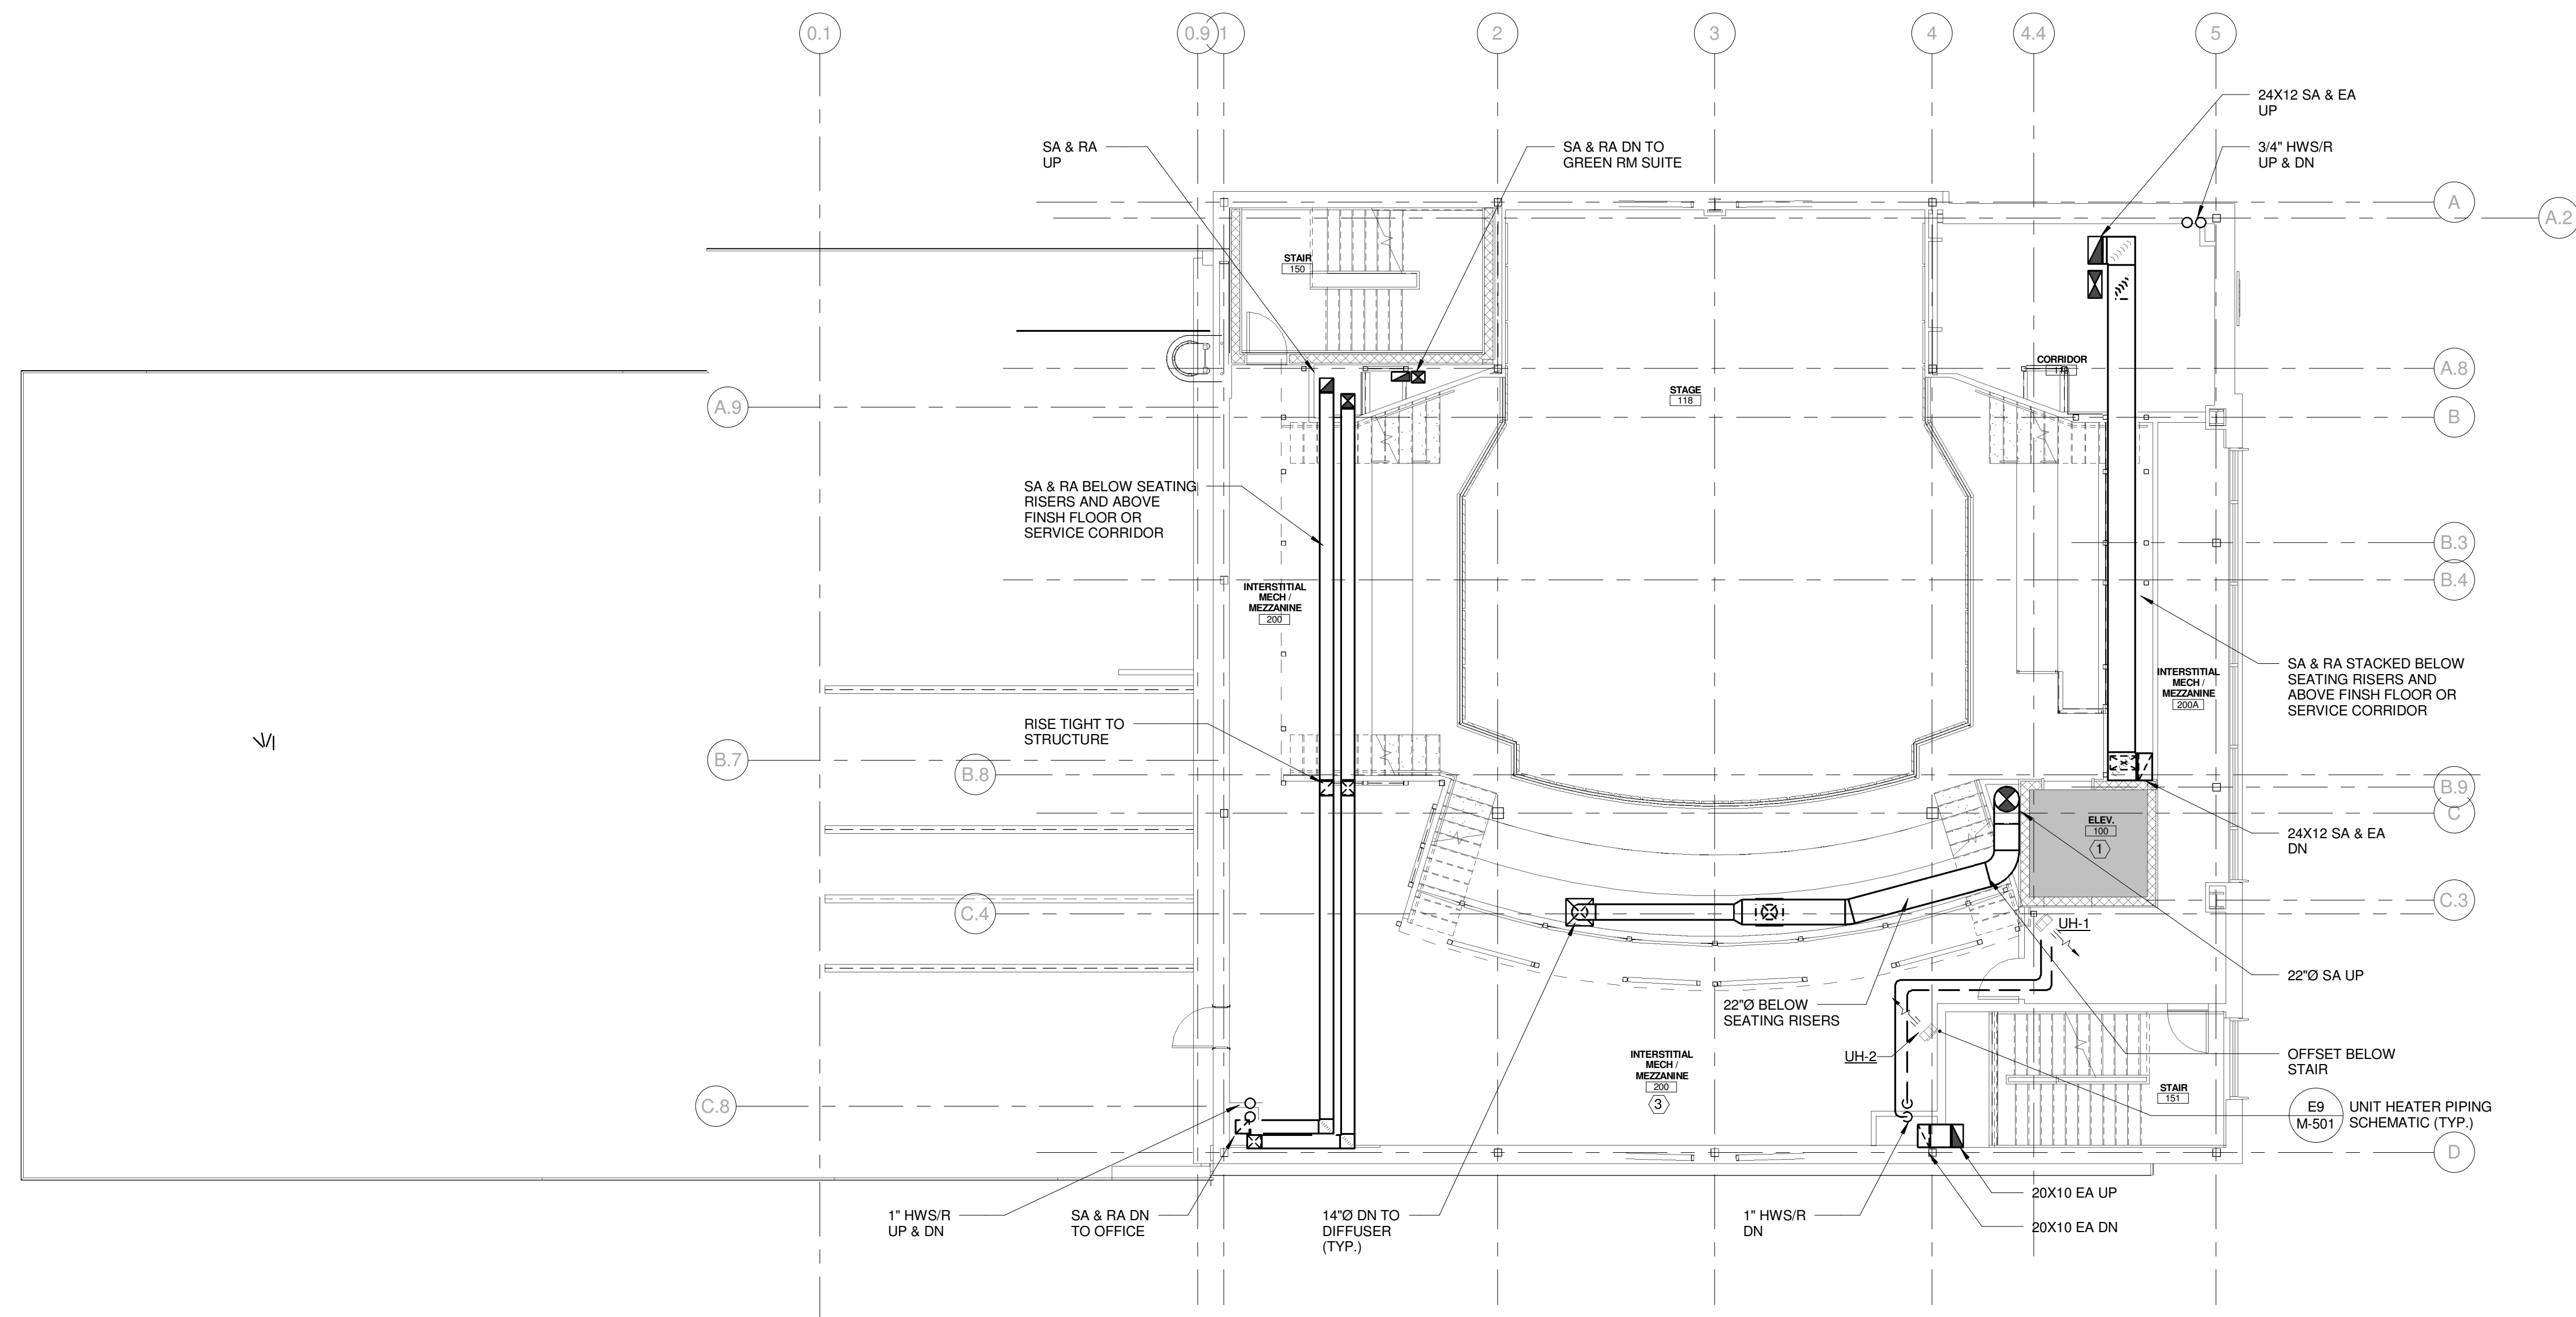

REV.	DESCRIPTION	DATE
0	ISSUED FOR BID	06 JUNE 2016

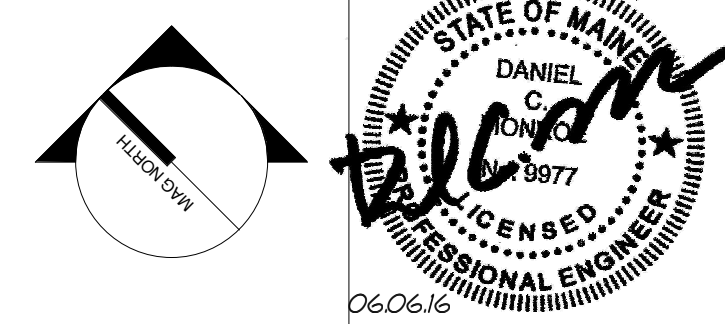

WBRC
 ARCHITECTS ENGINEERS
 WWW.WBRCAE.COM
 BANGOR, MAINE 207-947-4511
 PORTLAND, MAINE 207-428-4511
 SARASOTA, FLORIDA 941-556-0757

ASYLUM
 PROJECT:
BALCONY MECHANICAL PLAN

SHEET TITLE:	
WBRC CAD FILE: 407110 - ASYLUM DANCE CLUB - MECH-LRV1	GRAPHIC SCALE: 0" = 1"
PROJECT No. 4071.10	SCALE: 1/8" = 1'-0"
PROJECT MANAGER: JRB	SHEET No. M-103
DRAWN BY: CGB	CHECKED BY: DMON

A1 BALCONY MECHANICAL PLAN
 1/8" = 1'-0"

6/3/2016 4:14:49 PM
 C:\Users\courmey\Documents\407110 - ASYLUM DANCE CLUB - MECH_courmey\bunker.rvt