

TECHNICAL NOTES:

① EXISTING BASEMENT AREA TO REMAIN AS IS

REMOVE EXTG HOOD EXHAUST FAN AND ALL DUCTWORK & DIFFUSERS IN EXTG KITCHEN

REMOVE EXTG TOILET EXHAUST

EXTG STAR CEILING TO REMAIN REFER TO ARCH. PLANS. ALL EXISTING DUCTS TO REMAIN IN THIS AREA. REMOVE & REPLACE ALL DIFFUSERS IN THIS AREA

REMOVE ALL EXISTING DUCTWORK, FLEX BRANCHES AND DIFFUSERS THIS AREA

REMOVE EXTG BRANCH DUCTS, FLEX DUCTS, DIFFUSERS AND GRILLES IN EXTG SPORTS. EXTG SUPPLY & RETURN DUCT TRUNKS TO REMAIN AND DUCTS UP THRU EXTG ROOF TO REMAIN

EXTG SUPPLY GRILLES IN SOFFIT TO REMAIN (TYP. @3)

G1 FIRST FLOOR MECHANICAL DEMO PLAN

1/8" = 1'-0"

REMOVE EXISTING NATURAL GAS FIRED BOILER SERVING WATER HEATER

REMOVE EXISTING INDIRECT FIRED WATER HEATER. 115 GAL SERVES KITCHEN

REMOVE ALL EXISTING DUCTWORK UP TO EXISTING ROOFTOP UNIT

REMOVE EXISTING ELECTRIC UNIT HEATER

REMOVE ALL EXISTING DUCTWORK, FLEX BRANCHES AND DIFFUSERS THIS AREA

REMOVE EXISTING ELECTRIC UNIT HEATER

REMOVE EXISTING NATURAL GAS TO KITCHEN & BOILER & RISER TO ROOF


REMOVE EXISTING UNDERGROUND NATURAL GAS - SEE SITE UTILITY PLANS

REMOVE EXISTING ELECTRIC UNIT HEATER

A1 BASEMENT MECHANICAL DEMO PLAN

1/8" = 1'-0"

REV.	DESCRIPTION	DATE
0	ISSUED FOR BID	06 JUNE 2016

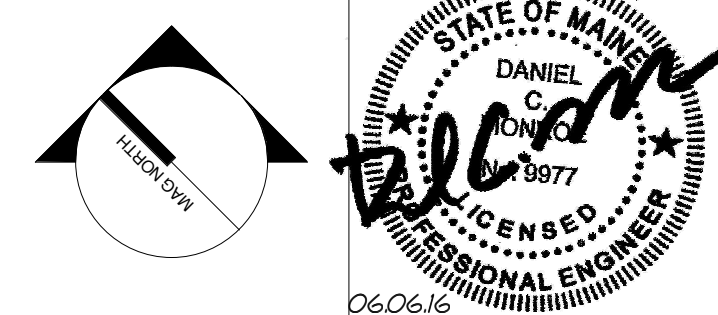

WBRC
ARCHITECTS ENGINEERS
WWW.WBRCAE.COM
BANGOR, MAINE 207-947-4511
PORTLAND, MAINE 207-828-4511
SARASOTA, FLORIDA 941-556-0757

ASYLUM
PROJECT:
BASEMENT & FIRST FLOOR REMOVALS PLAN

SHEET TITLE:

WBRC CAD FILE: 407110 - ASYLUM DANCE CLUB - MECH - RVT

PROJECT No. 4071.10 GRAPHIC SCALE: 0" 1"

SCALE: 1/8" = 1'-0"

PROJECT MANAGER: JRB SHEET No. MD101

DRAWN BY: OGB

CHECKED BY: DMON

6/3/2016 4:15:46 PM C:\Users\courmey\Documents\407110 - ASYLUM DANCE CLUB - MECH_courmey\dwg\k1.rvt