



**TECHNICAL NOTES:**

- ① ELECTRICAL SPACE - NO PIPING PERMITTED IN THIS AREA
- ② ELEVATOR SPACE - NO PIPING PERMITTED IN THIS AREA
- ③ EXISTING BASEMENT AREA TO REMAIN AS IS
- ④ HVAC CONTROL POWER, REFER TO ELECTRICAL DRAWINGS
- ⑤ REPLACE EXISTING DIFFUSERS AND GRILLES IN THIS AREA. PROVIDE NEW BRANCH DUCTS AND RECONNECT TO REPLACEMENT RTU-3. COORDINATE WITH PHASING PLAN G106 AND PROVIDE TEMPORARY DUCTS AS NECESSARY.

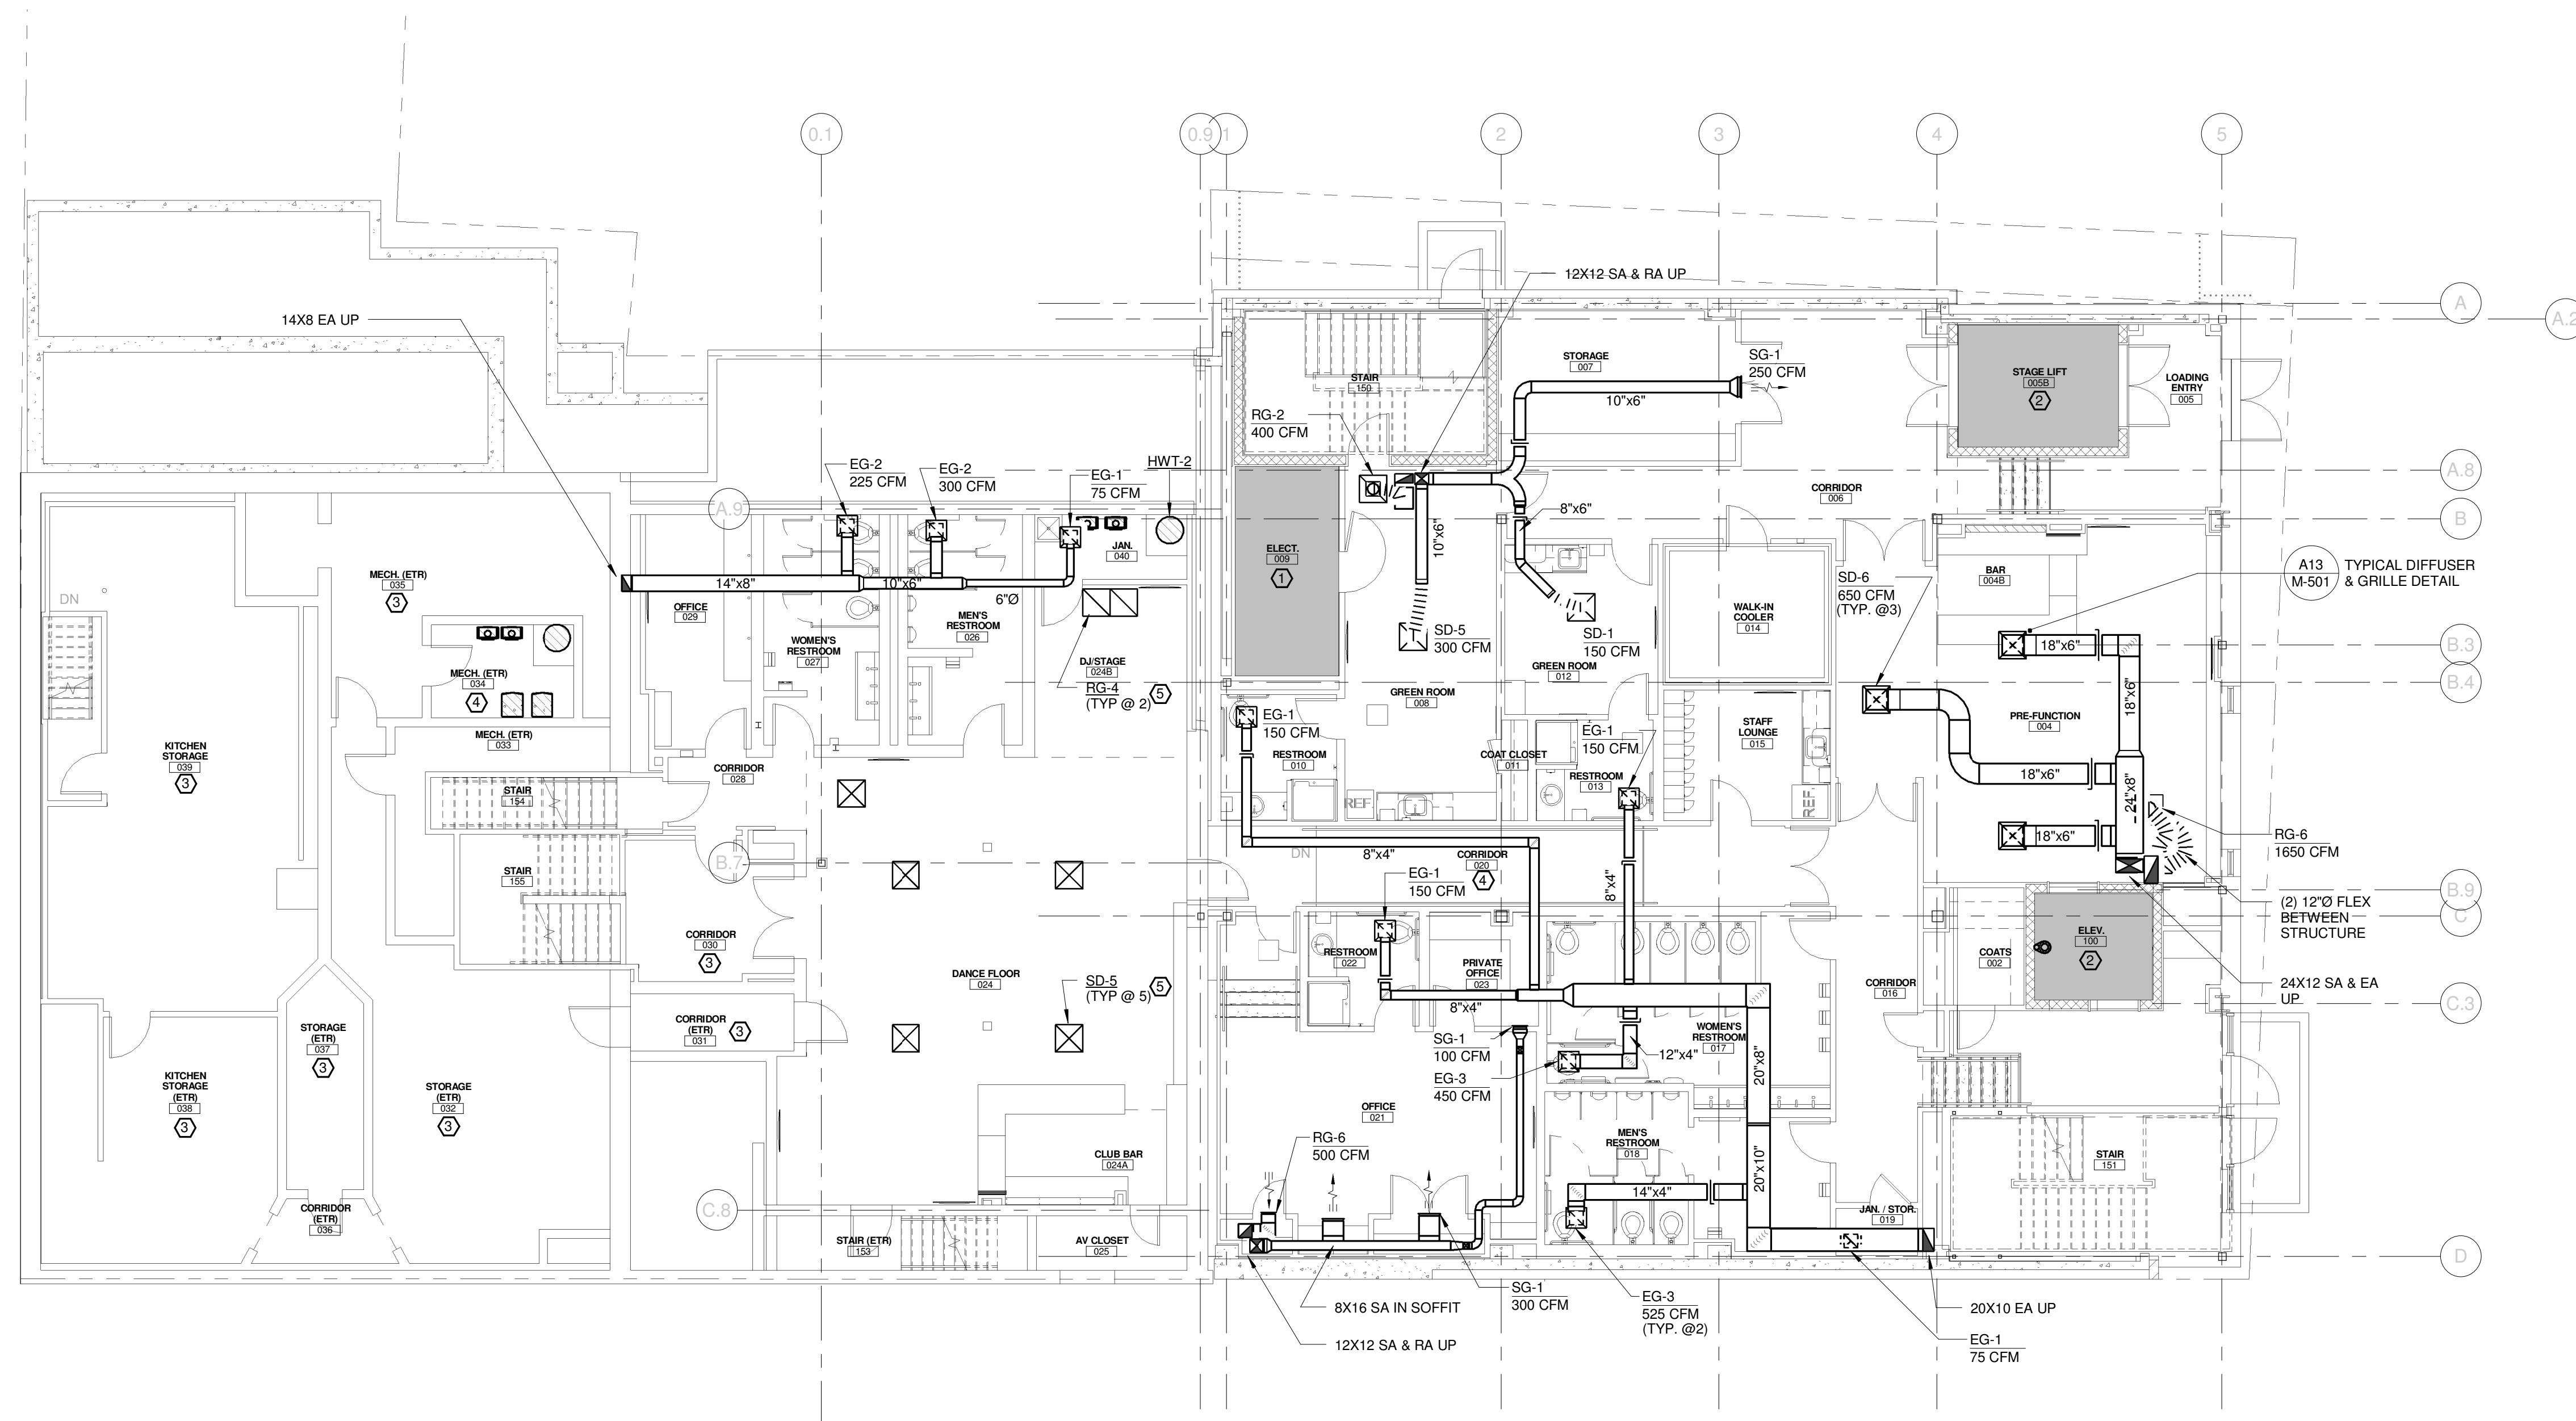

REV.	DESCRIPTION	DATE
0	ISSUED FOR BID	06 JUNE 2016

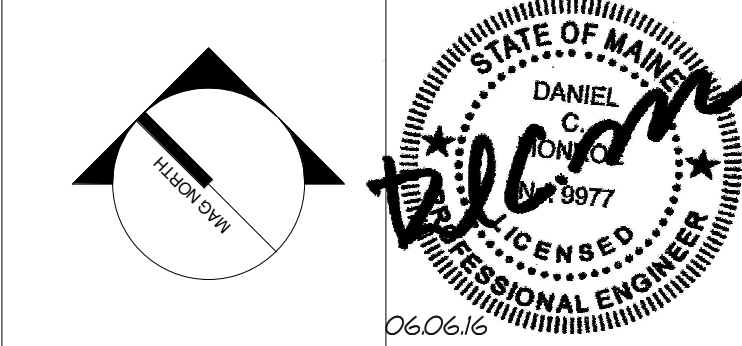

**WBRC**  
ARCHITECTS ENGINEERS  
WWW.WBRCAE.COM  
BANGOR, MAINE 207-947-4511  
PORTLAND, MAINE 207-828-4511  
SARASOTA, FLORIDA 941-556-0757

**ASYLUM**

**BASEMENT MECHANICAL DUCTWORK PLAN**

SHEET TITLE:

WBRC CAD FILE: 407110 - ASYLUM DANCE CLUB - MECH-LRV1

PROJECT No. 4071.10 GRAPHIC SCALE: 0" 1"

SCALE: 1/8" = 1'-0"

PROJECT MANAGER: JRB SHEET No. MH101

DRAWN BY: CGB

CHECKED BY: DMON

6/3/2016 4:22:39 PM C:\Users\courney.bunker\Documents\407110 - ASYLUM DANCE CLUB - MECH\_courney.bunker.rvt