



TECHNICAL NOTES:

- ① ELECTRICAL SPACE - NO PIPING PERMITTED IN THIS AREA
- ② ELEVATOR SPACE - NO PIPING PERMITTED IN THIS AREA
- ③ COORDIANTE WITH DIV. 26 SYSTEMS CONTROLLER

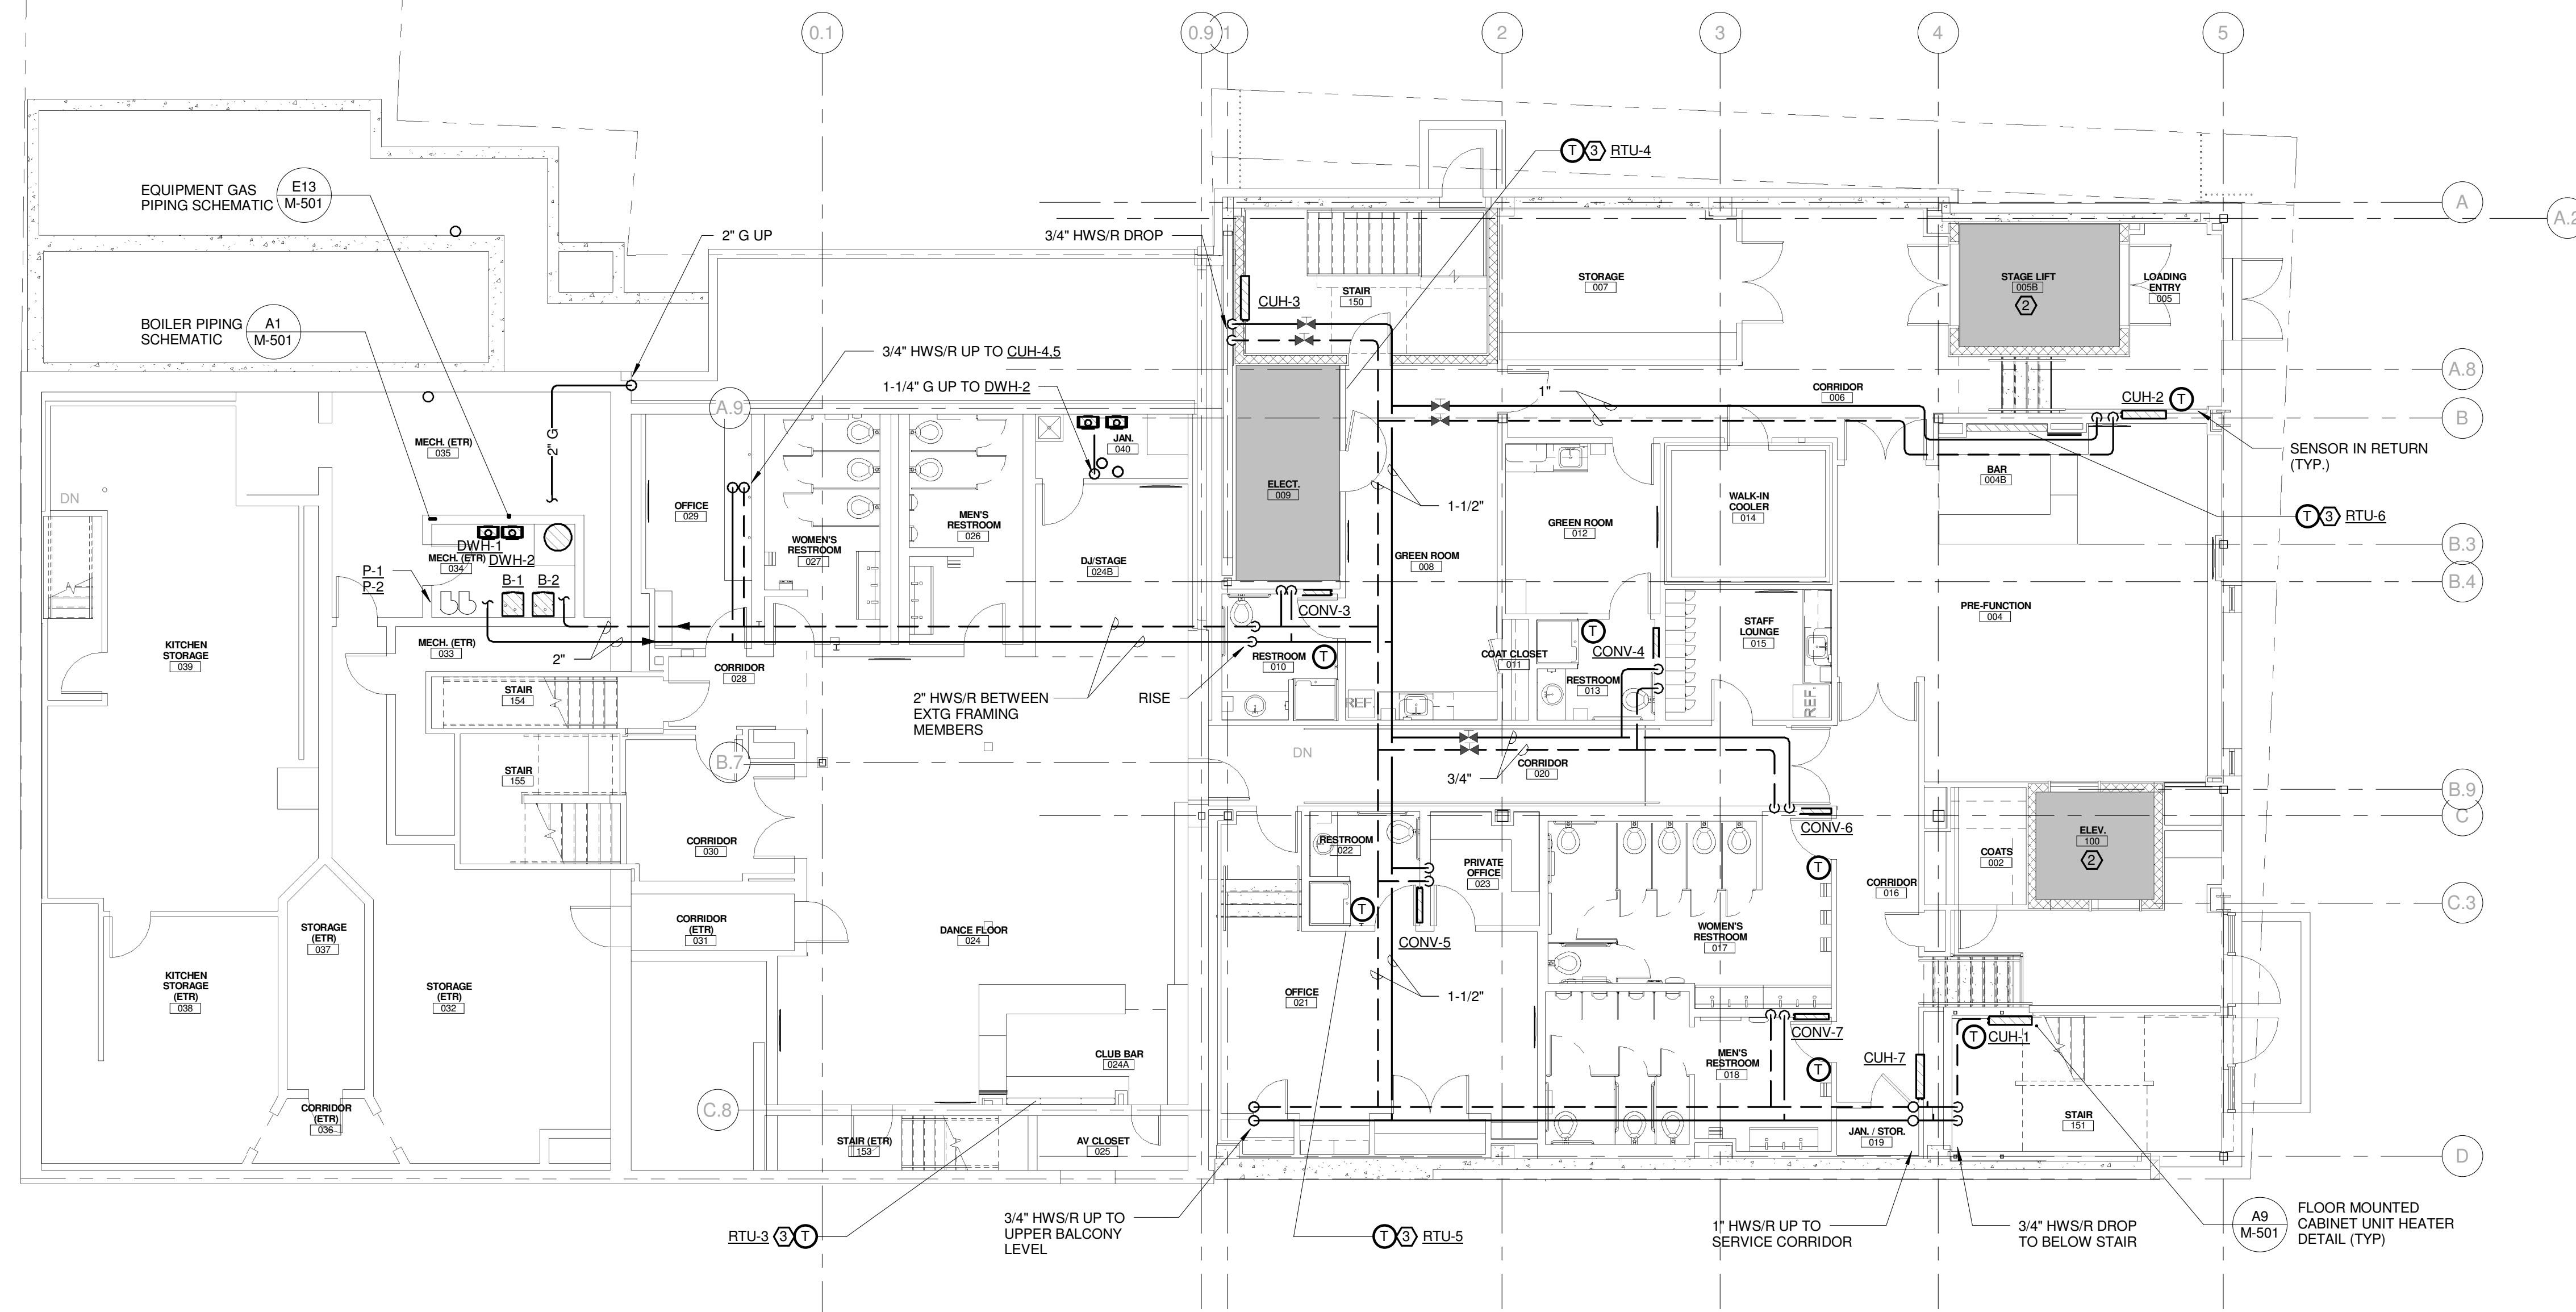

REV.	DESCRIPTION	DATE
0	ISSUED FOR BID	06 JUNE 2016

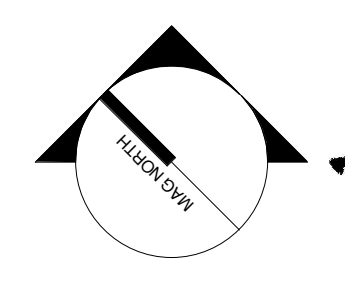

WBRC
ARCHITECTS ENGINEERS
WWW.WBRCAE.COM
BANGOR, MAINE 207-947-4511
PORTLAND, MAINE 207-428-4511
SARASOTA, FLORIDA 941-556-0757

ASYLUM
PROJECT:
BASEMENT MECHANICAL PIPING PLAN

SHEET TITLE:

WBRC CAD FILE: 407110 - ASYLUM DANCE CLUB - MECH-LRV1	GRAPHIC SCALE: 0" = 1"
PROJECT No. 4071.10	SCALE: 1/8" = 1'-0"
PROJECT MANAGER: JRB	SHEET No. MP101
DRAWN BY: CGB	CHECKED BY: DMON

6/3/2016 4:16:21 PM C:\Users\courmey\Documents\407110 - ASYLUM DANCE CLUB - MECH_courmey\bkur.rvt