


TECHNICAL NOTES:


Ⓢ ELECTRICAL SPACE - NO PIPING PERMITTED IN THIS AREA

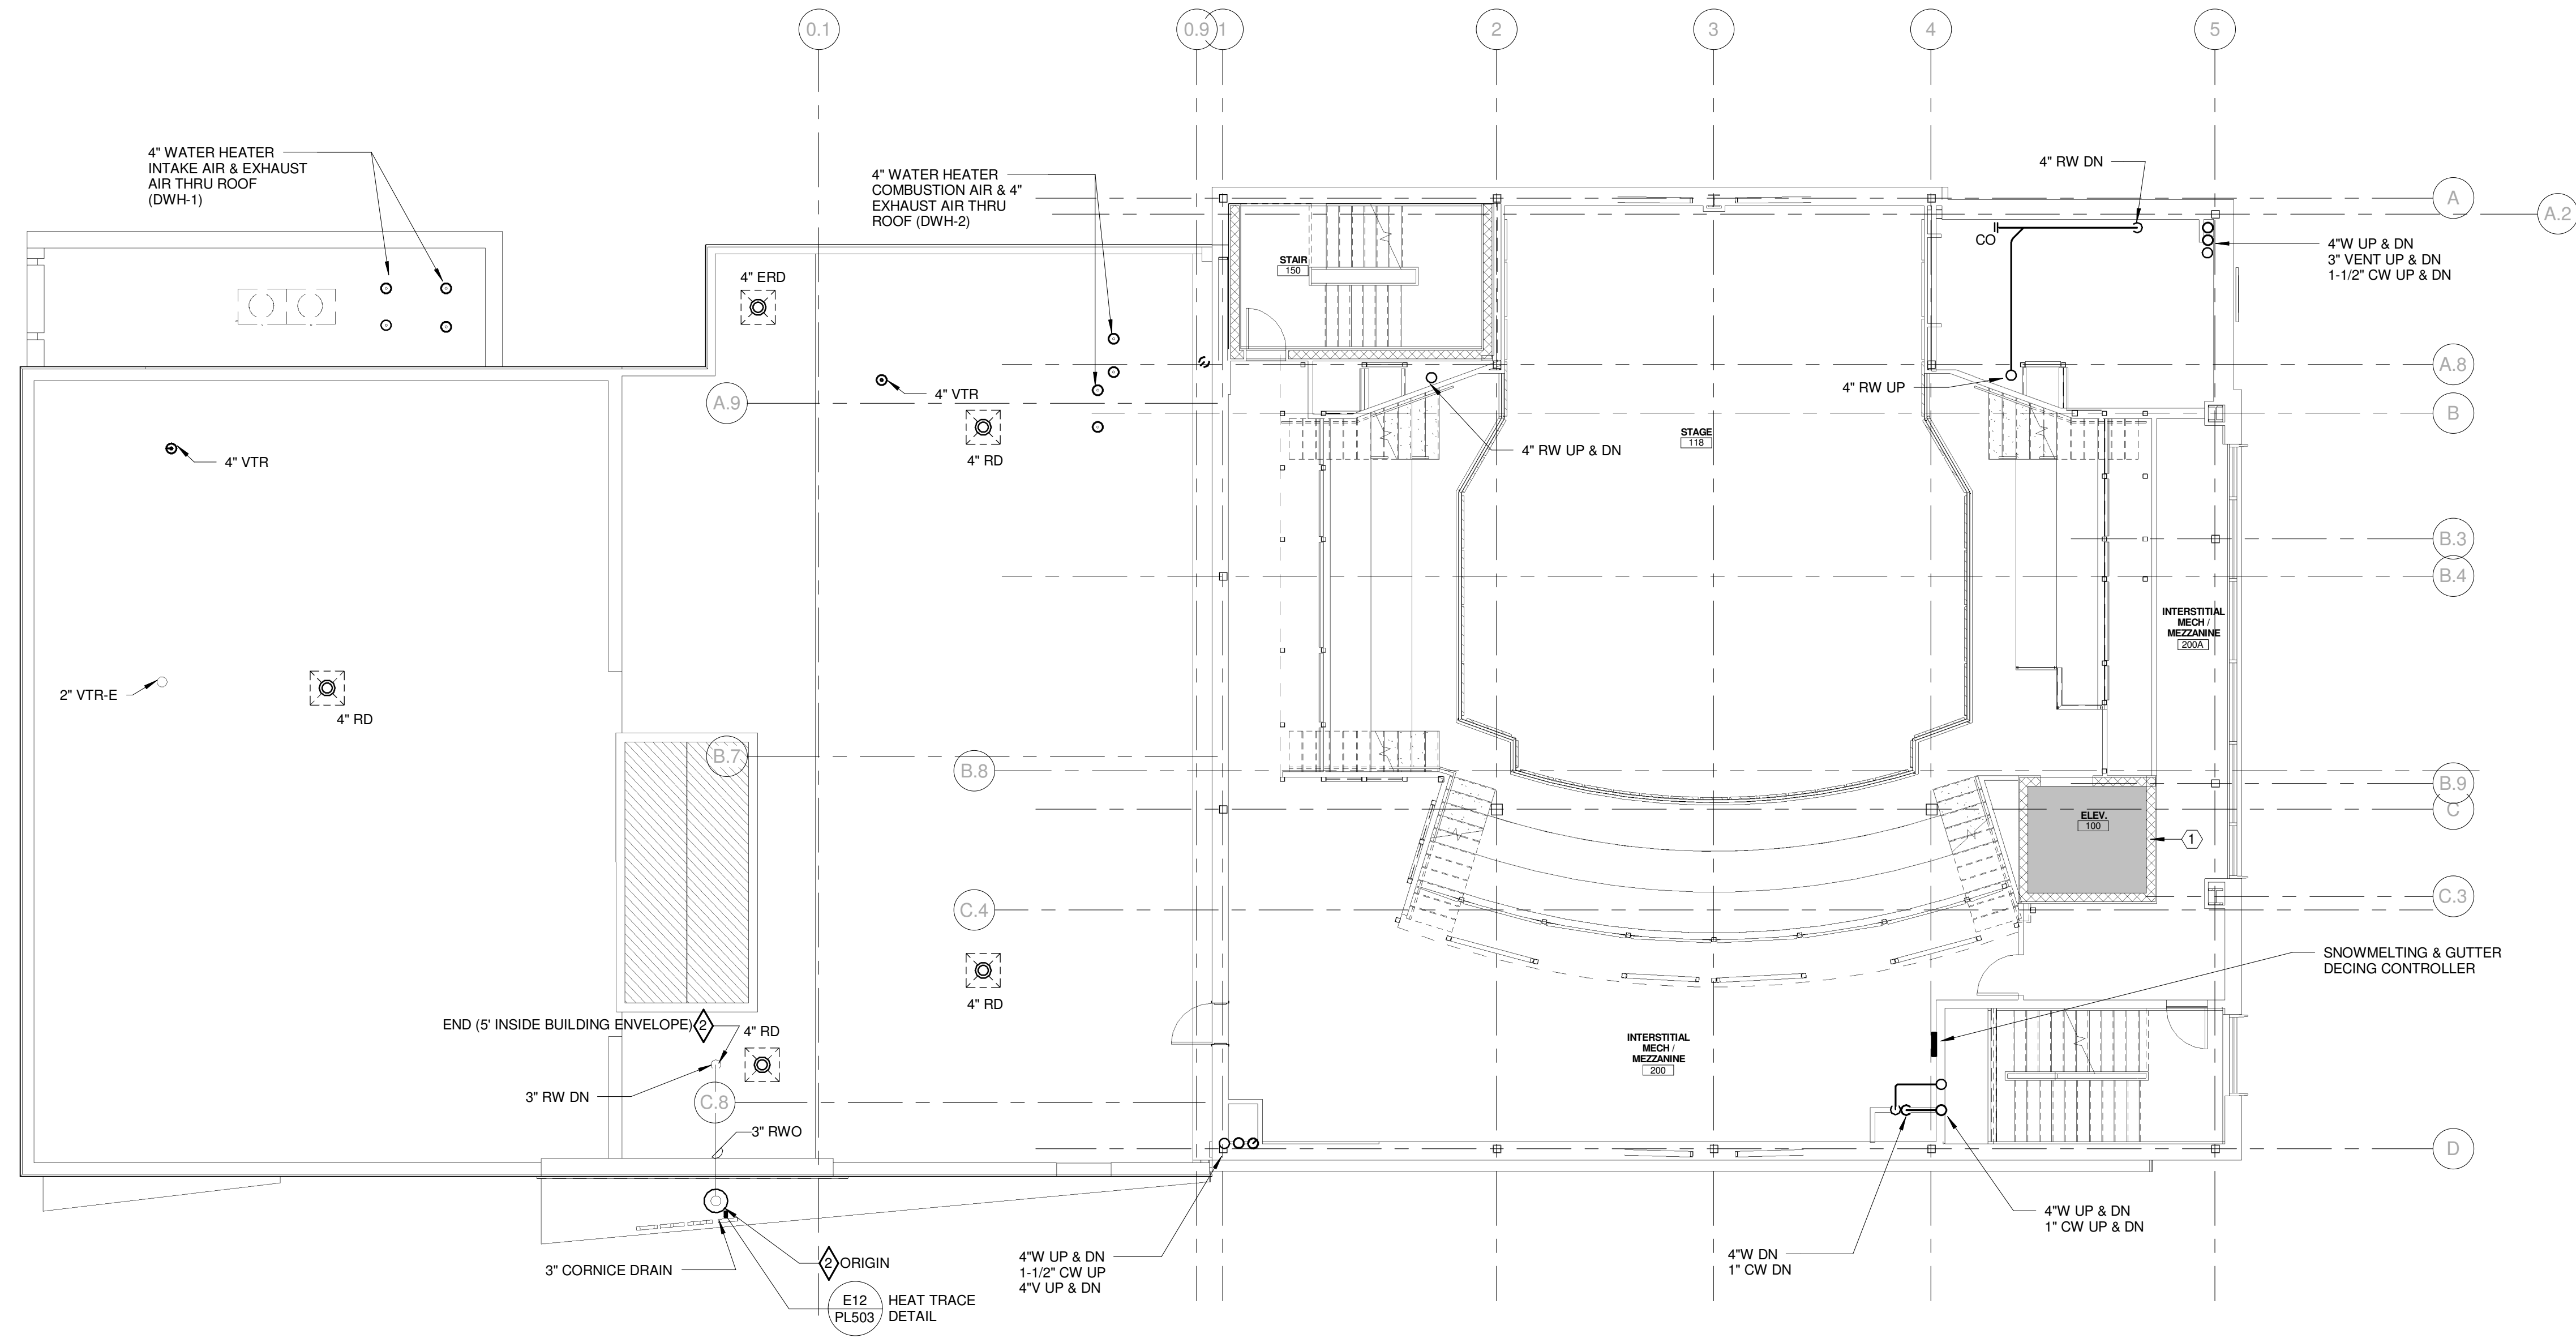

NOTE:
PRIOR TO COMMENCEMENT OF ANY WORK, CONTRACTOR SHALL REVIEW OWNERS ASBESTOS CONTAINING MATERIALS (ACM) REPORT FOR EXTG ROOF SYSTEMS, PIPING SYSTEMS, AND OTHER SUSPICIOUS MATERIALS. COORDINATE REMOVAL AND DISPOSAL OF ALL ACM'S WITH GENERAL CONTRACTOR.

- GENERAL NOTES**
1. RAINWATER PIPING SIZED FOR 1/8" FT MIN. PITCH.
 2. SANITARY DWV PIPING SIZED FOR 1/4" FT MIN PITCH.
 3. EXTG BUILDING STRUCTURE, RAINWATER & SEWER ARE COMBINED SYSTEMS PER CITY OF PORTLAND. RAINWATER & SEWER ARE SEPERATE SYSTEMS AT NEW BUILDING ADDITION.

REV.	DESCRIPTION	DATE
0	ISSUED FOR BID	06 JUNE 2016

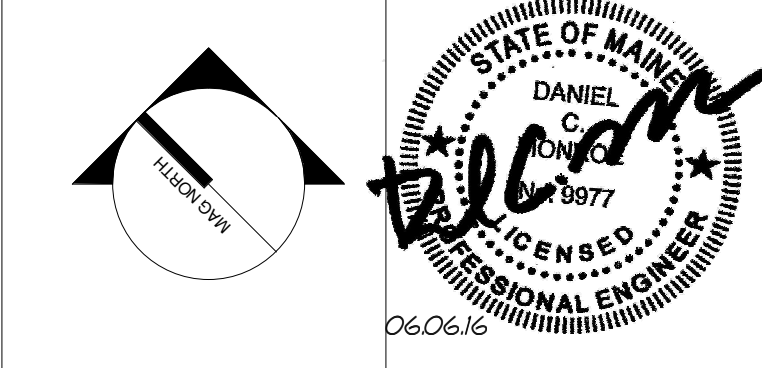

WBRC ARCHITECTS ENGINEERS
 WWW.WBRCAE.COM
 BANGOR, MAINE 207-947-4511
 PORTLAND, MAINE 207-428-4511
 SARASOTA, FLORIDA 941-556-0757

PROJECT: **ASYLUM**

SHEET TITLE: **BALCONY AND ROOF PLUMBING PLAN**

WBRC CAD FILE: 407110 - ASYLUM DANCE CLUB - MECH_LRVT	GRAPHIC SCALE: 0" = 1"
PROJECT No. 4071.10	SCALE: 1/8" = 1'-0"
PROJECT MANAGER: JRB	SHEET No. PL103
DRAWN BY: CGB	CHECKED BY: DMON

6/3/2016 4:54:33 PM C:\Users\courmey\my\Documents\407110 - ASYLUM DANCE CLUB - MECH_LRVT\courmey\bunker.rvt