


TECHNICAL NOTES:


Ⓛ ELECTRICAL SPACE - NO PIPING PERMITTED IN THIS AREA

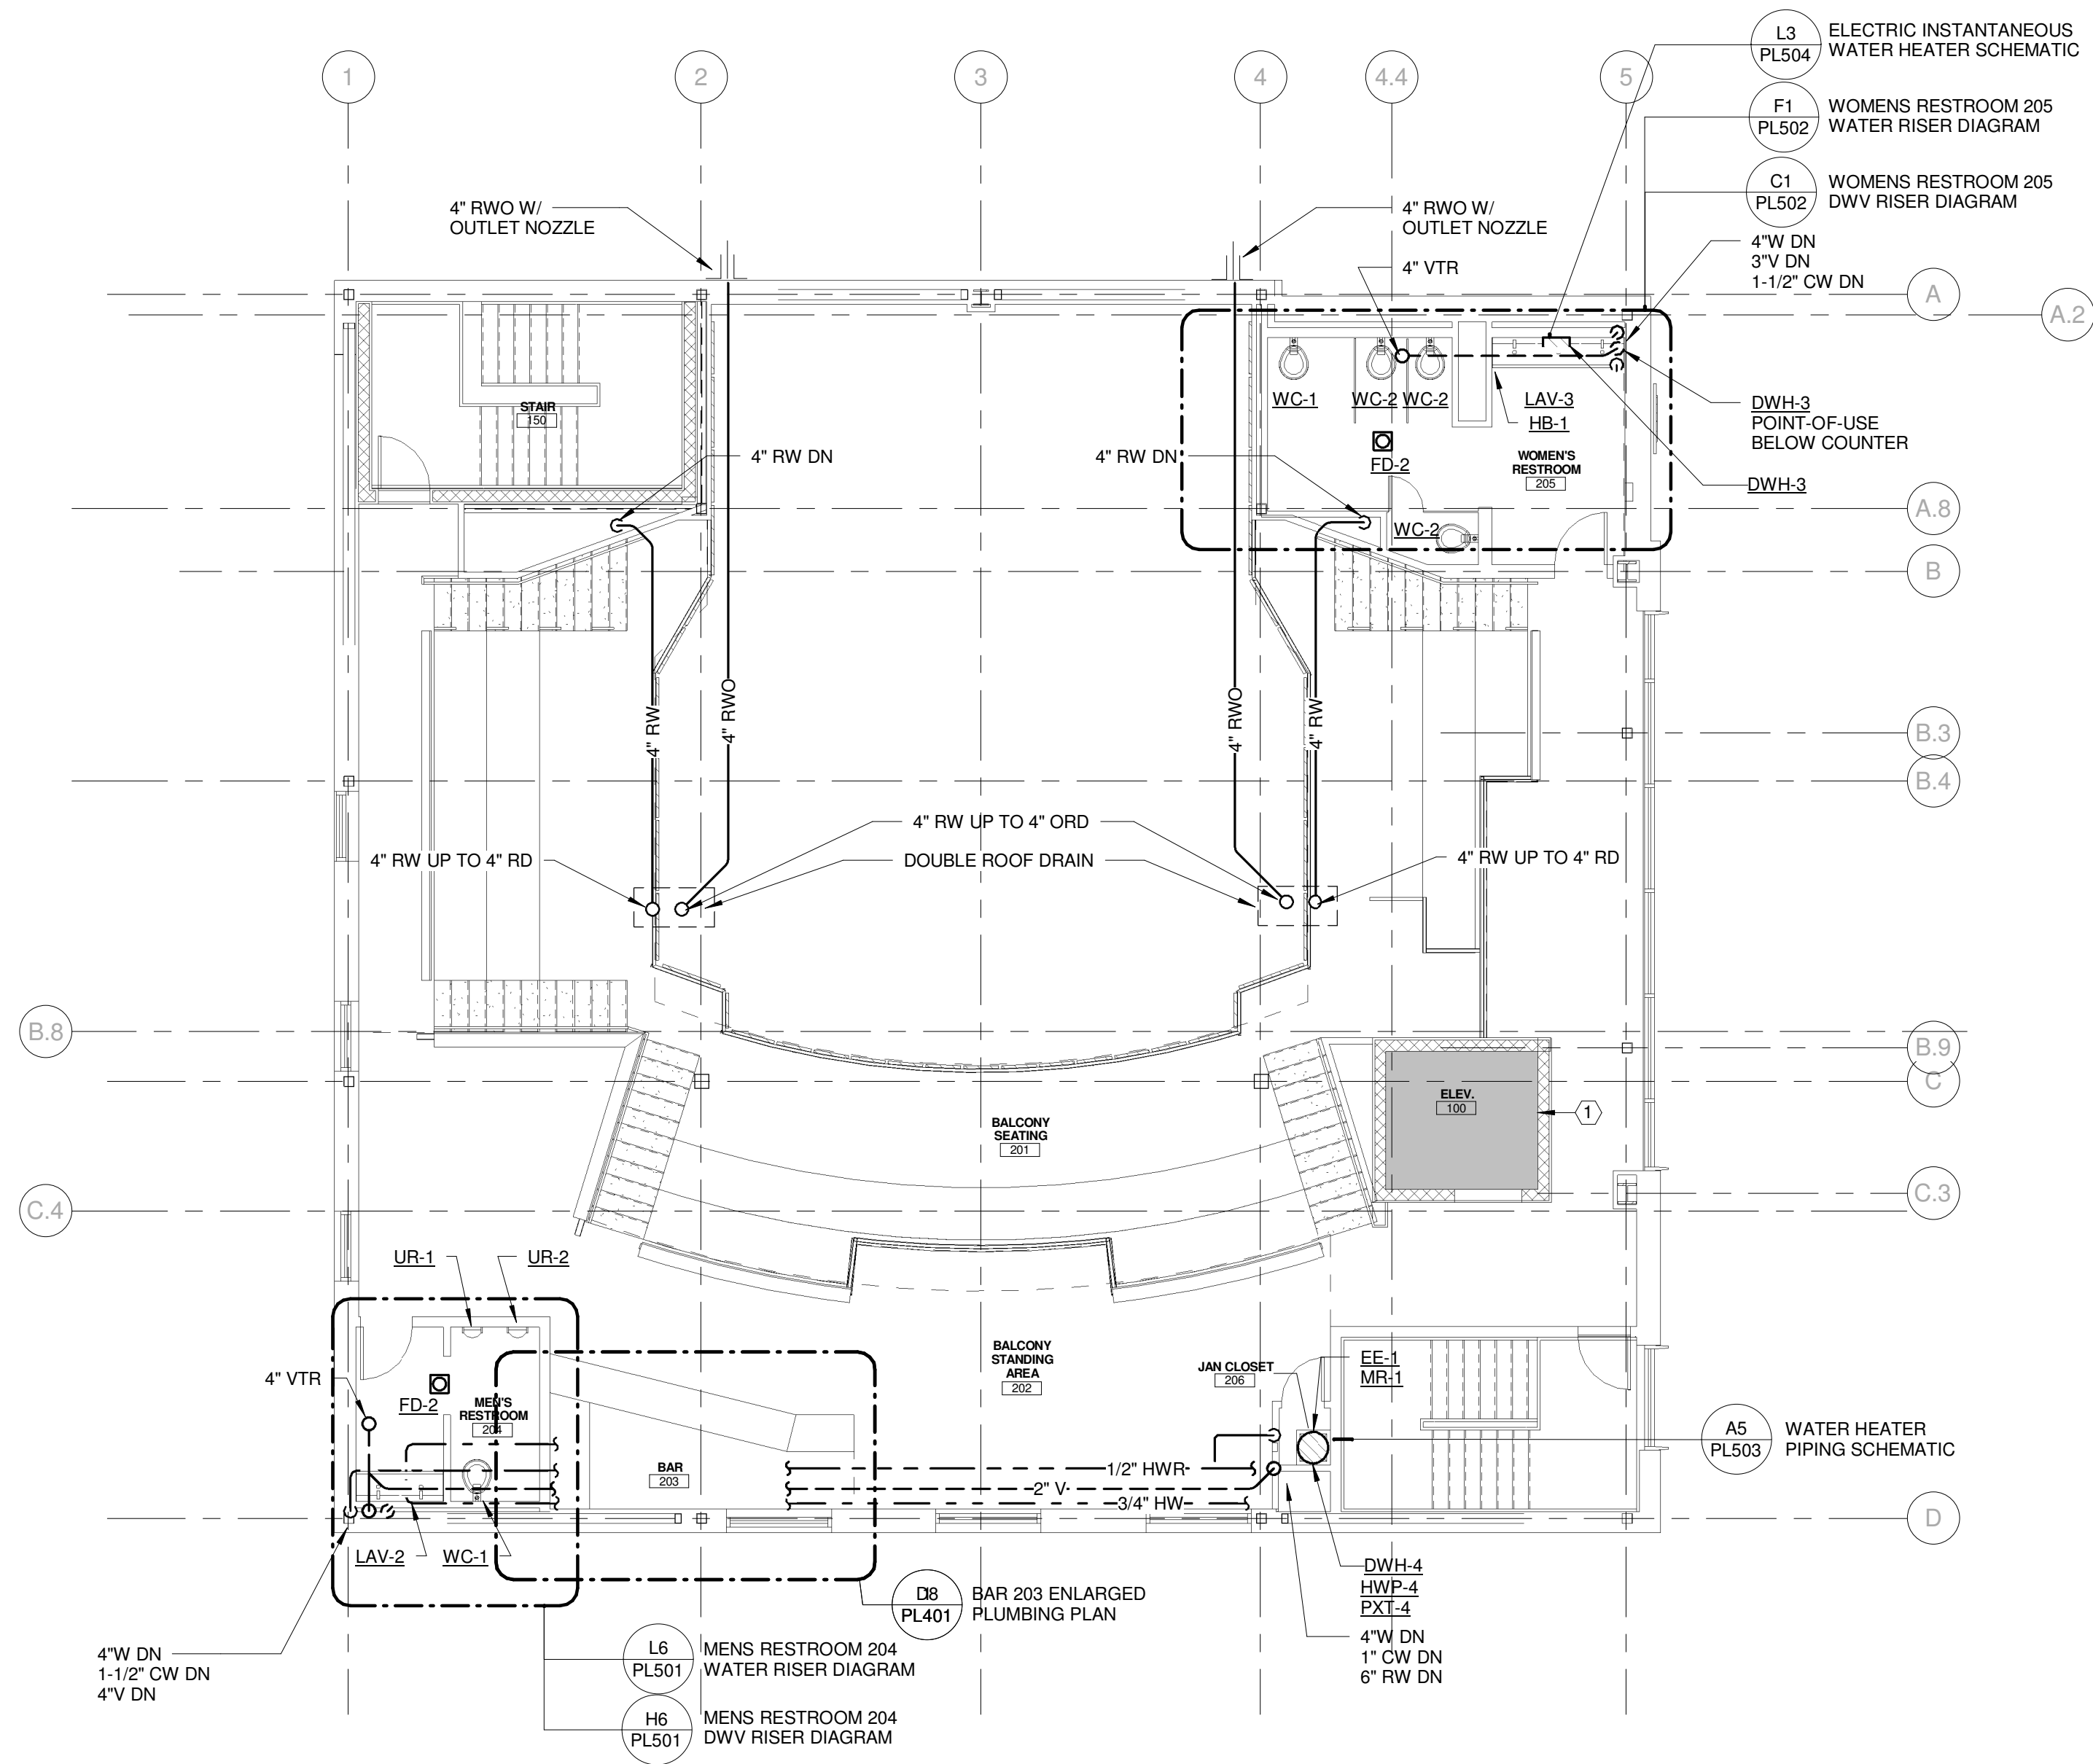

NOTE:
PRIOR TO COMMENCEMENT OF ANY WORK, CONTRACTOR SHALL REVIEW OWNERS ASBESTOS CONTAINING MATERIALS (ACM) REPORT FOR EXTG ROOF SYSTEMS, PIPING SYSTEMS, AND OTHER SUSPICIOUS MATERIALS. COORDINATE REMOVAL AND DISPOSAL OF ALL ACM'S WITH GENERAL CONTRACTOR.

- GENERAL NOTES
1. RAINWATER PIPING SIZED FOR 1/8" FT MIN. PITCH.
 2. SANITARY DWV PIPING SIZED FOR 1/4" FT MIN PITCH.
 3. EXTG BUILDING STRUCTURE, RAINWATER & SEWER ARE COMBINED SYSTEMS PER CITY OF PORTLAND. RAINWATER & SEWER ARE SEPERATE SYSTEMS AT NEW BUILDING ADDITION.

REV.	DESCRIPTION	DATE
0	ISSUED FOR BID	06 JUNE 2016

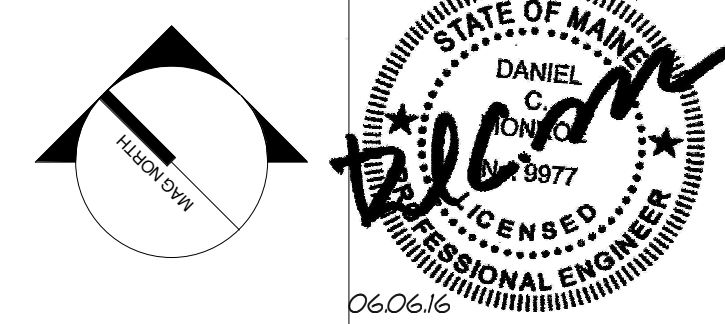

WBRC
ARCHITECTS ENGINEERS
WWW.WBRCAE.COM
BANGOR, MAINE 207-947-4511
PORTLAND, MAINE 207-828-4511
SARASOTA, FLORIDA 941-556-0757

PROJECT:
ASYLUM
UPPER BALCONY PLUMBING PLAN

SHEET TITLE:
WBRC CAD FILE: 407110 - ASYLUM DANCE CLUB - MECH.LVT
PROJECT No. 4071.10 GRAPHIC SCALE: 0" 1"
SCALE: 1/8" = 1'-0"
PROJECT MANAGER: JRB SHEET No. PL104
DRAWN BY: OGB
CHECKED BY: DMON

6/3/2016 4:20:06 PM C:\Users\courmey\Bunker Documents\407110 - ASYLUM DANCE CLUB - MECH_courmey\bunker.rvt