



- NOTES:**
1. ALL WIRING, CONDUIT & DEVICES TO BE CONCEALED.
 2. BURNER SERVICE SWITCH: SHALL BE WALL RECESSED 120V, SINGLE GANG, SINGLE POLE, 15-AMP GROUNDING, UL LISTED, TOGGLE SWITCH, TOGGLE SWITCH, IN BACK BOX, IN WHITE FINISH. COVER PLATE SHALL BE SINGLE GANG, LABELED "EMERGENCY SWITCH ON/OFF, GAS BURNER" WITH WHITE TEXT ON RED FLUSH MOUNTED METAL FACE PLATE.
 3. THERMAL CUT-OUT SWITCH: SHALL BE 120V, 15 AMP, UL LISTED, WITH REPLACEABLE 165°F THERMAL FUSE IN 4" SQUARE JUNCTION BOX. COVER PLATE SHALL BE FLUSH MOUNTED WITH STAMPED TEXT ON RED FLUSH MOUNTED METAL FACE PLATE.
 4. WALL RECEPTACLE: SHALL BE 120V, 20 AMP, GROUNDING, UL LISTED, SINGLE OUTLET IN WHITE FINISH. COVER PLATE SHALL BE 302 STAINLESS STEEL IN FINISHED SPACES, GALVANIZED STEEL IN UNFINISHED SPACES.


K1 GAS FIRED DOMESTIC WATER HEATING PLANT EMERGENCY & THERMAL SWITCH CONTROLS
NTS

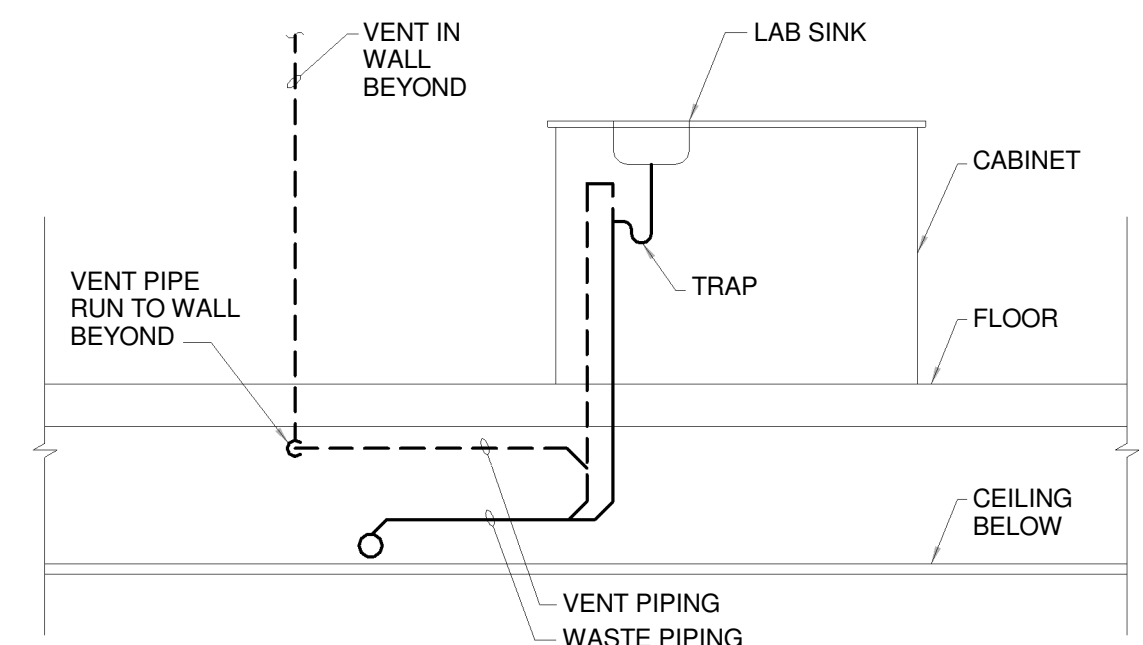


K9 ISLAND VENT DETAIL
NTS

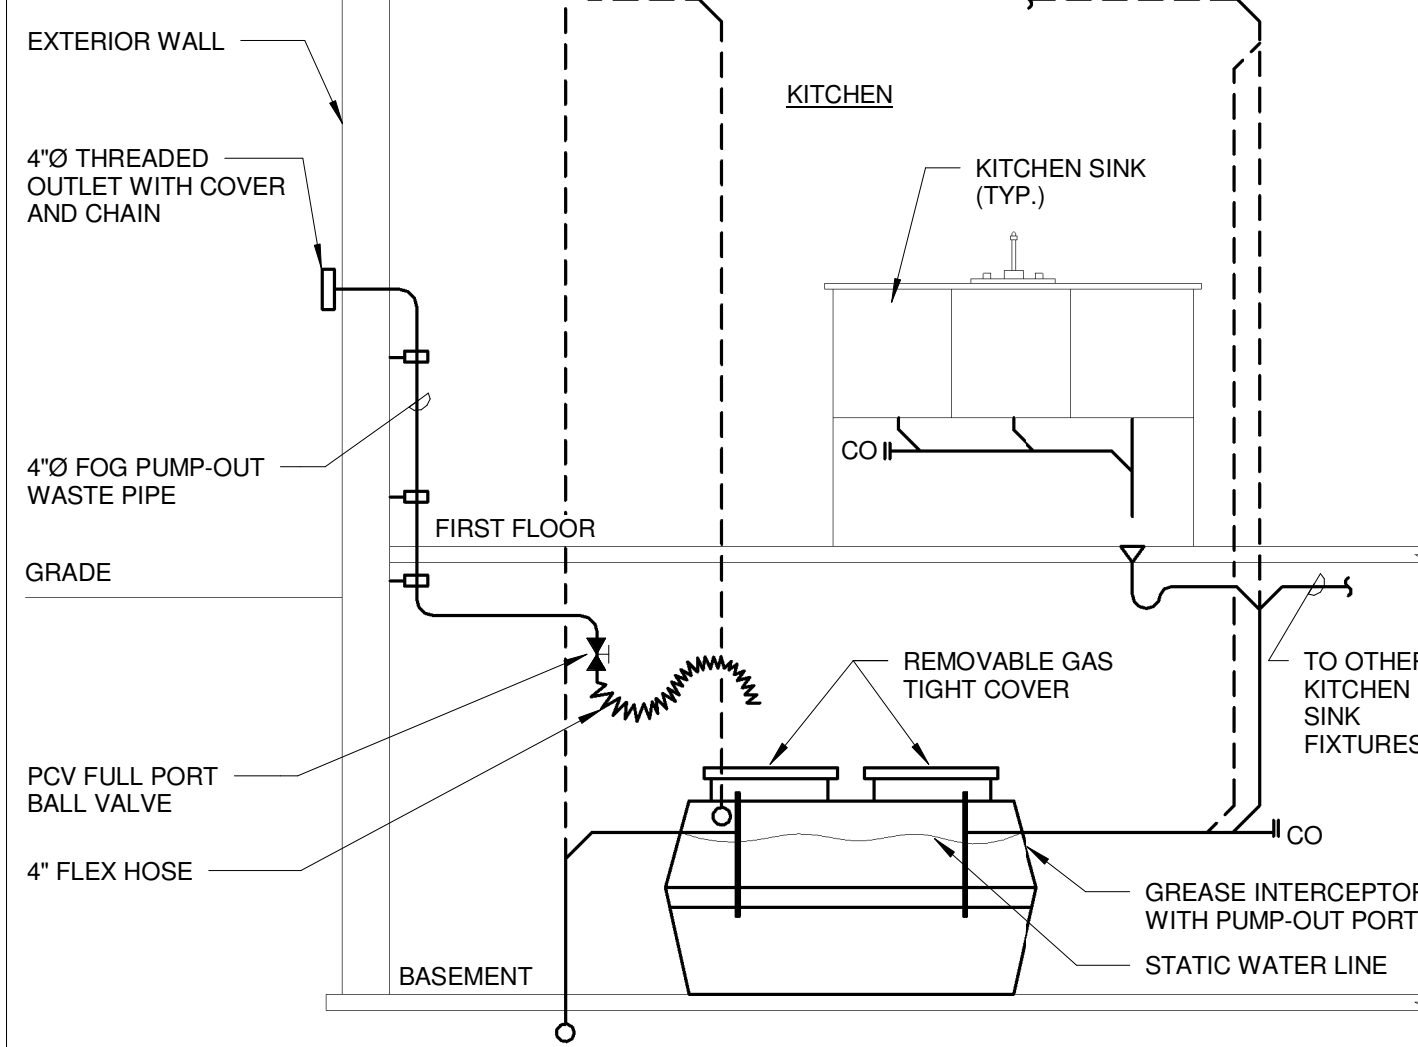


K12 GREASE (F.O.G.) INTERCEPTOR SCHEMATIC
NTS

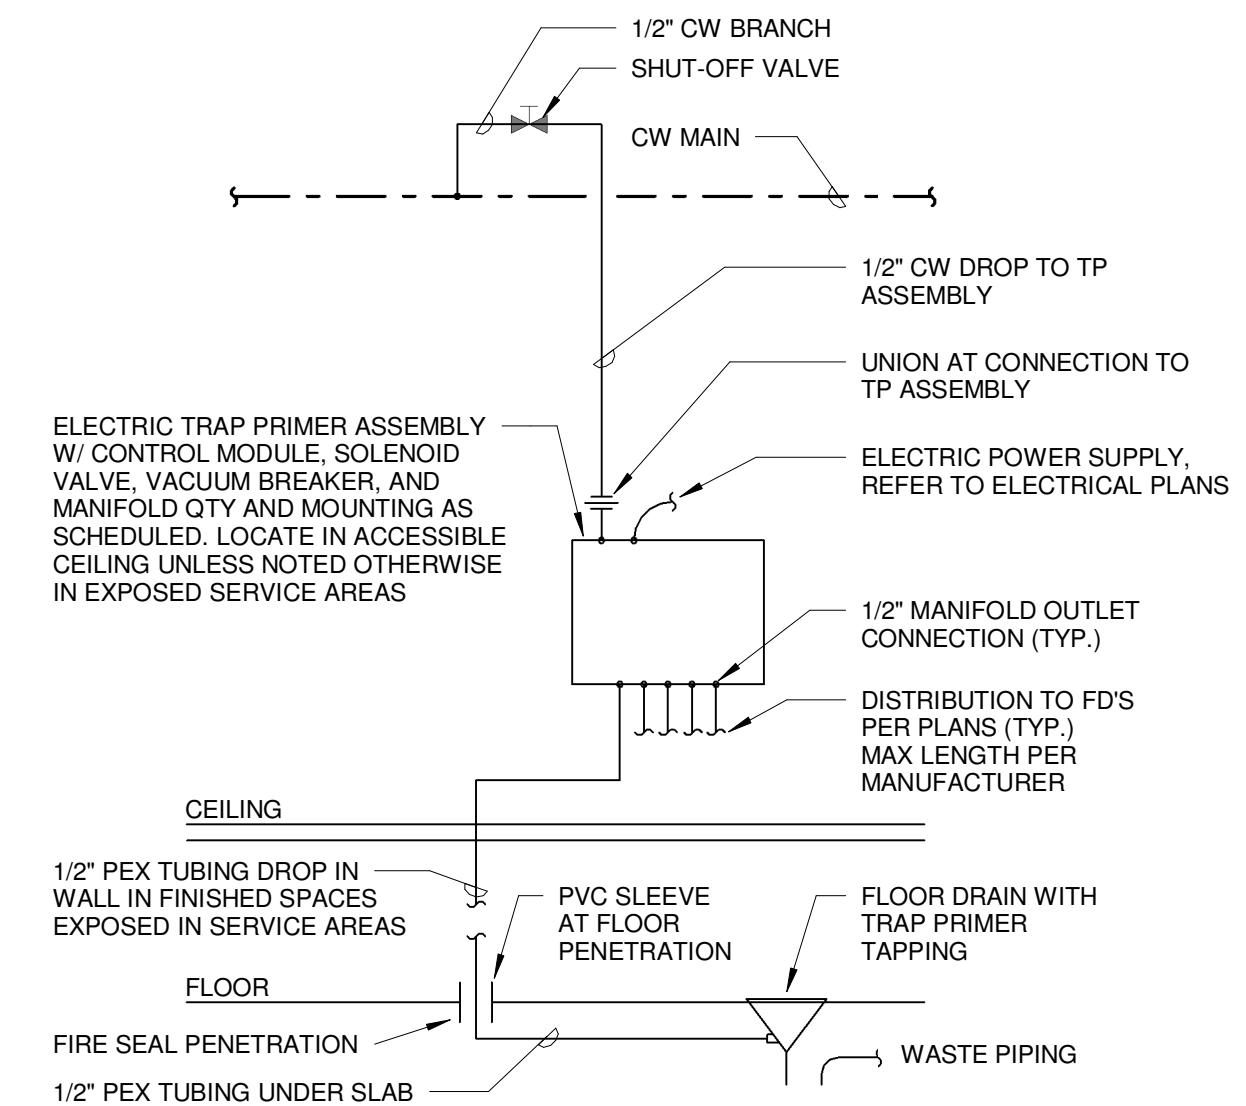


E1 ELECTRONIC TRAP PRIMER SCHEMATIC
NTS

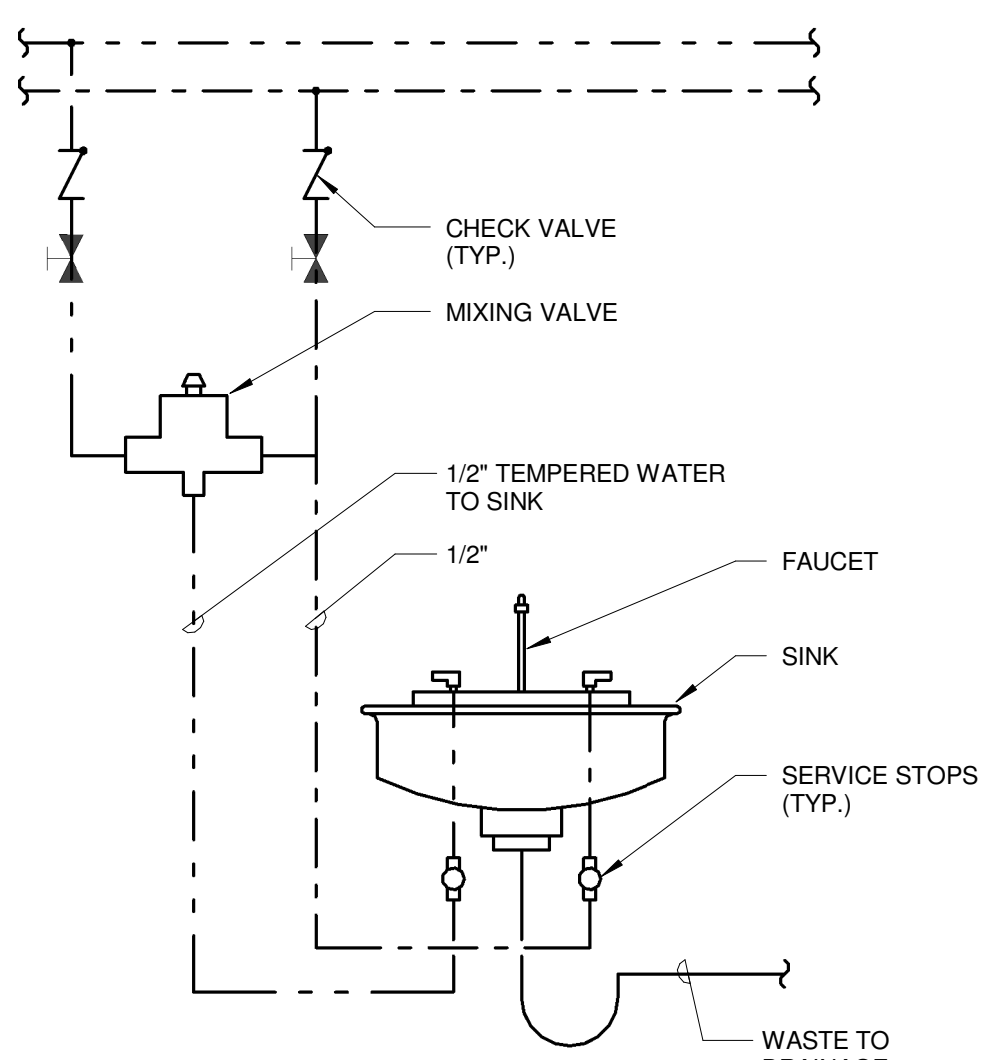


E5 MIXING VALVE PIPING SCHEMATIC
NTS

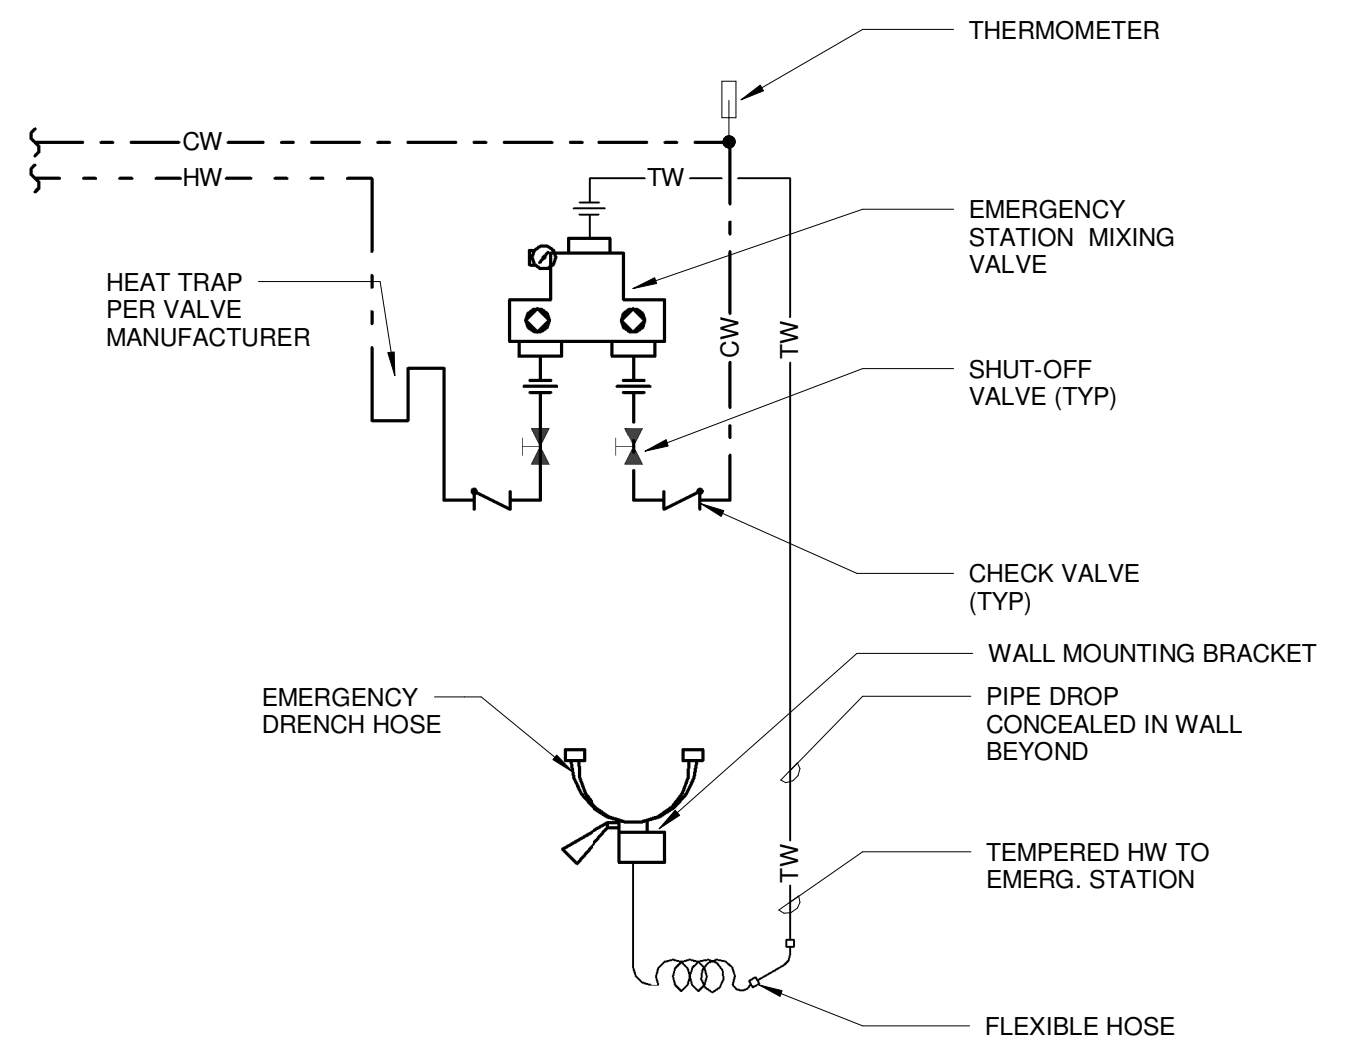


E9 SAFTY STATION & MIXING VALVE DETAIL
NTS

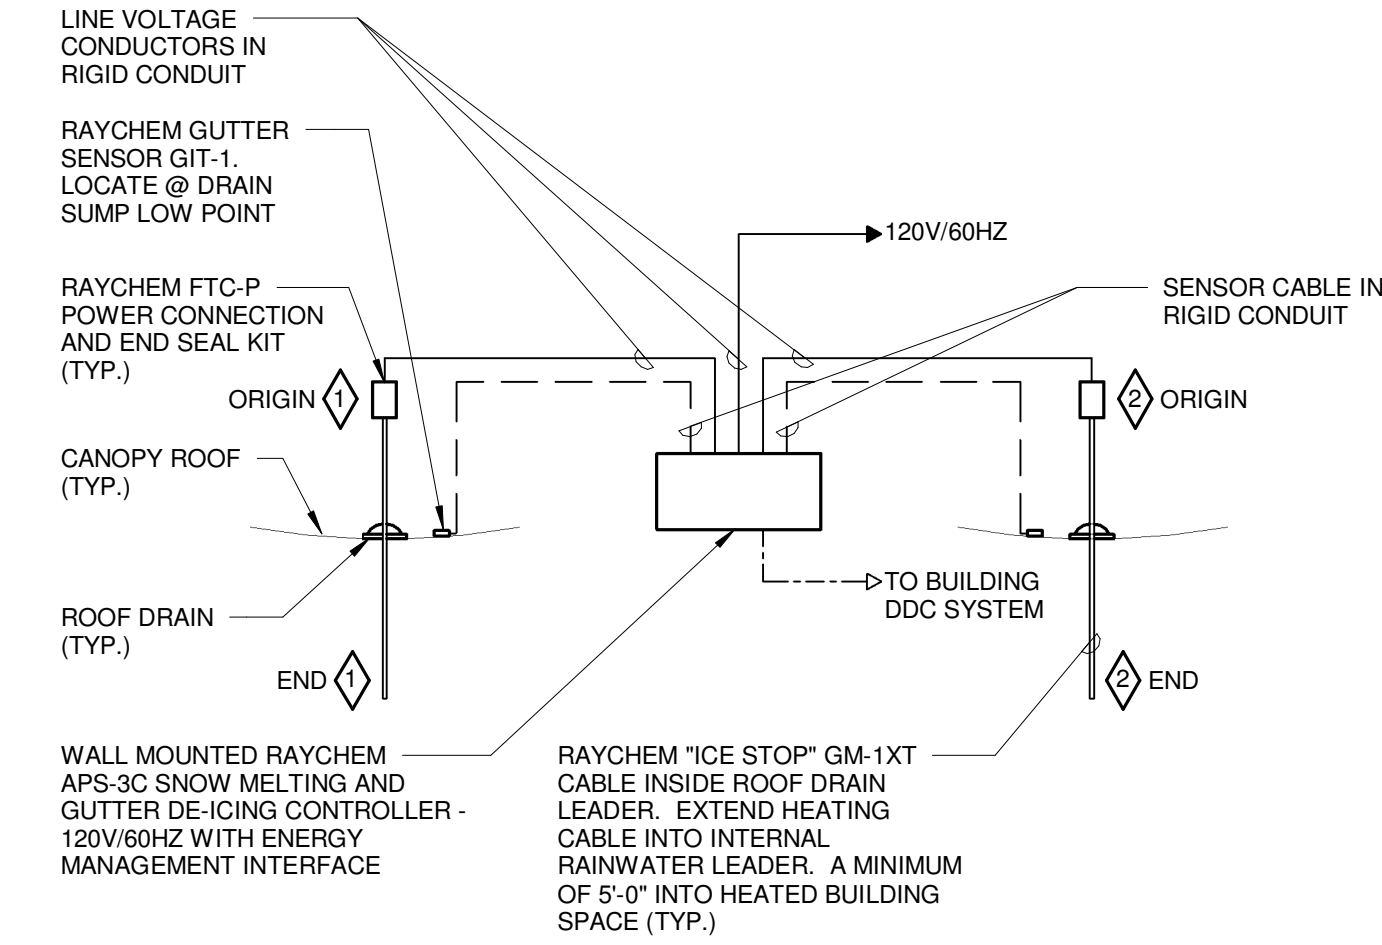


E12 RAINWATER LEADER FREEZE PROTECTION DIAGRAM
NTS

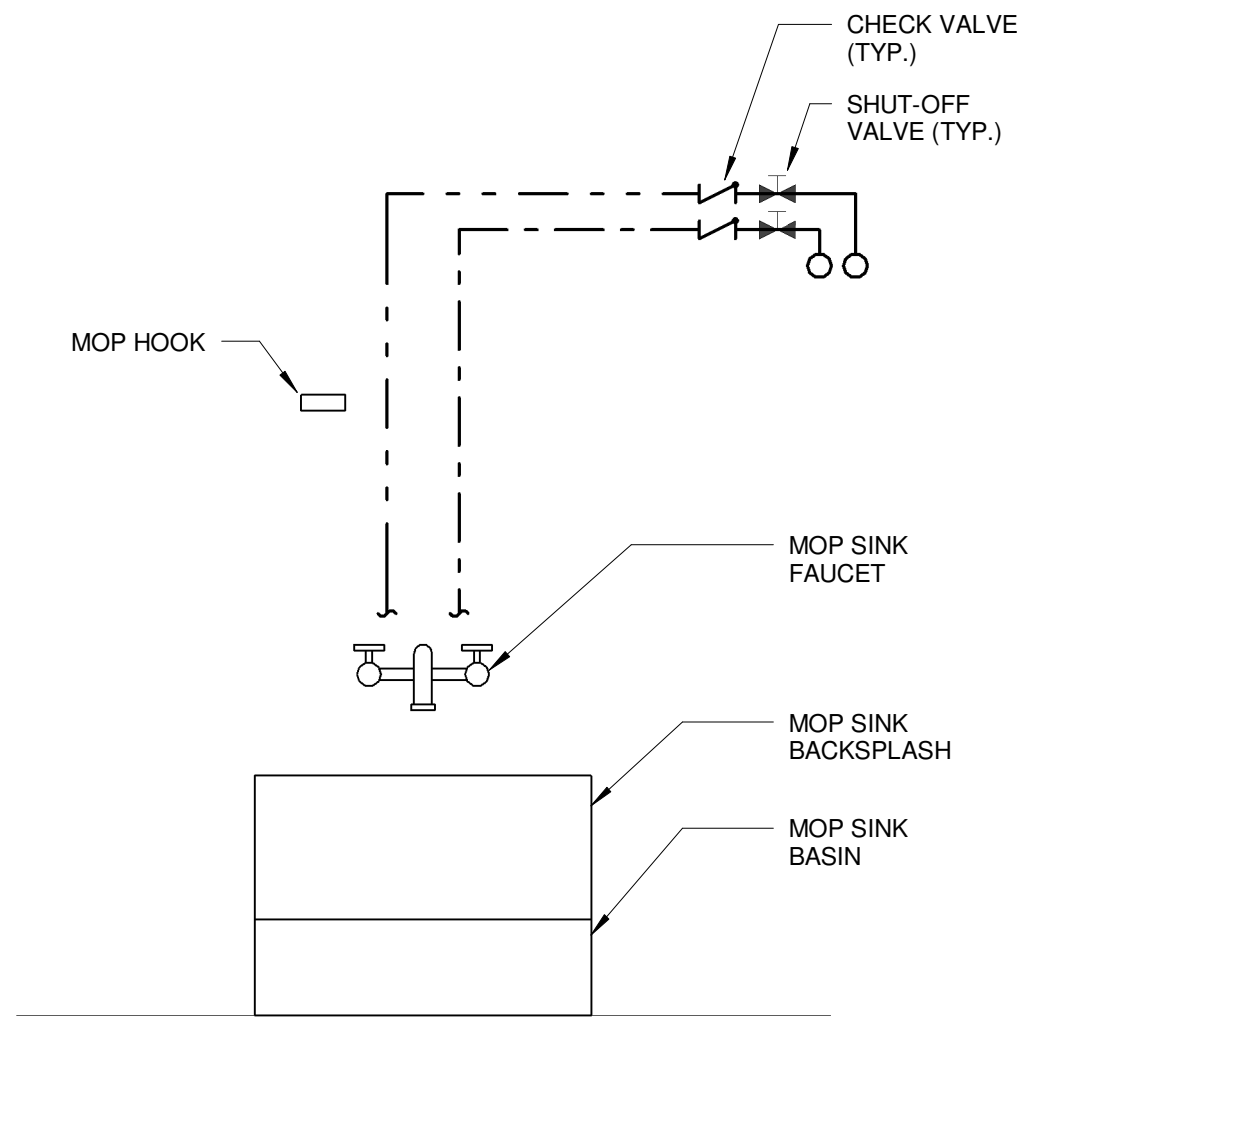


A1 MOP SINK PIPING SCHEMATIC (SERVICE SINK SIM.)
NTS

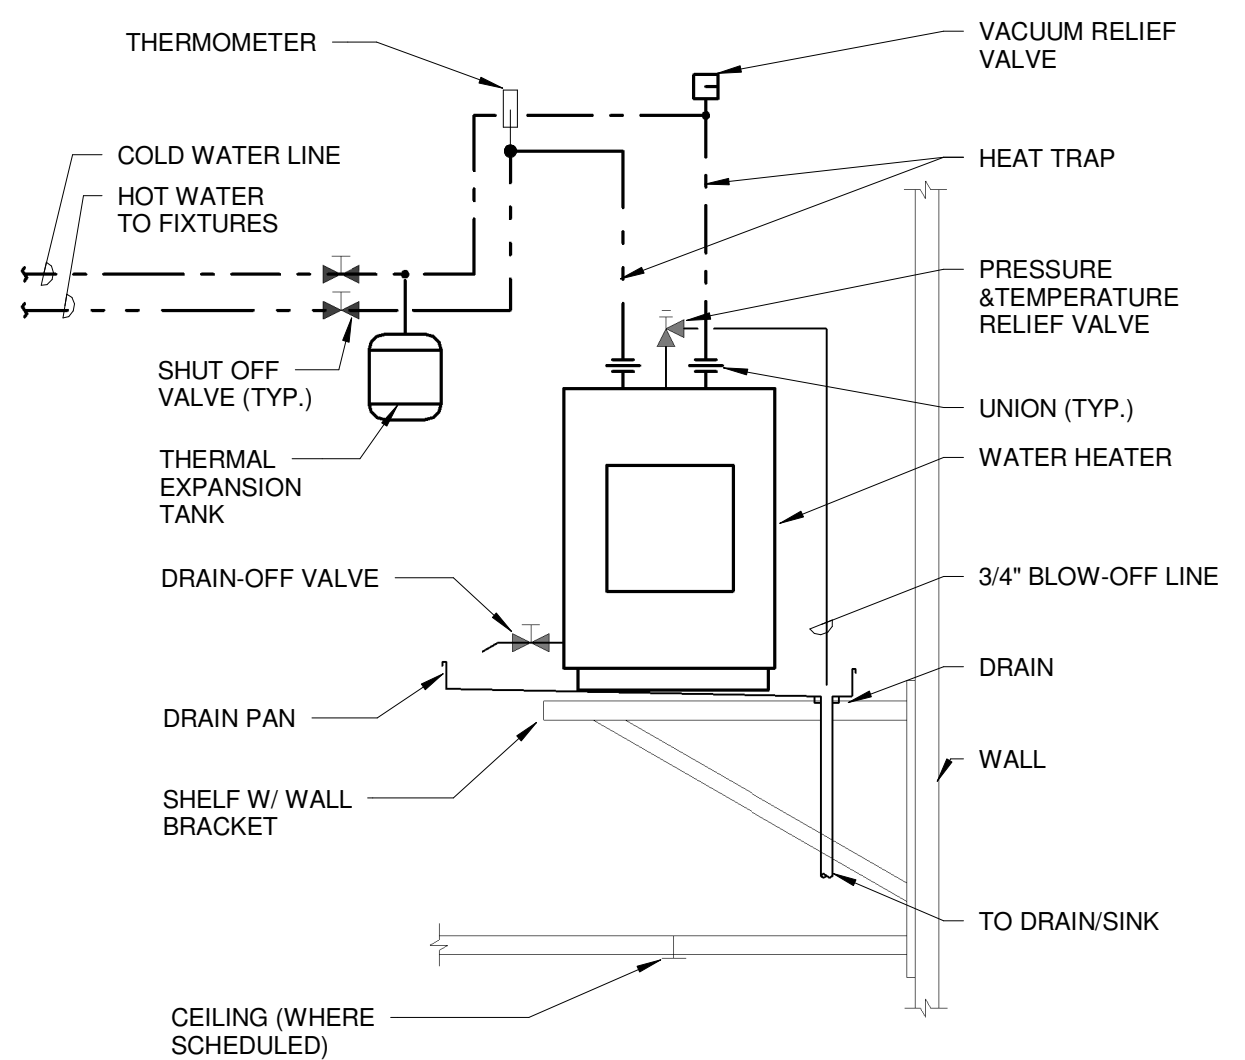

A5 WATER HEATER PIPING SCHEMATIC
NTS

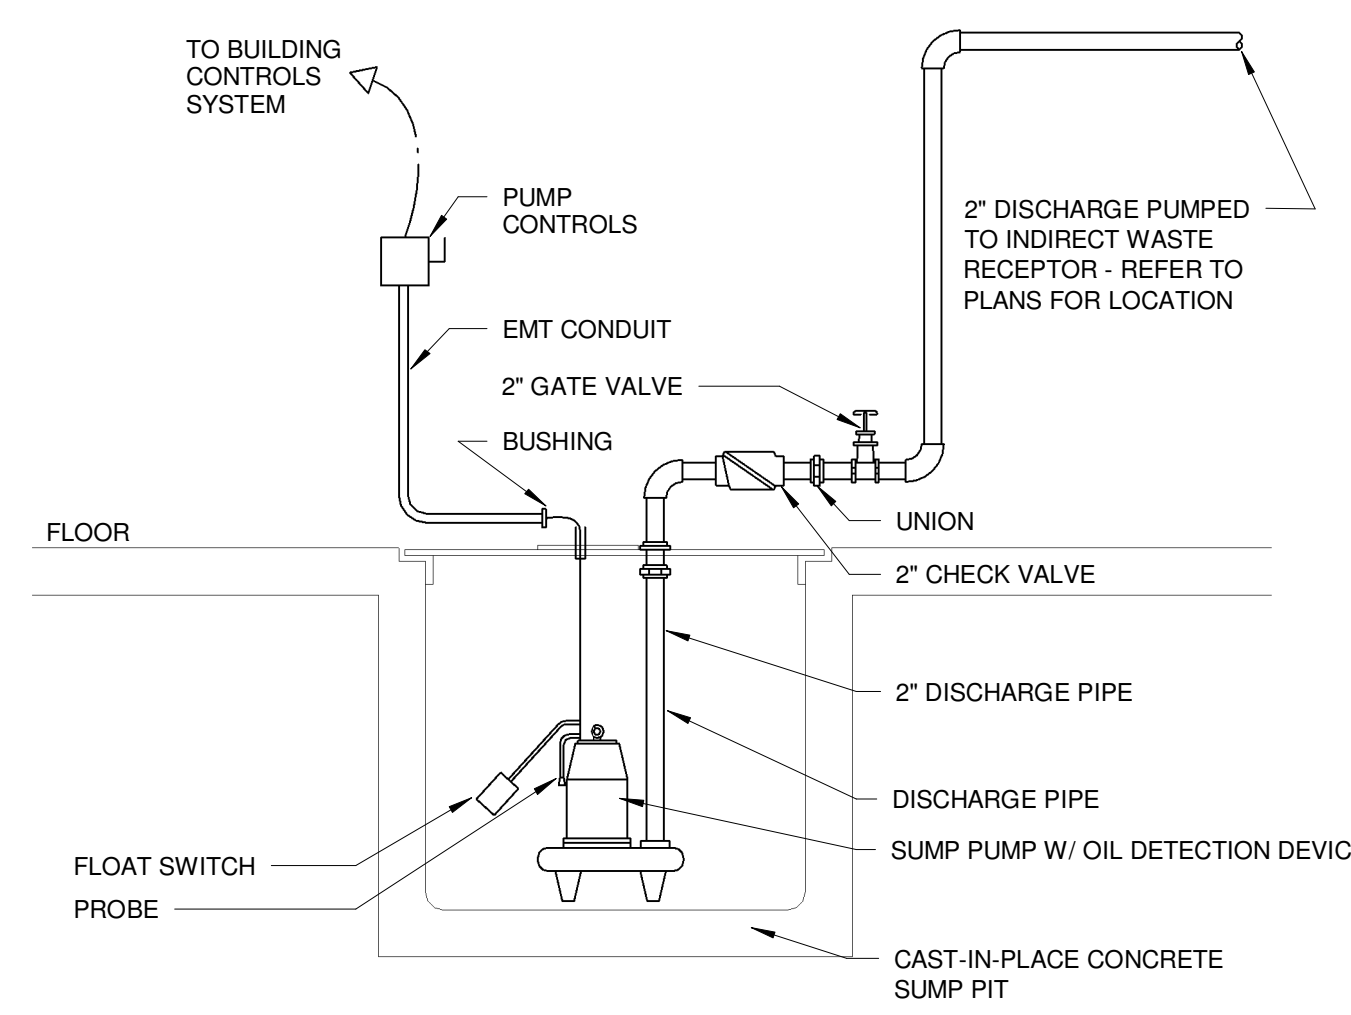

A9 SUMP PUMP DETAIL
NTS

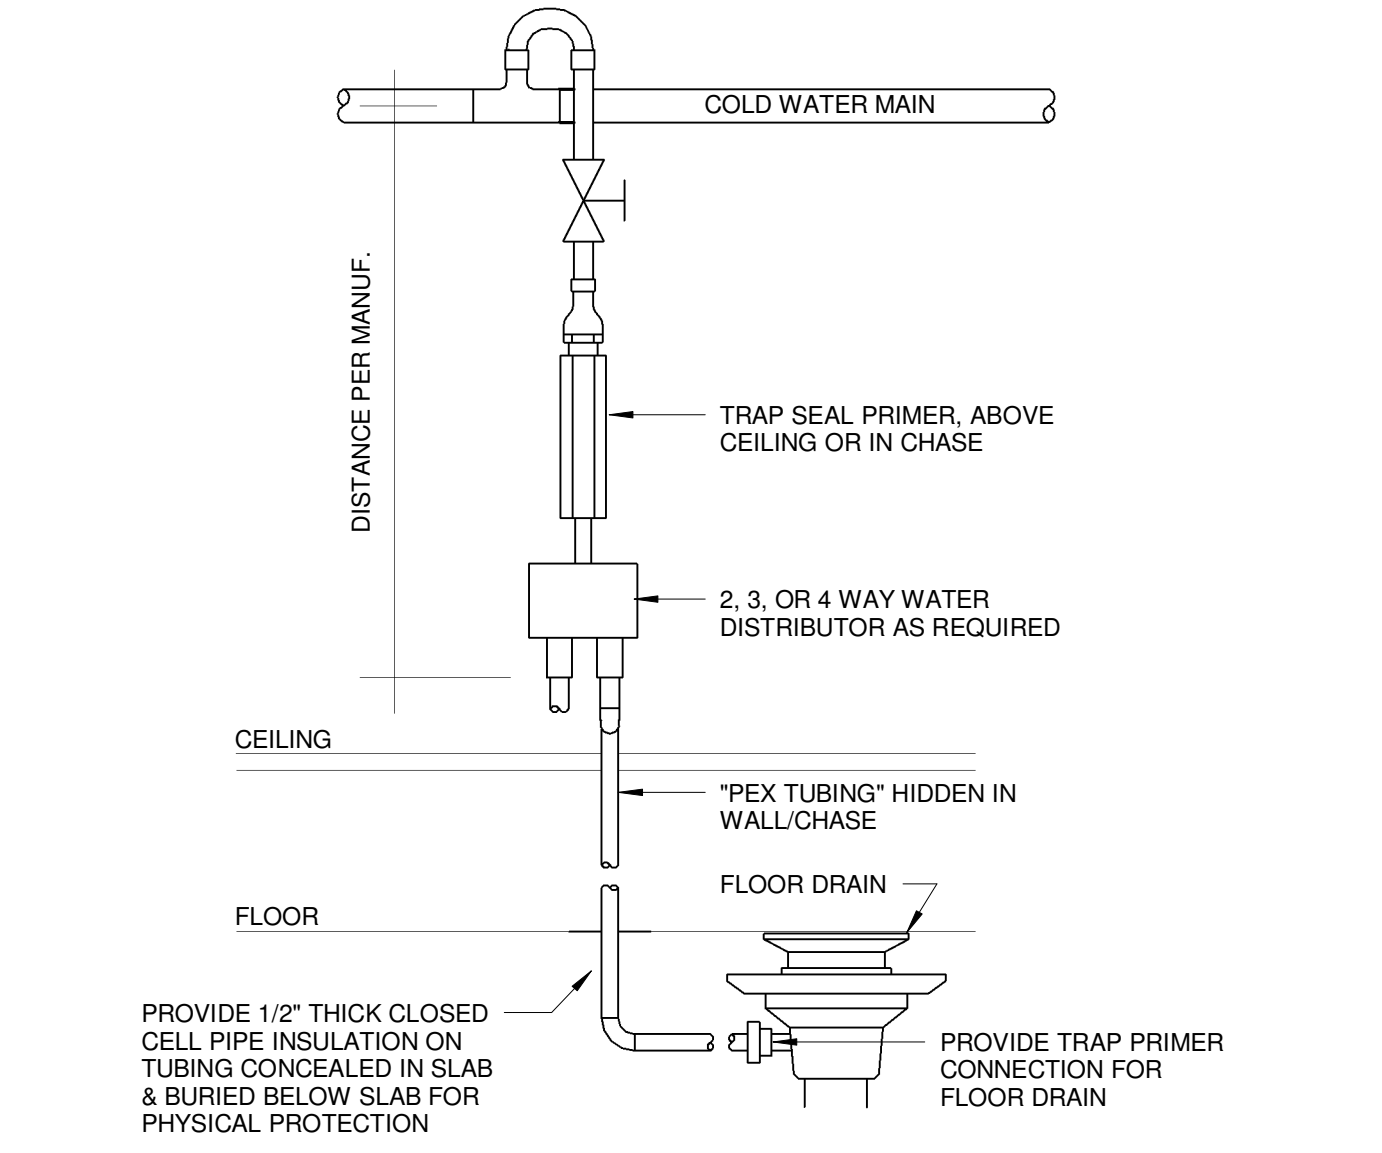

A12 TRAP PRIMER DETAIL
NTS

REV.	DESCRIPTION	DATE
0	ISSUED FOR BID	06 JUNE 2016

WBRC
ARCHITECTS ENGINEERS
WWW.WBRCAE.COM
BANGOR, MAINE 207-947-4511
PORTLAND, MAINE 207-828-4511
SARASOTA, FLORIDA 941-556-0757

ASYLUM

PROJECT: **ASYLUM DANCE CLUB - MECH**

PLUMBING DETAILS

SHEET TITLE: **PL503**

WBRC CAD FILE: 407110 - ASYLUM DANCE CLUB - MECH.RVT
PROJECT No. **4071.10** GRAPHIC SCALE: 0" = 1"
SCALE: **AS INDICATED**
PROJECT MANAGER: **JRB** SHEET No.
DRAWN BY: **CGB**
CHECKED BY: **DMON**

6/3/2016 4:20:51 PM C:\Users\courmey\Documents\407110 - ASYLUM DANCE CLUB - MECH\courmey\bunker.rvt