

| REVISION | DESCRIPTION | DATE |
|----------|------------------------------|------|
| 0 | ISSUED FOR REVIEW & APPROVAL | |

RESERVED FOR CITY STAMP

CUNNINGHAM

Security Systems

10 Princes Point Road, Yarmouth, Maine 04096
Office: 207.846.3350 • Fax: 207.846.6080


RM DAVIS
24 CITY CENTER
PORTLAND, MAINE 04101
FIRE ALARM PLAN

| | | |
|----------|----------------|-------------------|
| DRAWN | JPB | UNICAD JOB #16377 |
| CHECKED | WAYNE B. HAWES | UNICAD # 90496 |
| DATE | 5/25/2016 | |
| REVISION | 0 | |
| SCALE | 1/4"=1'-0" | |

FA-1

UNICAD Inc.
Fire Alarm Design & Drafting Services
www.unicad.net
578 W. 40th St.
Portland, ME 04102
Office: 603.865.6410

PRELIMINARY

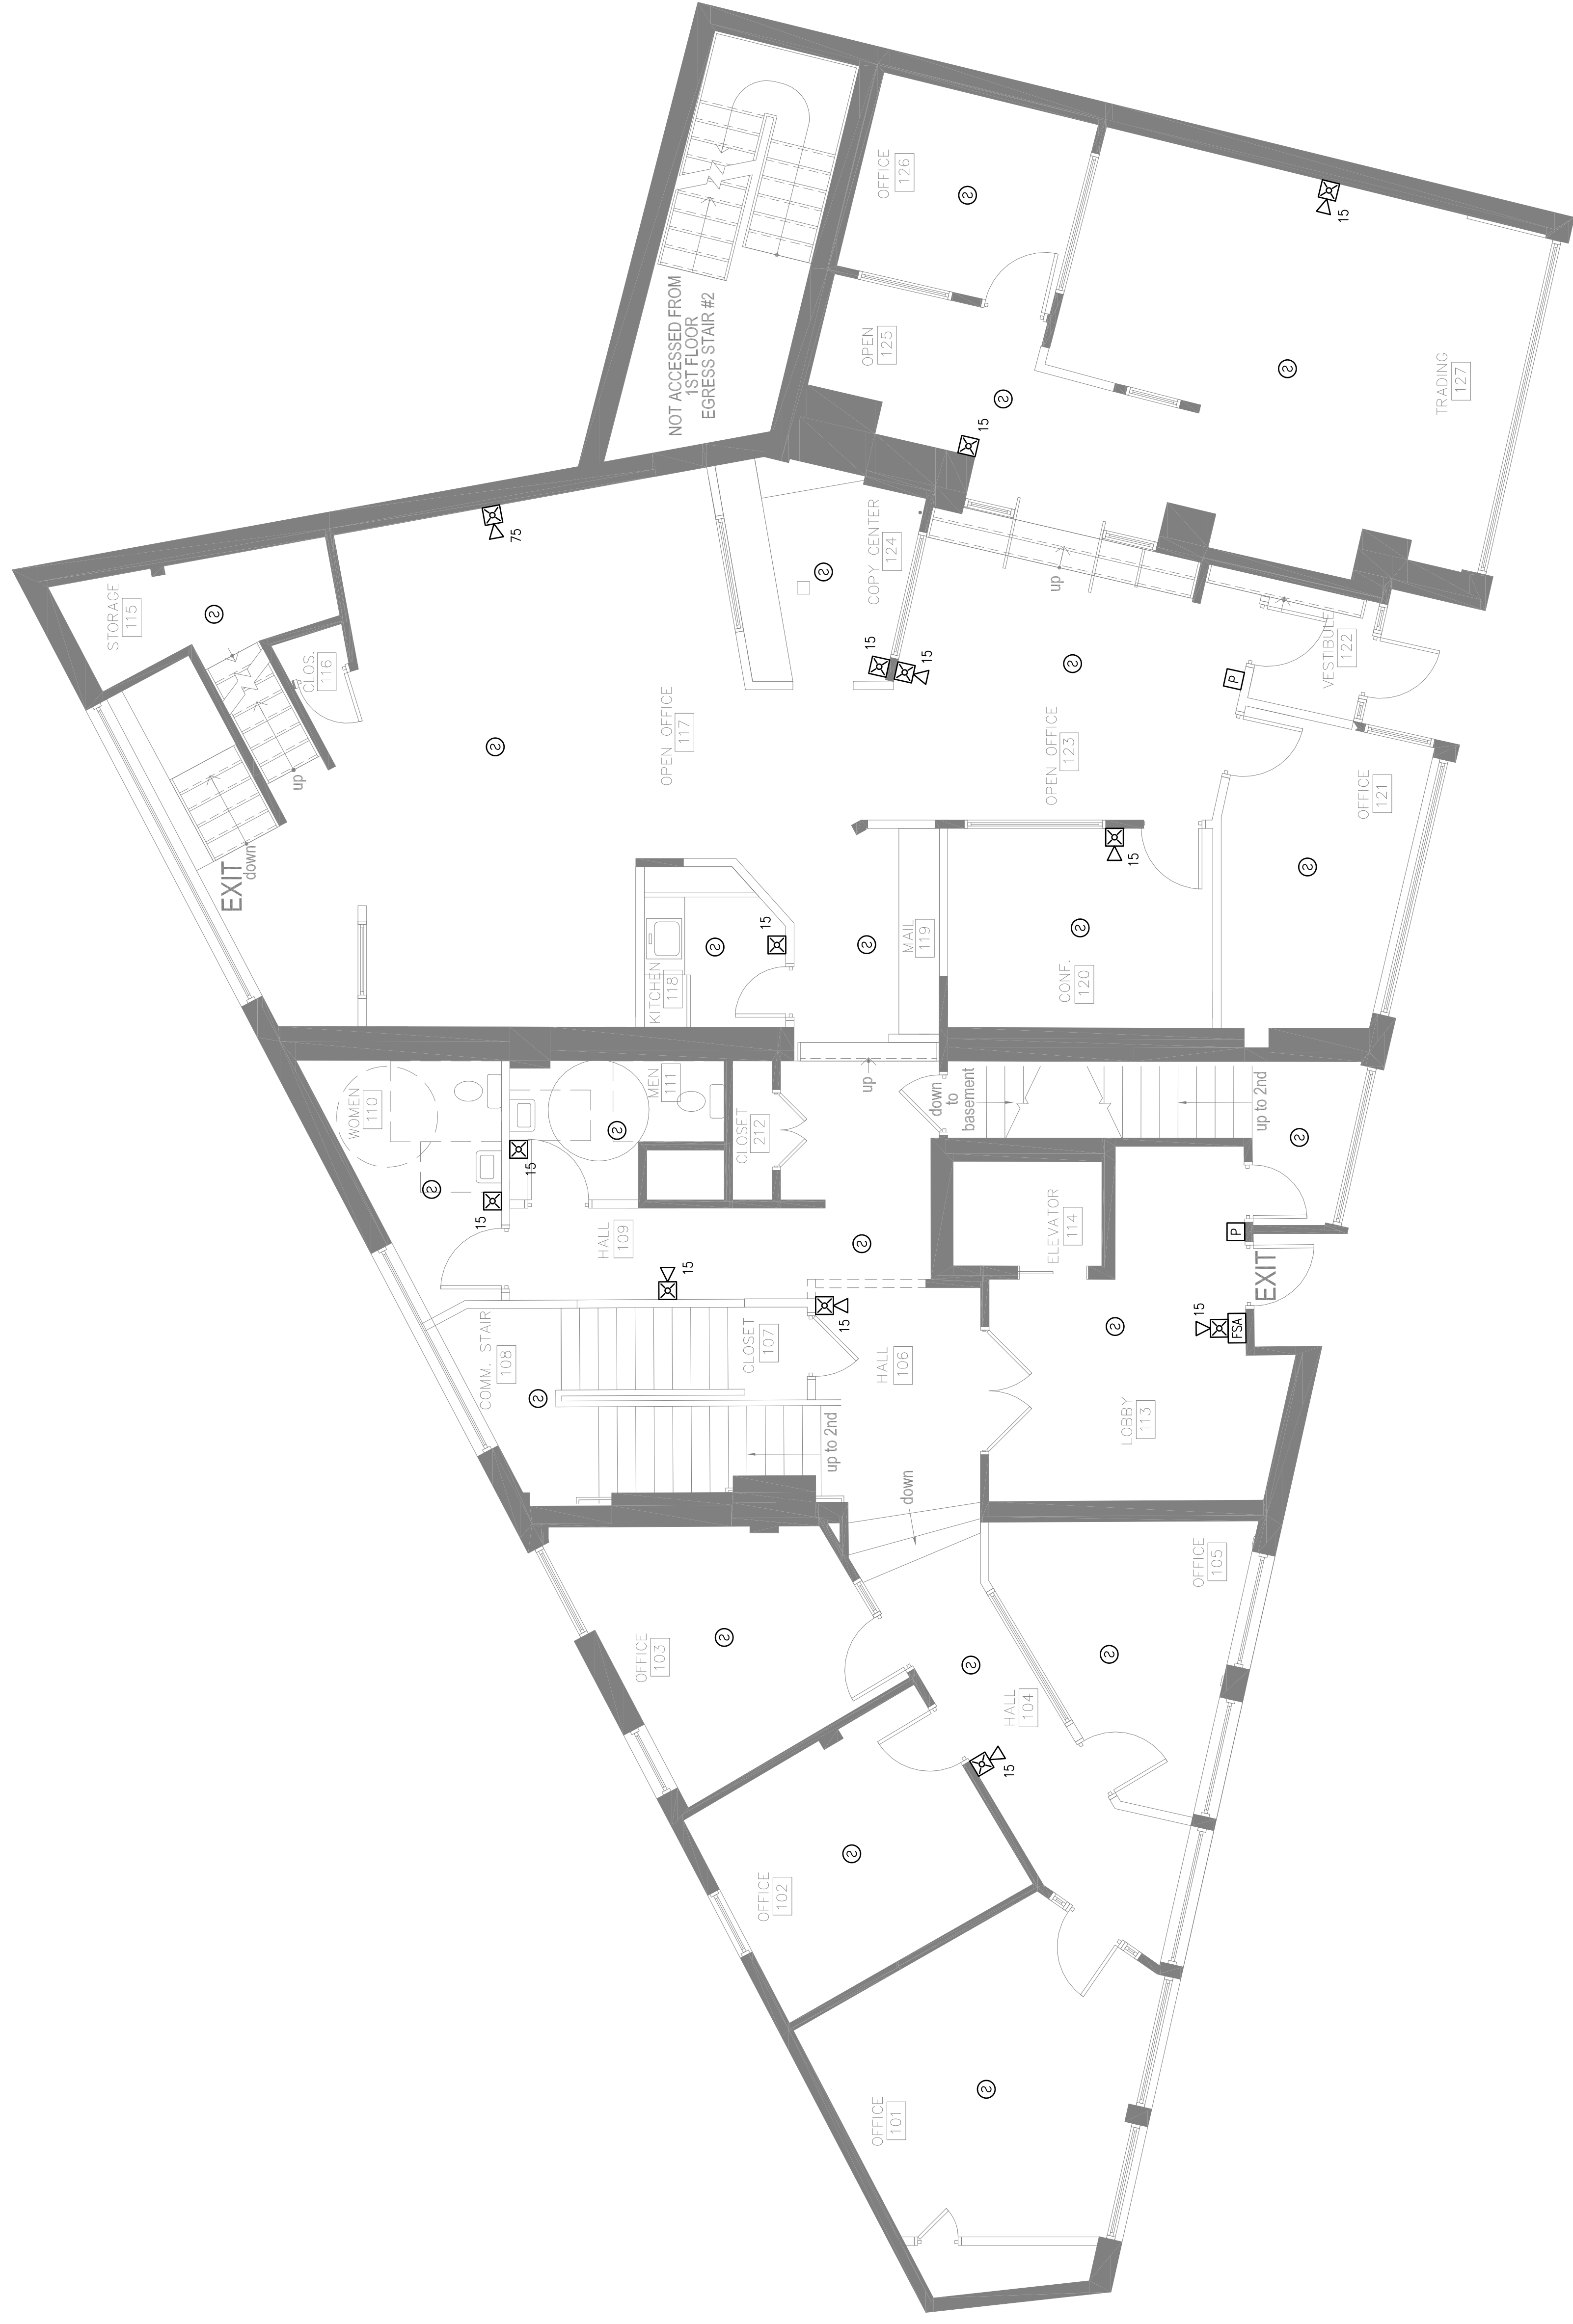

PROJECT NORTH
FIRST FLOOR FIRE ALARM PLAN
SCALE: 1/4"=1'-0"

