



NOTE:

- 1. DUCT SMOKE SENSOR EXACT LOCATIONS TO BE VERIFIED IN FIELD.

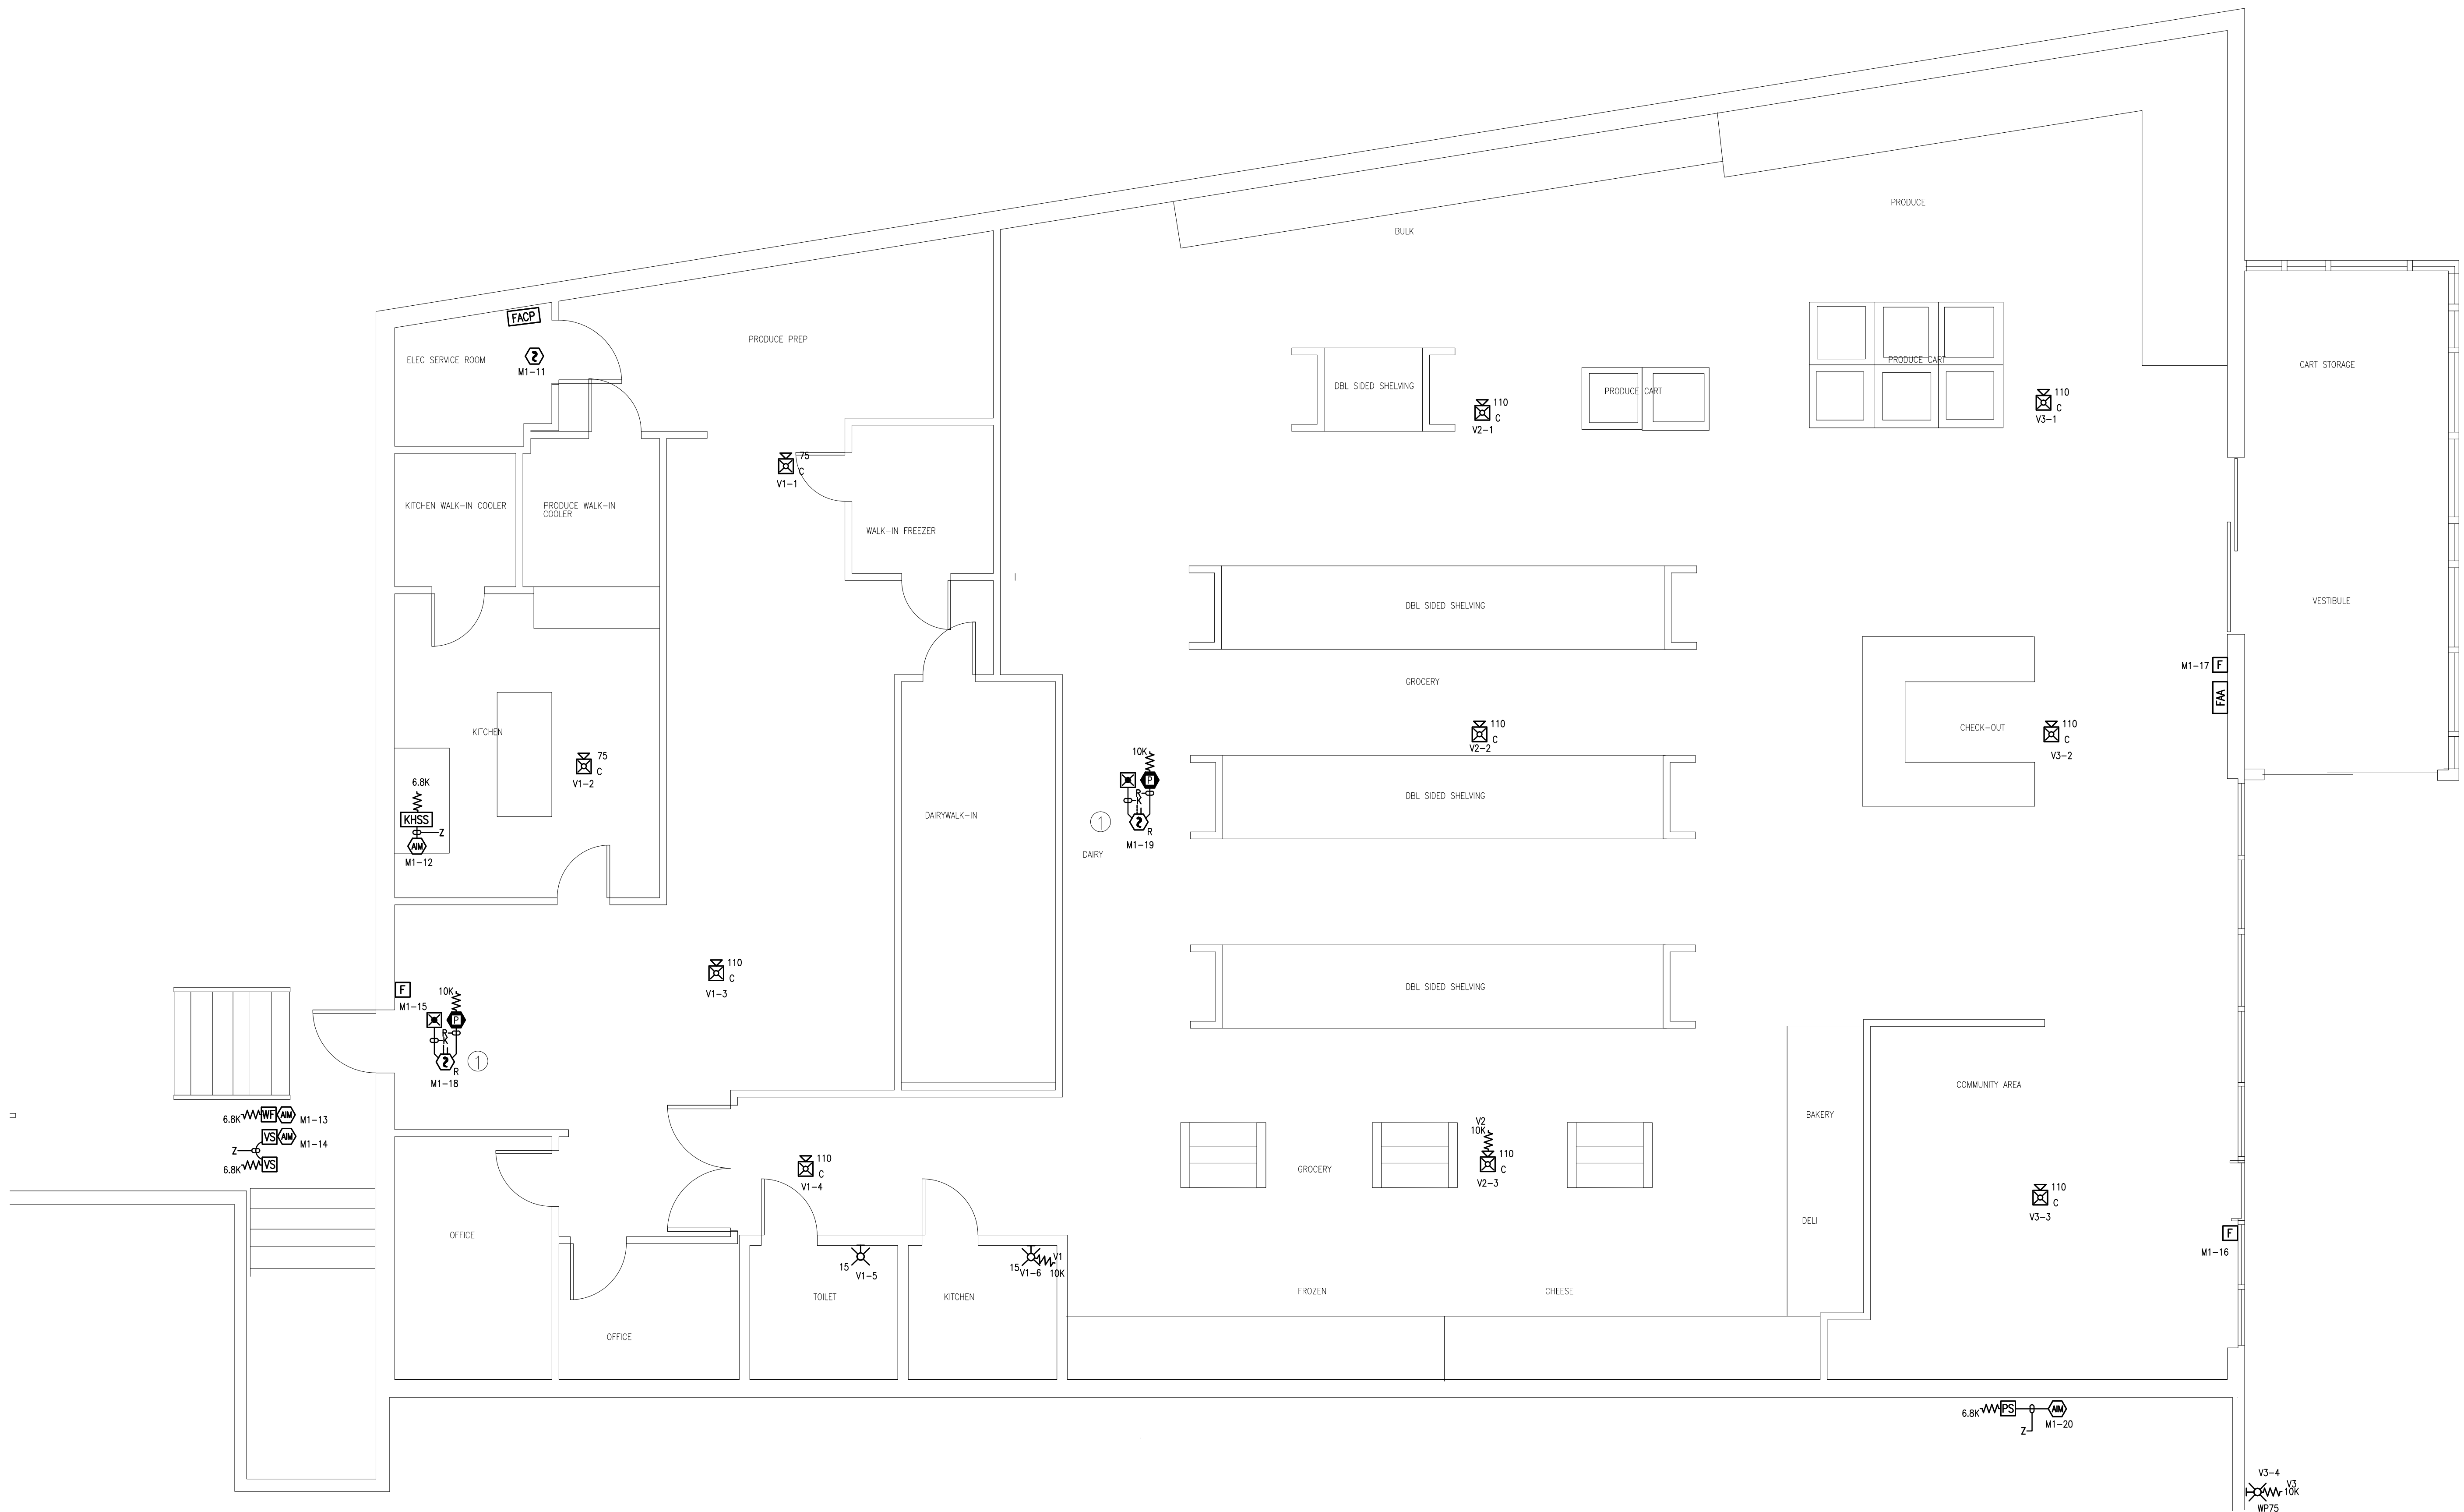

FLOOR PLAN

SCALE: 1/4" = 1'-0"

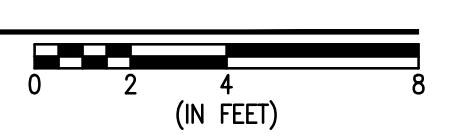

PORTLAND FOOD CO-OP

PORTLAND FOOD CO-OP
290 CONGRESS STREET
PORTLAND, ME 04101

ISSUE NO.	DATE	CHK.	DESCRIPTION

DRAWN BY:	G. LORION
CHECKED BY:	S. KALAFARSKI
ISSUE DATE:	9/17/14
JOB #:	
PROJECT #:	147-980171201
SIMPLEXGRINNELL ©	2014
SYSTEM:	FIRE ALARM SYSTEM

SHEET:	
DEVICE PLACEMENT PLAN	
FA-101	

IMPORTANT NOTICE TO USER: By accepting or copying this drawing, you agree to be bound by the following terms and conditions. This document is the property of SimplexGrinnell and is loaned to you for your specific use. Any use, reproduction, modification or alteration of the information contained herein shall be at the sole risk of the user. This information may not be sold or transferred to any third party, used or other projects or addresses to the project for which it was prepared or used for completion of this project by any third party. SimplexGrinnell disclaims all liability for the user or misuse of this information.