


FILE PATH: P:\2014\147\Portland Food Co-op\CAD\FAC201.dwg

LAST SAVED BY: MDESJATA

LAST PRINTED: 9/17/2014 2:48:06 PM

24 x 36" Arch D Size

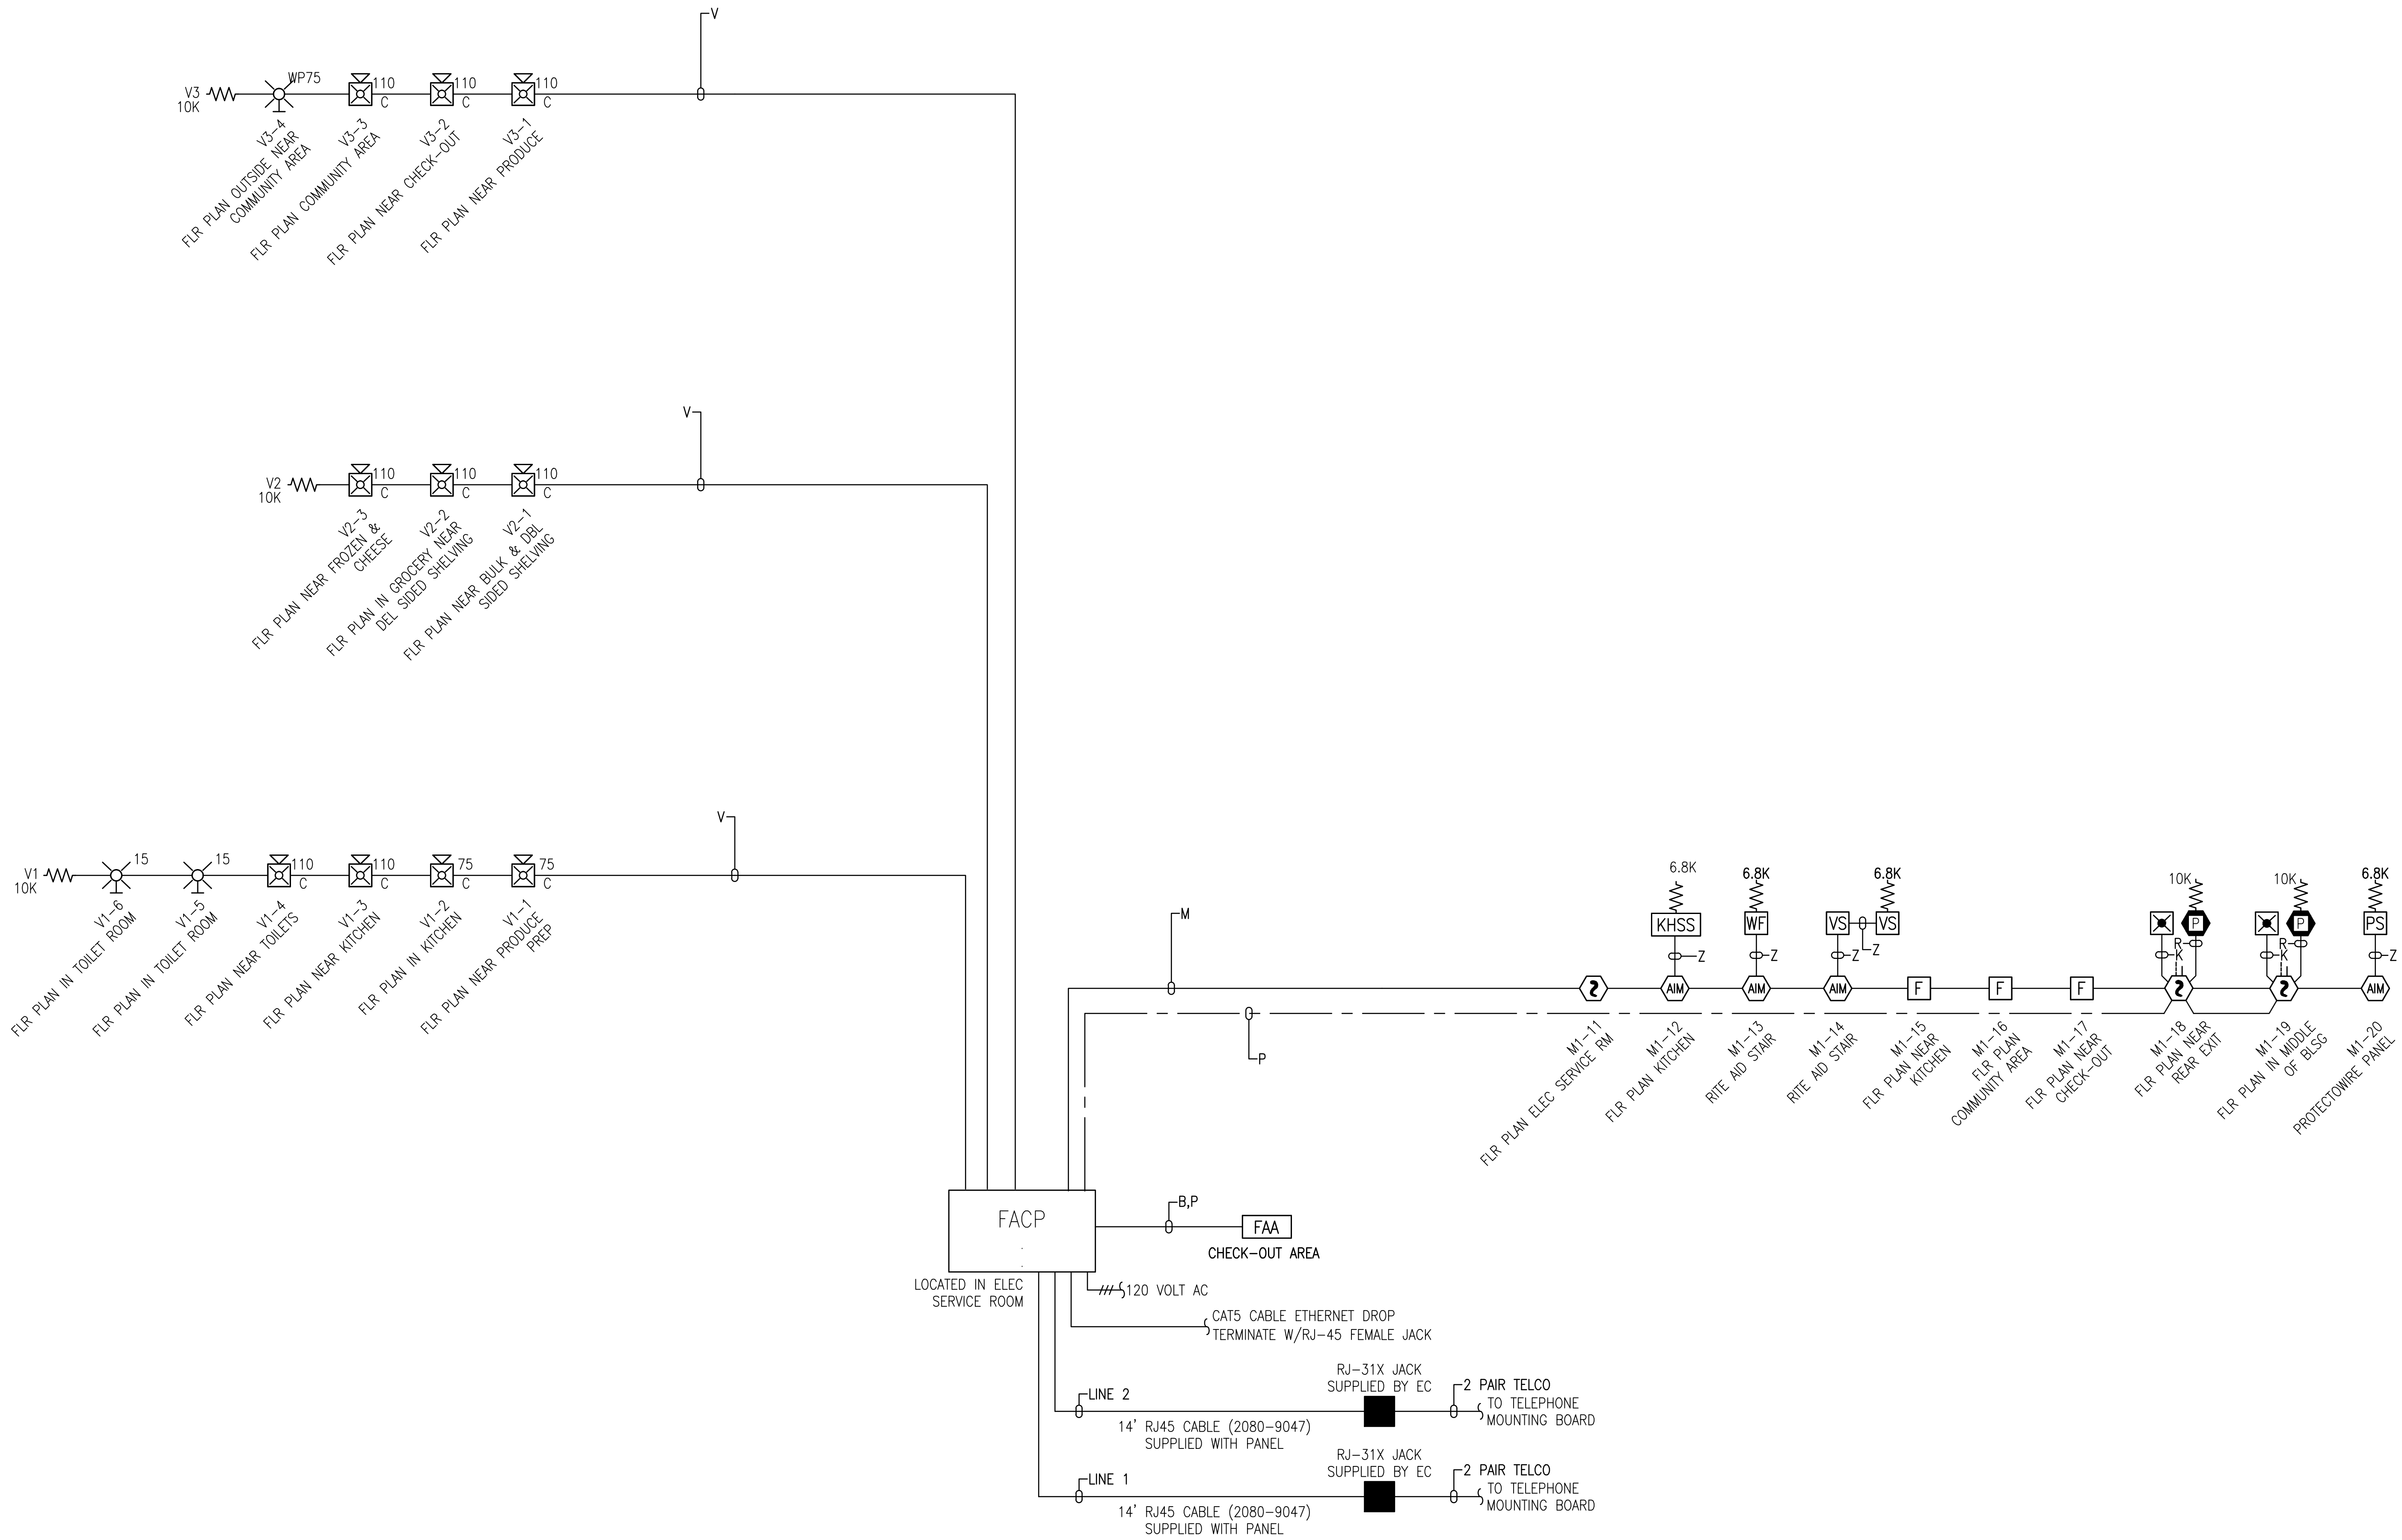

FLOOR PLAN

RISER DIAGRAM

FLOOR PLAN

tyco
SimplexGrinnell

Safer. Smarter. Tyco.

DISTRICT - 147
WEST BRIDGE AVE
WESTBROOK, ME 04092
PHONE: 207-842-6440
FAX: 207-842-6439

PORTLAND FOOD CO-OP

PORTLAND FOOD CO-OP
290 CONGRESS STREET
PORTLAND, ME 04101

| ISSUE NO. | DATE | CHK | DESCRIPTION |
|-----------|------|-----|-------------|
| | | | |
| | | | |
| | |
|-------------|-------------------|
| DRAWN BY: | G.LORION |
| CHECKED BY: | S. KALAFARSKI |
| ISSUE DATE: | 9/17/14 |
| JOB #: | |
| PROJECT #: | 147-980171201 |
| SYSTEM: | FIRE ALARM SYSTEM |

SHEET:

RISER DIAGRAM

FA-201

IMPORTANT NOTICE TO USER: The drawings of this document are prepared by the author for the use of the client. The client is responsible for the accuracy of the information provided in the drawings. The drawings are not to be used for construction or other purposes without the written consent of the author. The drawings are not to be used for any other purpose without the written consent of the author. The drawings are not to be used for any other purpose without the written consent of the author. The drawings are not to be used for any other purpose without the written consent of the author. The drawings are not to be used for any other purpose without the written consent of the author.