


FIRE ALARM CONTROL PANEL
ELECT. SERVICE ROOM

SCALE: NTS

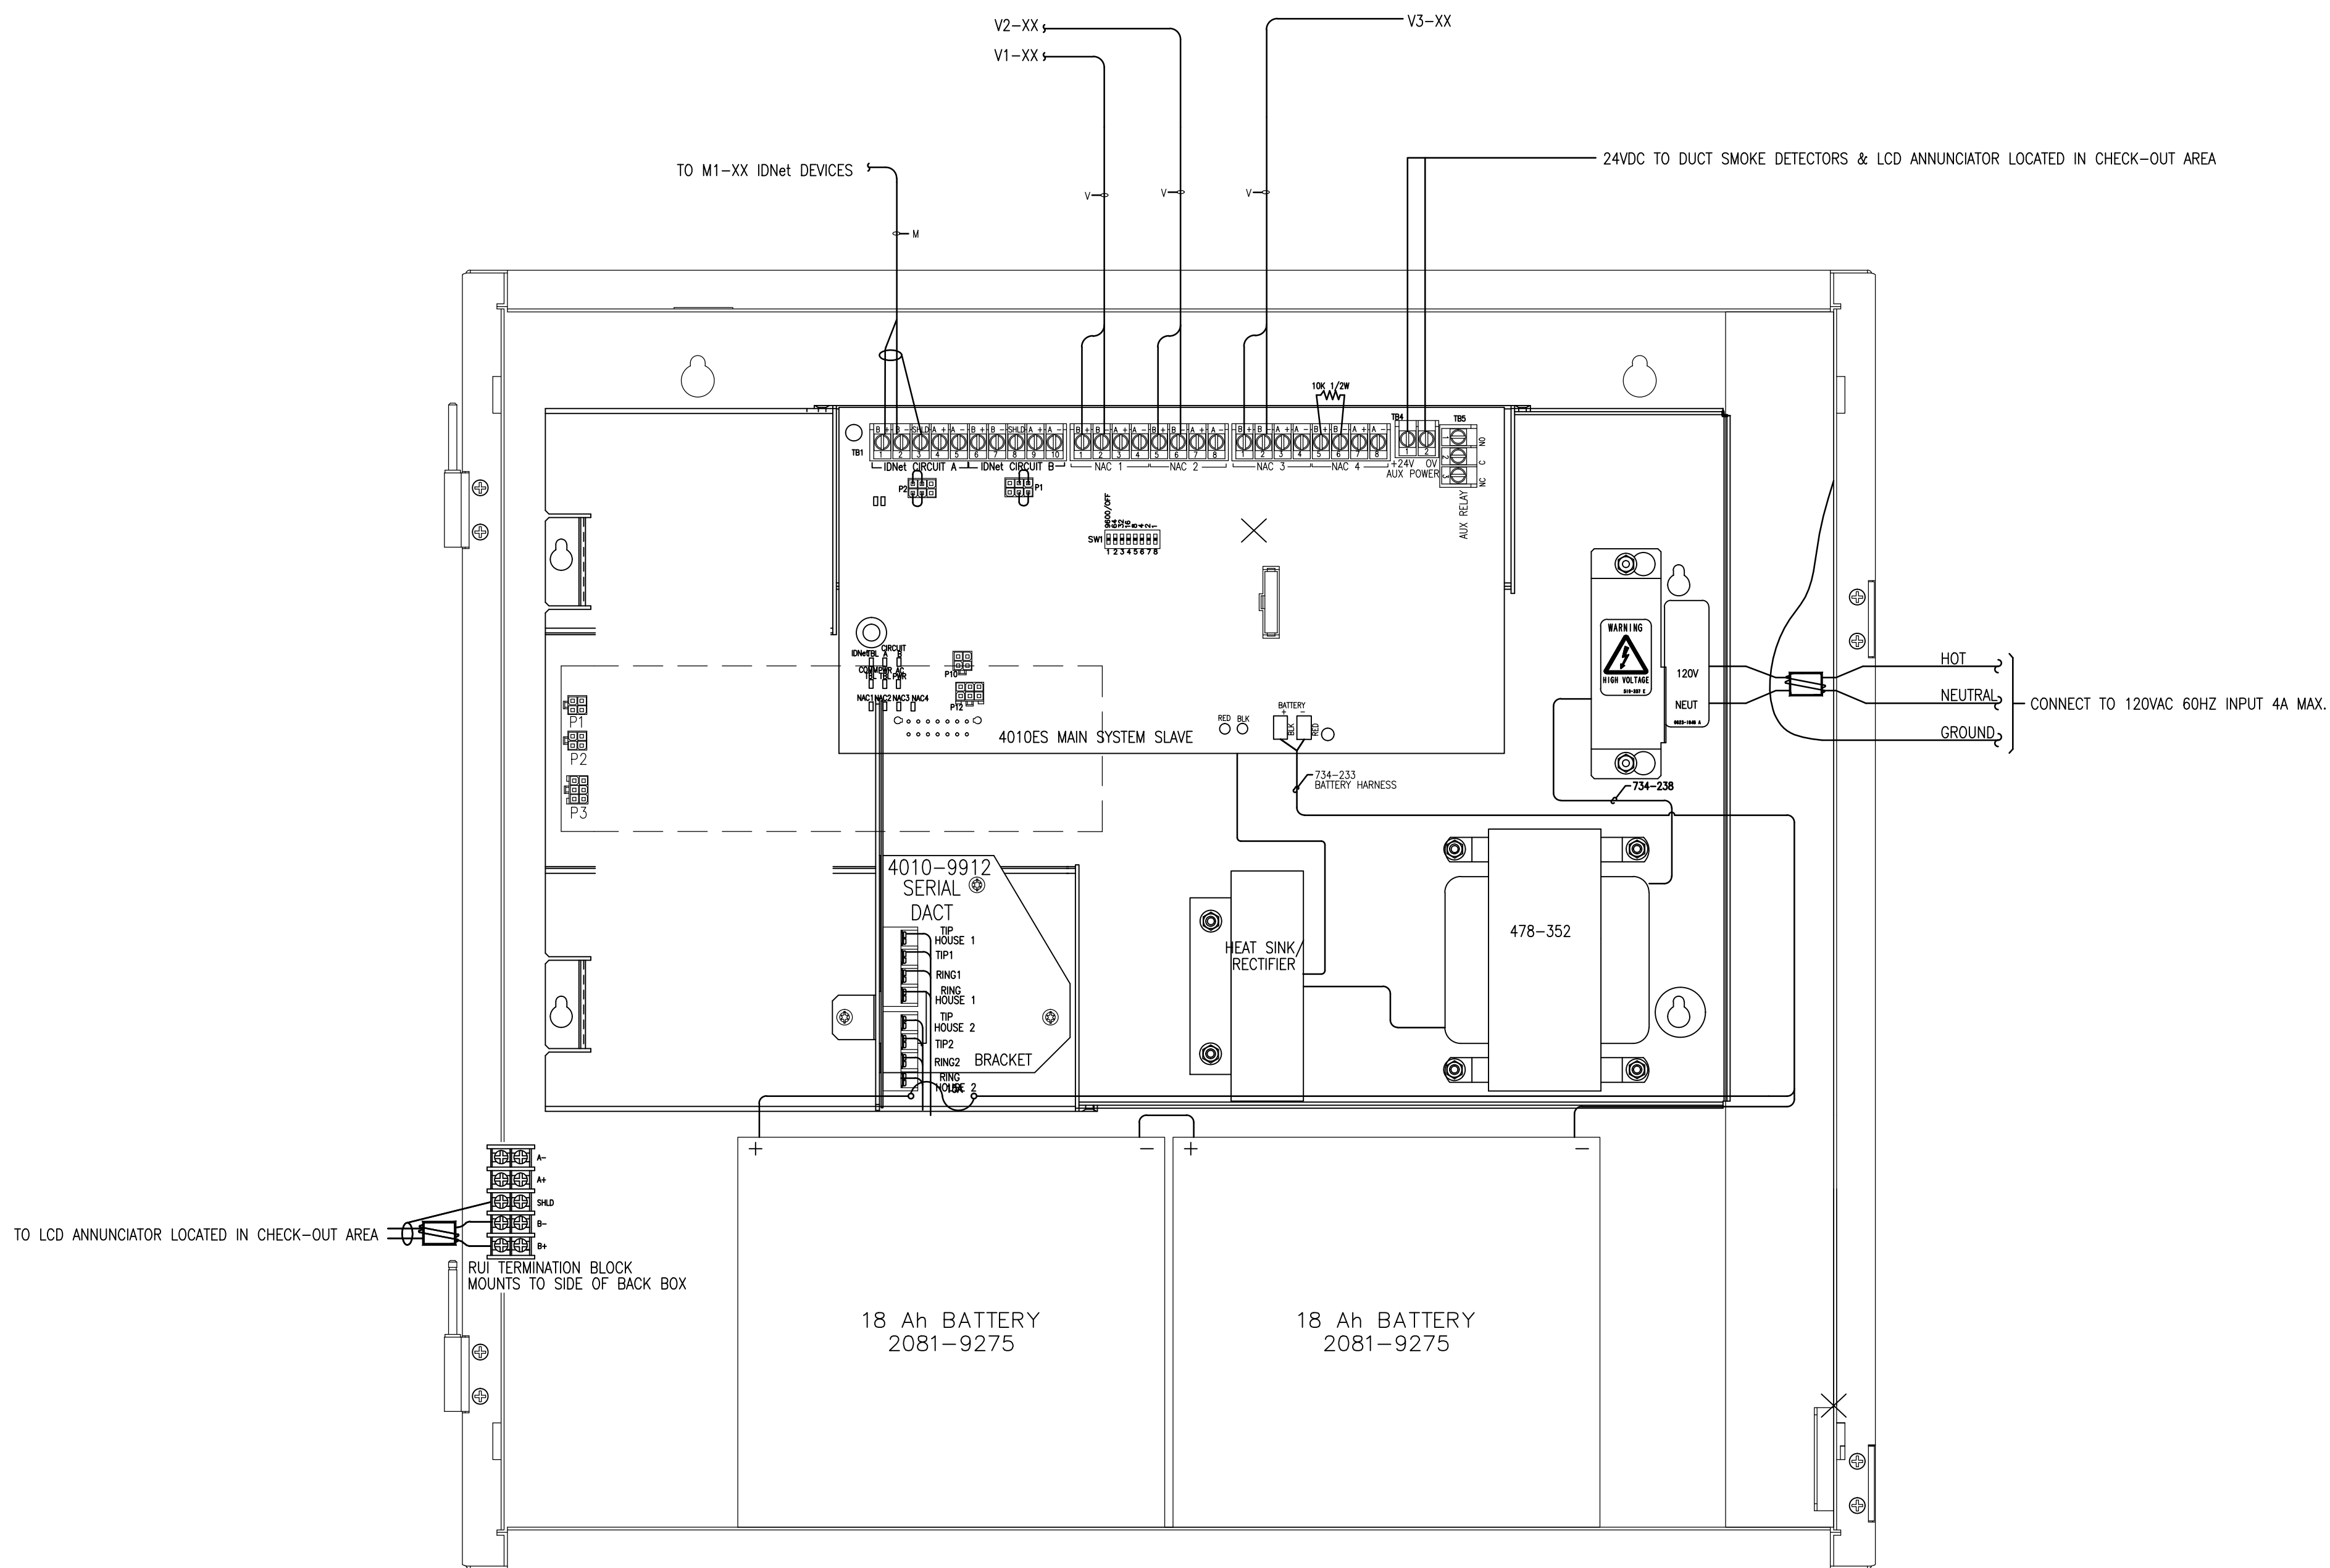

tyco
SimplexGrinnell

safer. Smarter. Tyco.™

DISTRICT - 147
WESTBROOK, ME 04092
SERVICE: 207-842-6440

PHONE: 207-842-6440
FAX: 207-842-6439

PORTLAND FOOD CO-OP

PORTLAND FOOD CO-OP
290 CONGRESS STREET
PORTLAND, ME 04101

ISSUE NO.	DATE	CAD	CHK	DESCRIPTION

DRAWN BY: G. LORION
CHECKED BY: S. KALAFARSKI
ISSUE DATE: 9/17/14
JOB #: 147-980171201
PROJECT #: 147-980171201
SIMPLEXGRINNELL © 2014
SYSTEM:
FIRE ALARM SYSTEM

SHEET:
PANEL DETAIL
FA-501

IMPORTANT NOTICE TO USER: By accepting or using this drawing, you agree to the following terms and conditions: This document is the property of SimplexGrinnell. It is loaned to you for your use only. It is not to be distributed or reproduced in any form without the written permission of SimplexGrinnell. SimplexGrinnell shall not be held liable for any errors or omissions. SimplexGrinnell shall not be held liable for any damage or injury resulting from the use of this drawing. SimplexGrinnell shall not be held liable for any damage or injury resulting from the use of this drawing.