


CUMBERLAND COUNTY FACILITIES DEPARTMENT

CUMBERLAND COUNTY COURTHOUSE

AIR CONDITIONING AND HEATING UPGRADES


PORTLAND, MAINE

ALLIED PROJECT #17051

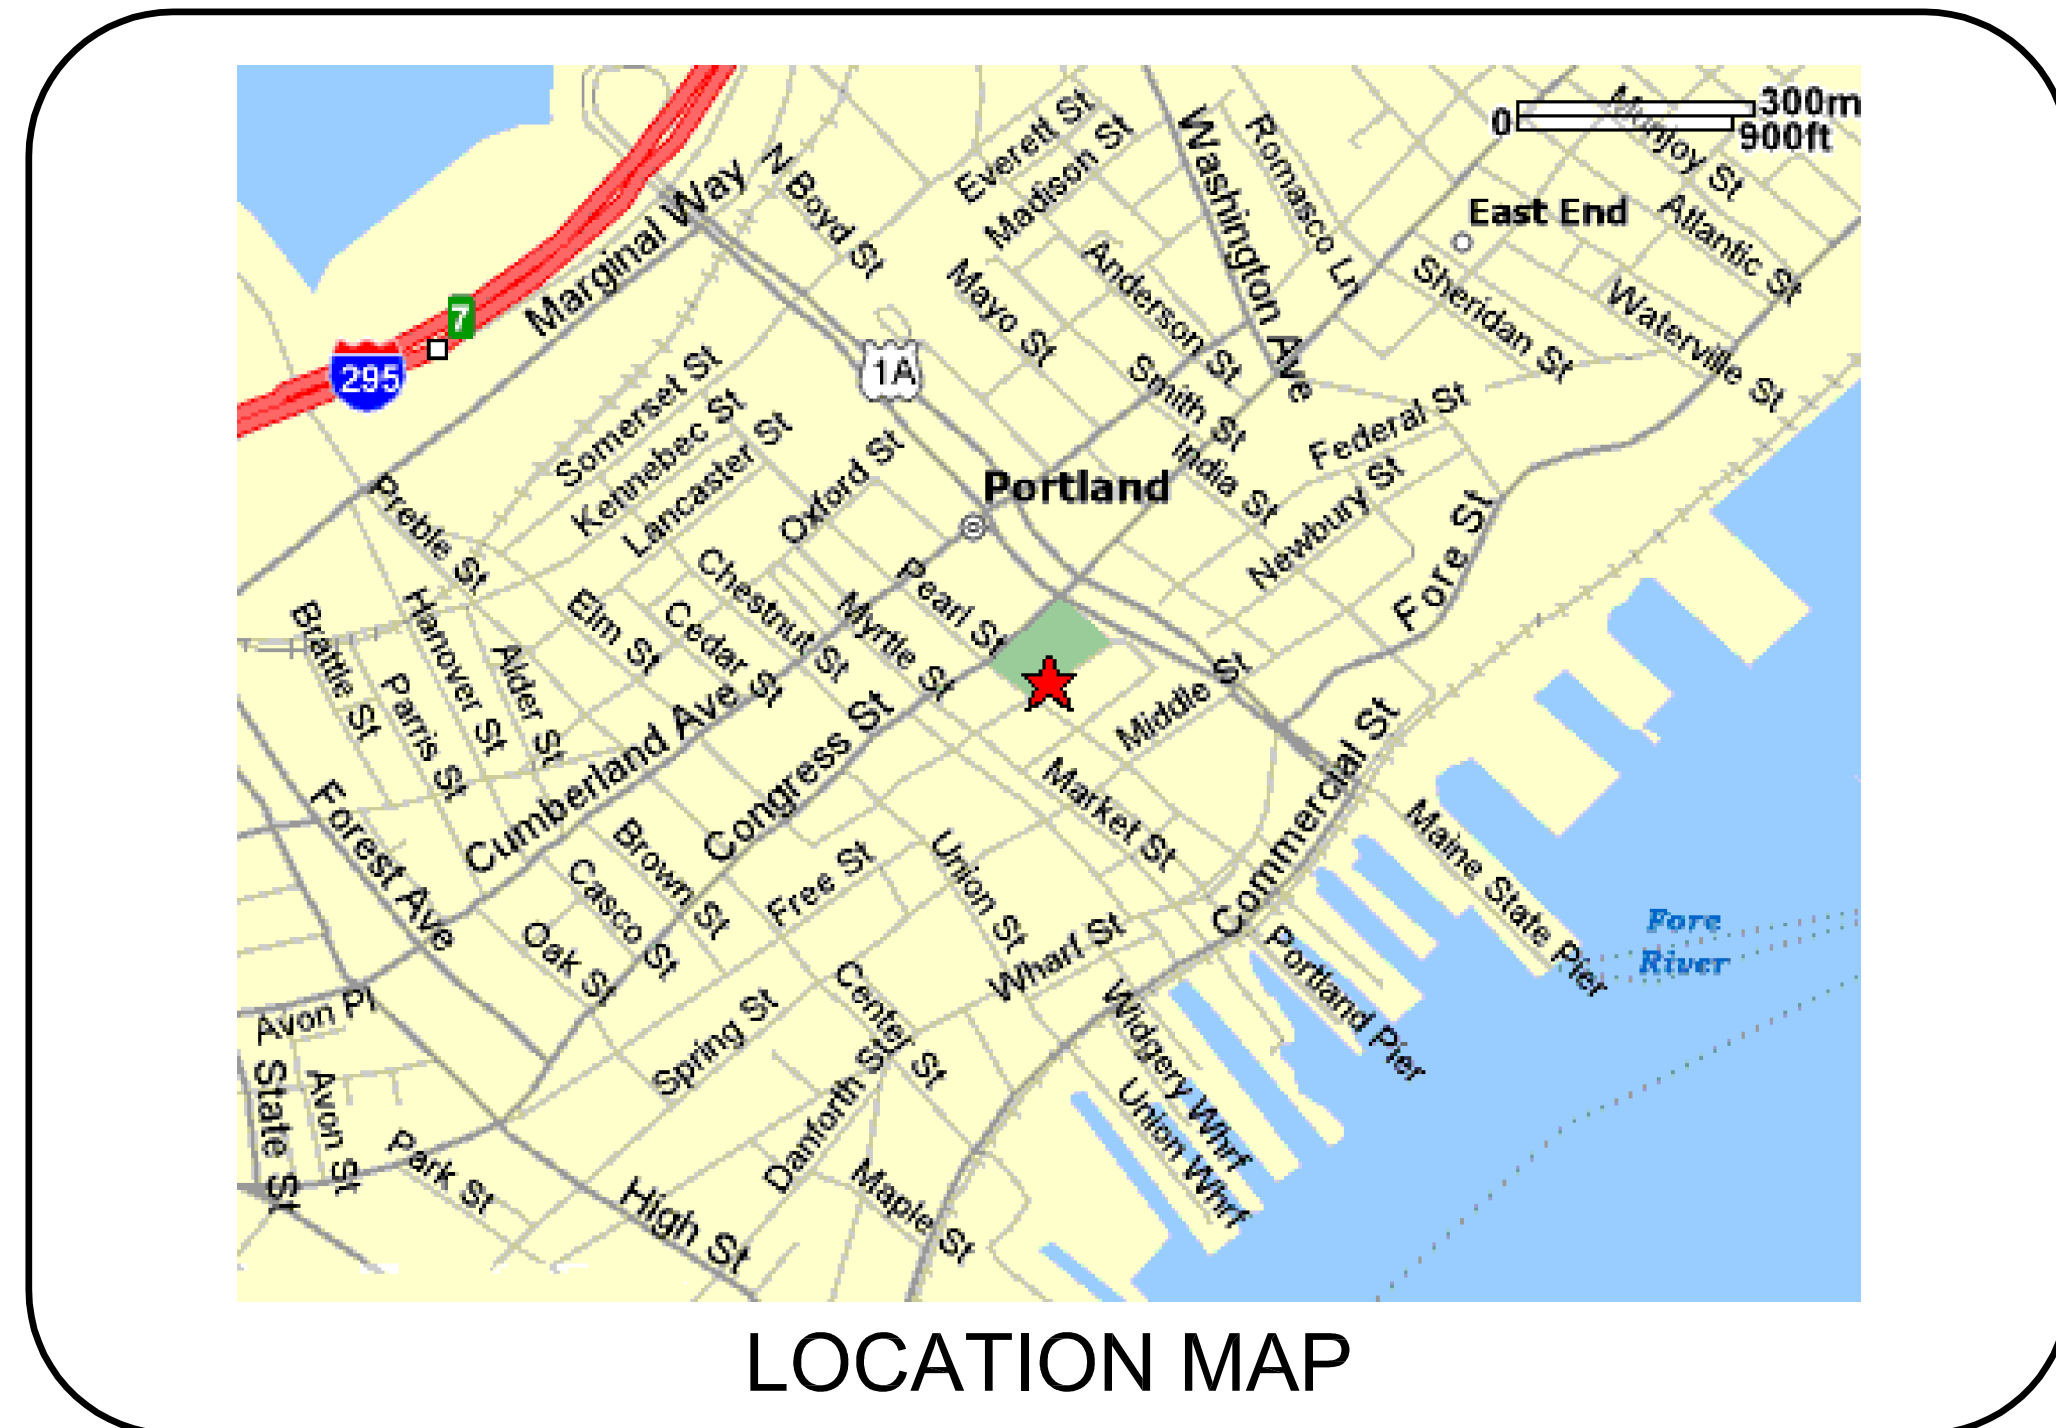

ISSUED FOR BID
22 DECEMBER, 2017

DRAWING STATUS LIST		ISSUE			
		DESCRIPTION	DATE	75% REVIEW	95% REVIEW
DRAWINGS					
Sht No.	SHEET TITLE	DESIGN DEVELOPMENT	75% REVIEW	95% REVIEW	ISSUED FOR BID
C-000	COVER SHEET	<input checked="" type="checkbox"/>	<input checked="" type="checkbox"/>	<input checked="" type="checkbox"/>	<input checked="" type="checkbox"/>
A-101	ARCHITECTURAL FIRST FLOOR PLAN	<input checked="" type="checkbox"/>	<input checked="" type="checkbox"/>	<input checked="" type="checkbox"/>	<input checked="" type="checkbox"/>
A-102	ARCHITECTURAL SECOND & THIRD FLOOR PLANS	<input checked="" type="checkbox"/>	<input checked="" type="checkbox"/>	<input checked="" type="checkbox"/>	<input checked="" type="checkbox"/>
A-103	ARCHITECTURAL ATTIC PLAN	<input checked="" type="checkbox"/>	<input checked="" type="checkbox"/>	<input checked="" type="checkbox"/>	<input checked="" type="checkbox"/>
A-201	BUILDING SECTION, ELEVATIONS AND CEILING ALTERNATE #4	<input checked="" type="checkbox"/>	<input checked="" type="checkbox"/>	<input checked="" type="checkbox"/>	<input checked="" type="checkbox"/>
A-301	HISTORIC WALL PANELING WORK	<input checked="" type="checkbox"/>	<input checked="" type="checkbox"/>	<input checked="" type="checkbox"/>	<input checked="" type="checkbox"/>
SF-100	STRUCTURAL - FRAMING PLANS AND NOTES	<input checked="" type="checkbox"/>	<input checked="" type="checkbox"/>	<input checked="" type="checkbox"/>	<input checked="" type="checkbox"/>
MH-000	MECHANICAL ABBREVIATIONS, LEGENDS AND NOTES	<input checked="" type="checkbox"/>	<input checked="" type="checkbox"/>	<input checked="" type="checkbox"/>	<input checked="" type="checkbox"/>
MD-100	MECHANICAL DEMOLITION FIRST FLOOR PLAN	<input checked="" type="checkbox"/>	<input checked="" type="checkbox"/>	<input checked="" type="checkbox"/>	<input checked="" type="checkbox"/>
MH-100	MECHANICAL FIRST FLOOR PLAN	<input checked="" type="checkbox"/>	<input checked="" type="checkbox"/>	<input checked="" type="checkbox"/>	<input checked="" type="checkbox"/>
MP-100	MECHANICAL PIPING FIRST FLOOR PLAN	<input checked="" type="checkbox"/>	<input checked="" type="checkbox"/>	<input checked="" type="checkbox"/>	<input checked="" type="checkbox"/>
MH-101	MECHANICAL SECOND & THIRD FLOOR PART PLANS	<input checked="" type="checkbox"/>	<input checked="" type="checkbox"/>	<input checked="" type="checkbox"/>	<input checked="" type="checkbox"/>
MH-102	MECHANICAL ATTIC FLOOR PLAN	<input checked="" type="checkbox"/>	<input checked="" type="checkbox"/>	<input checked="" type="checkbox"/>	<input checked="" type="checkbox"/>
MP-102	MECHANICAL PIPING ATTIC PLAN	<input checked="" type="checkbox"/>	<input checked="" type="checkbox"/>	<input checked="" type="checkbox"/>	<input checked="" type="checkbox"/>
MH-103	MECHANICAL ROOF PLAN	<input checked="" type="checkbox"/>	<input checked="" type="checkbox"/>	<input checked="" type="checkbox"/>	<input checked="" type="checkbox"/>
MH-500	MECHANICAL DETAILS AND NOTES	<input checked="" type="checkbox"/>	<input checked="" type="checkbox"/>	<input checked="" type="checkbox"/>	<input checked="" type="checkbox"/>
MH-600	MECHANICAL SCHEDULES AND NOTES	<input checked="" type="checkbox"/>	<input checked="" type="checkbox"/>	<input checked="" type="checkbox"/>	<input checked="" type="checkbox"/>
E-000	ELECTRICAL LEGENDS, ABBREVIATIONS, NOTES AND RISER DIAGRAMS	<input checked="" type="checkbox"/>	<input checked="" type="checkbox"/>	<input checked="" type="checkbox"/>	<input checked="" type="checkbox"/>
E-100	ELECTRICAL FIRST FLOOR PLAN	<input checked="" type="checkbox"/>	<input checked="" type="checkbox"/>	<input checked="" type="checkbox"/>	<input checked="" type="checkbox"/>
E-101	ELECTRICAL SECOND AND THIRD FLOOR PLAN	<input checked="" type="checkbox"/>	<input checked="" type="checkbox"/>	<input checked="" type="checkbox"/>	<input checked="" type="checkbox"/>
E-102	ELECTRICAL ATTIC PLAN	<input checked="" type="checkbox"/>	<input checked="" type="checkbox"/>	<input checked="" type="checkbox"/>	<input checked="" type="checkbox"/>
E-200	ELECTRICAL BASEMENT AND SCHEDULES	<input checked="" type="checkbox"/>	<input checked="" type="checkbox"/>	<input checked="" type="checkbox"/>	<input checked="" type="checkbox"/>

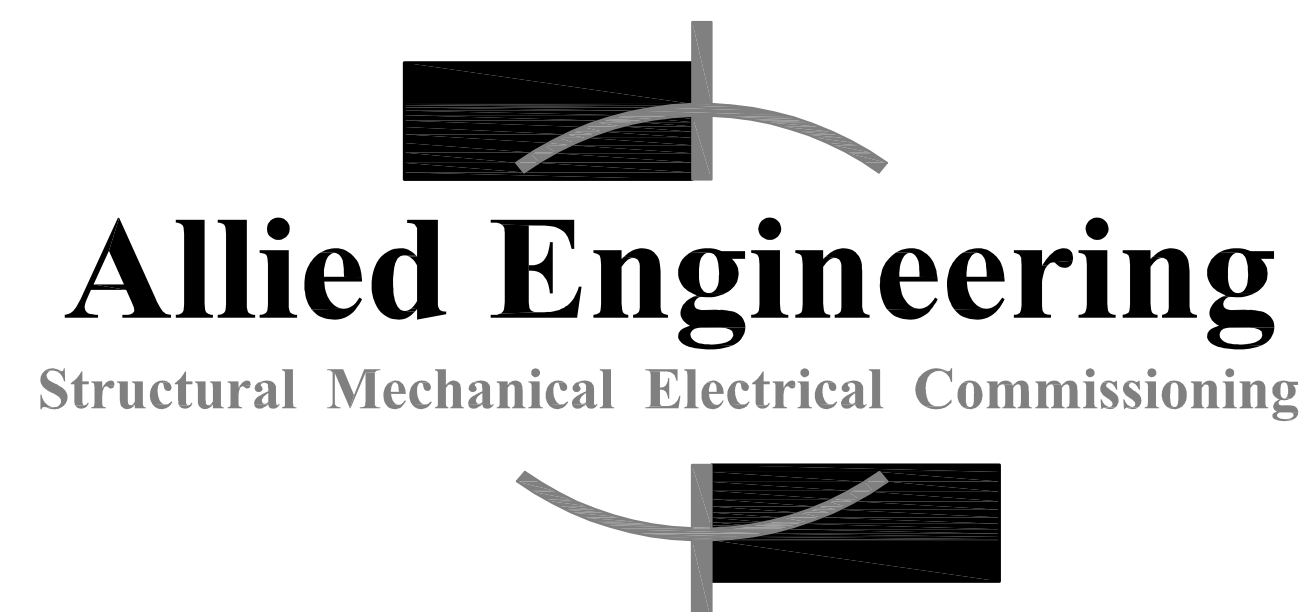

160 Veranda Street
Portland, Maine 04103
T: 207.221.2260
F: 207.221.2266
Web: www.allied-eng.com

