

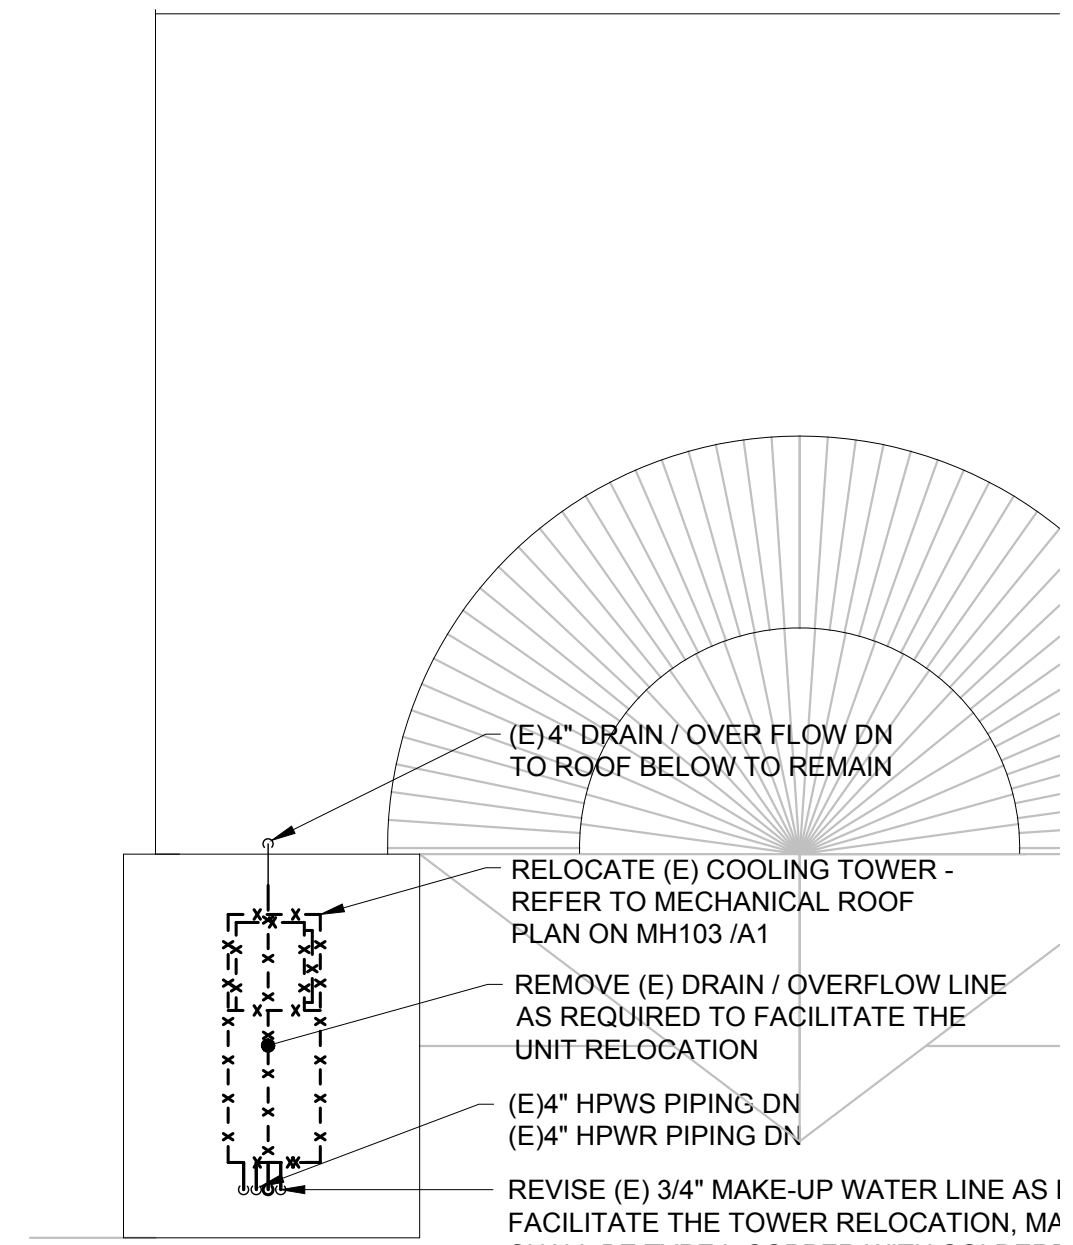


N:\Projects\2017\17051 - CCH AC and Heating Upgrades\1 Design Phase\2 DRAWINGS\17051M.dwg Dec 22, 2017 - 10:48am

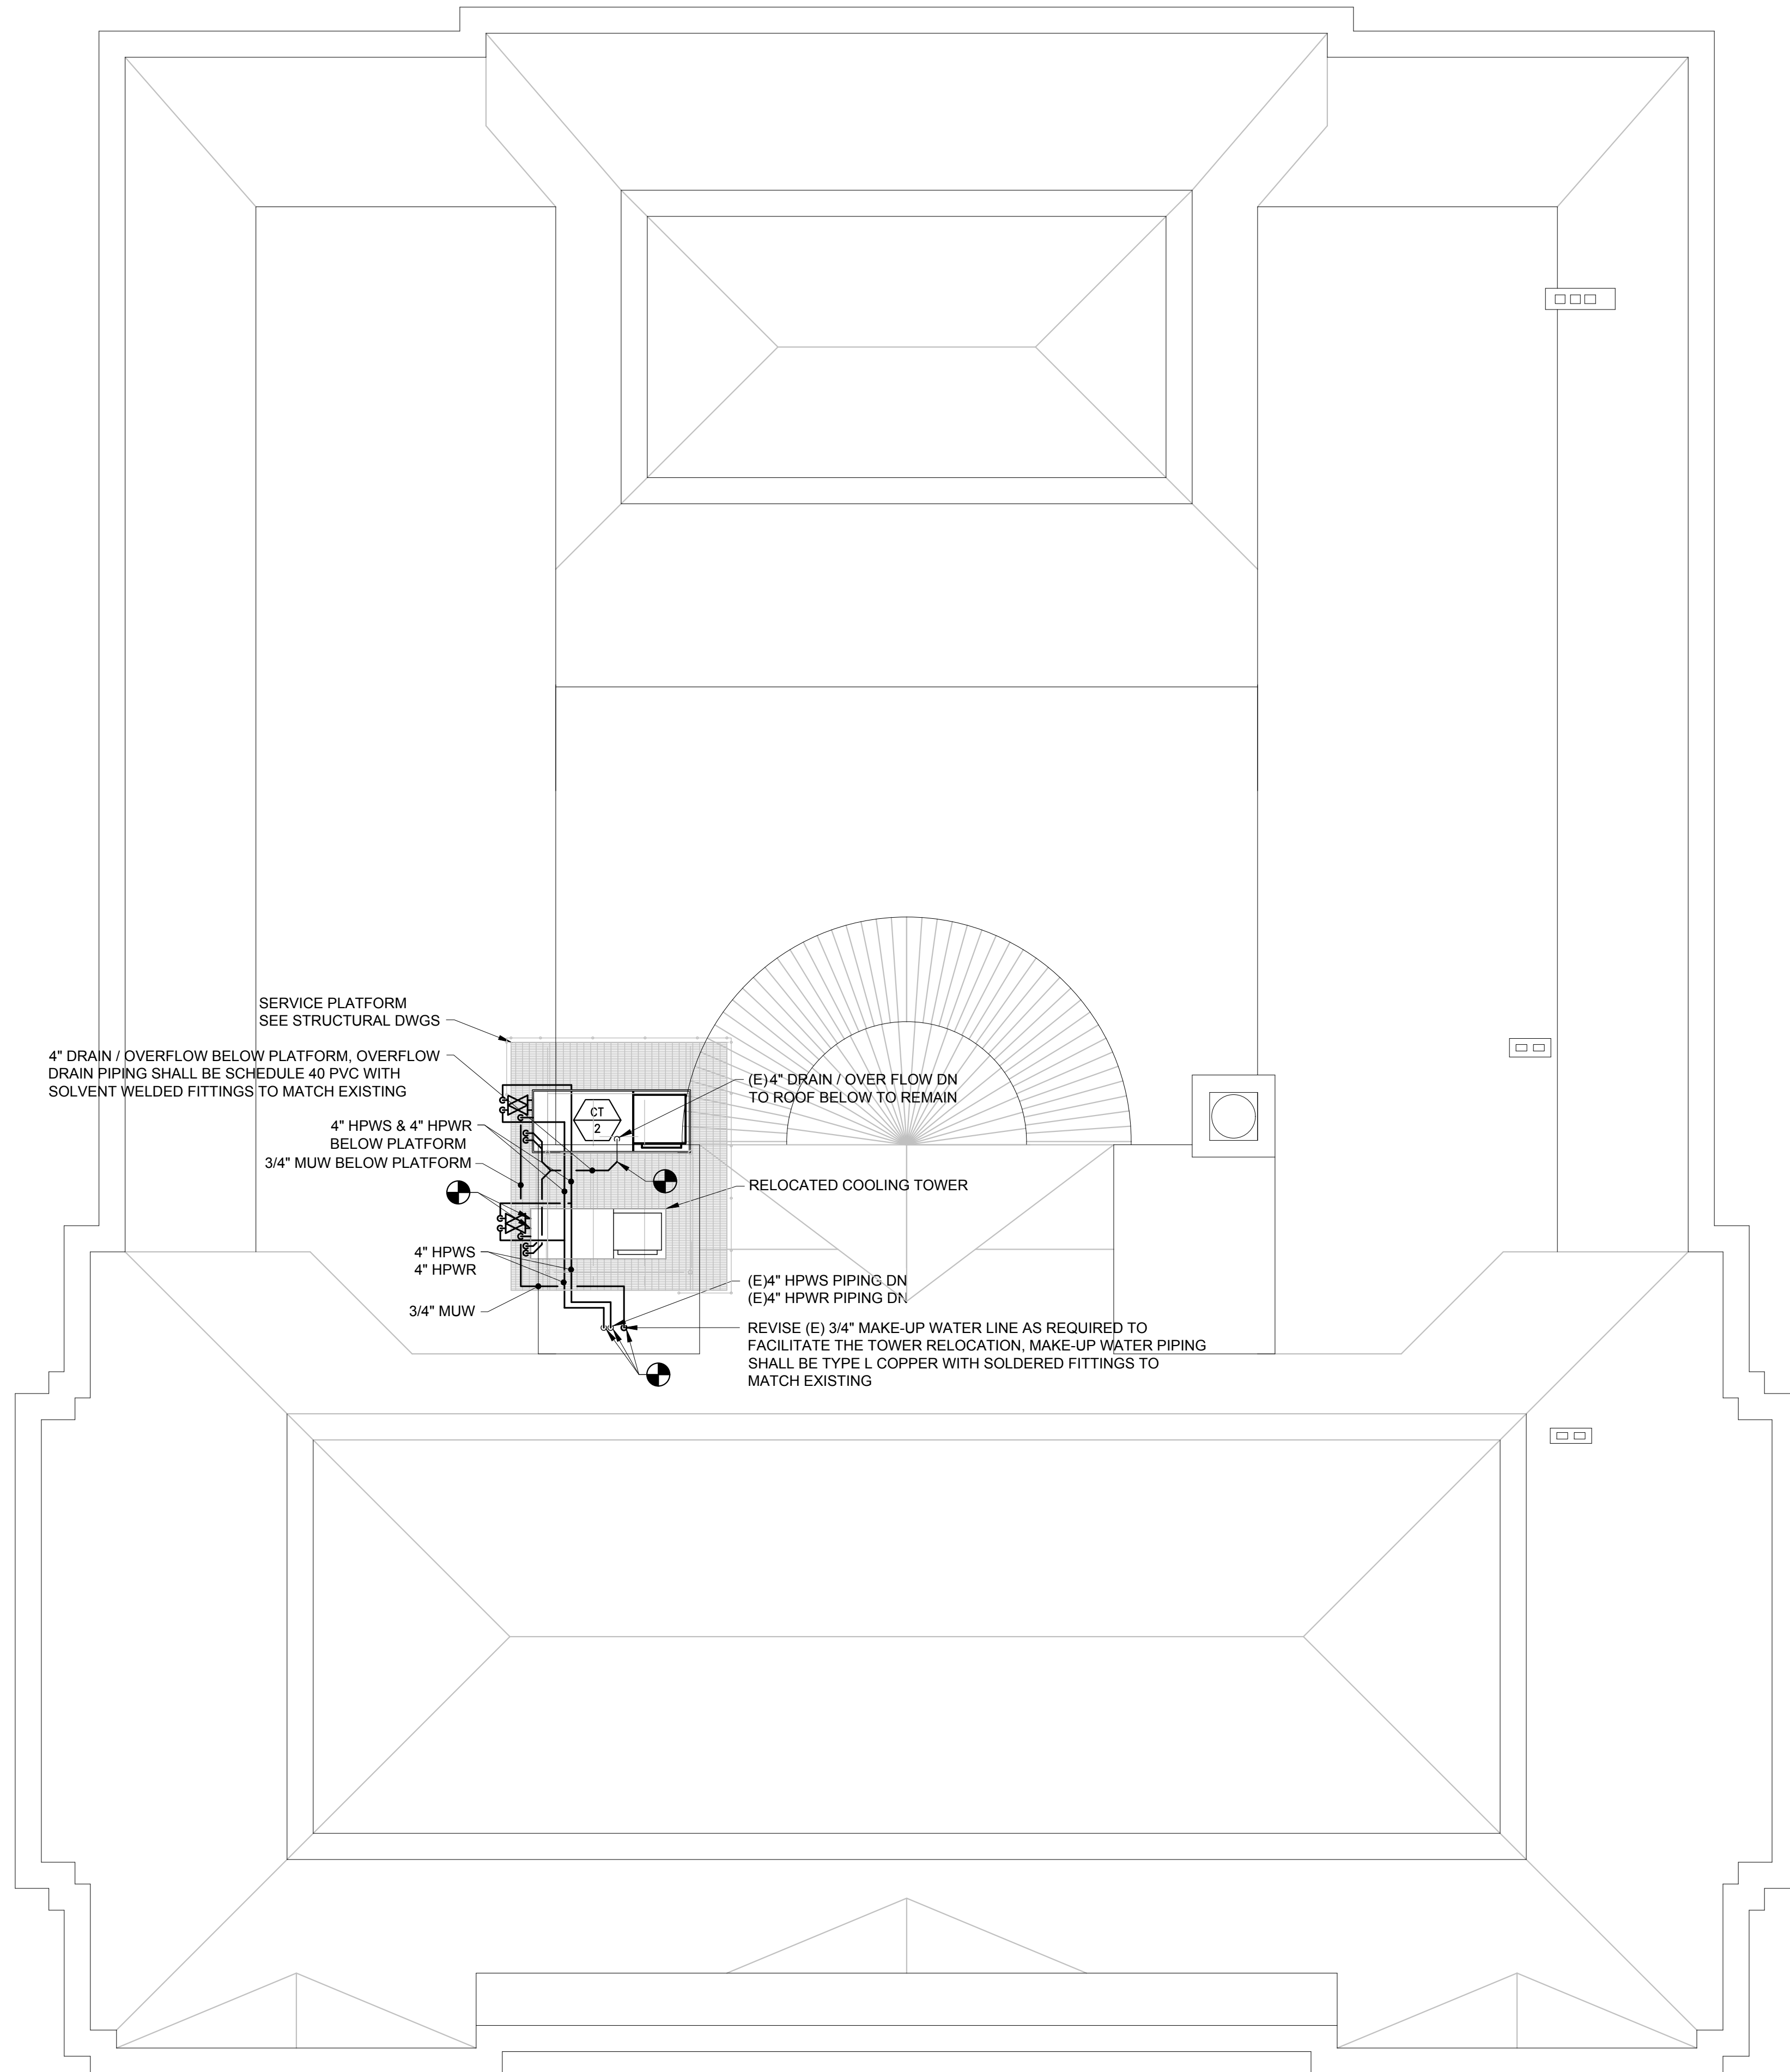

C9 ROOF DEMOLITION PLAN

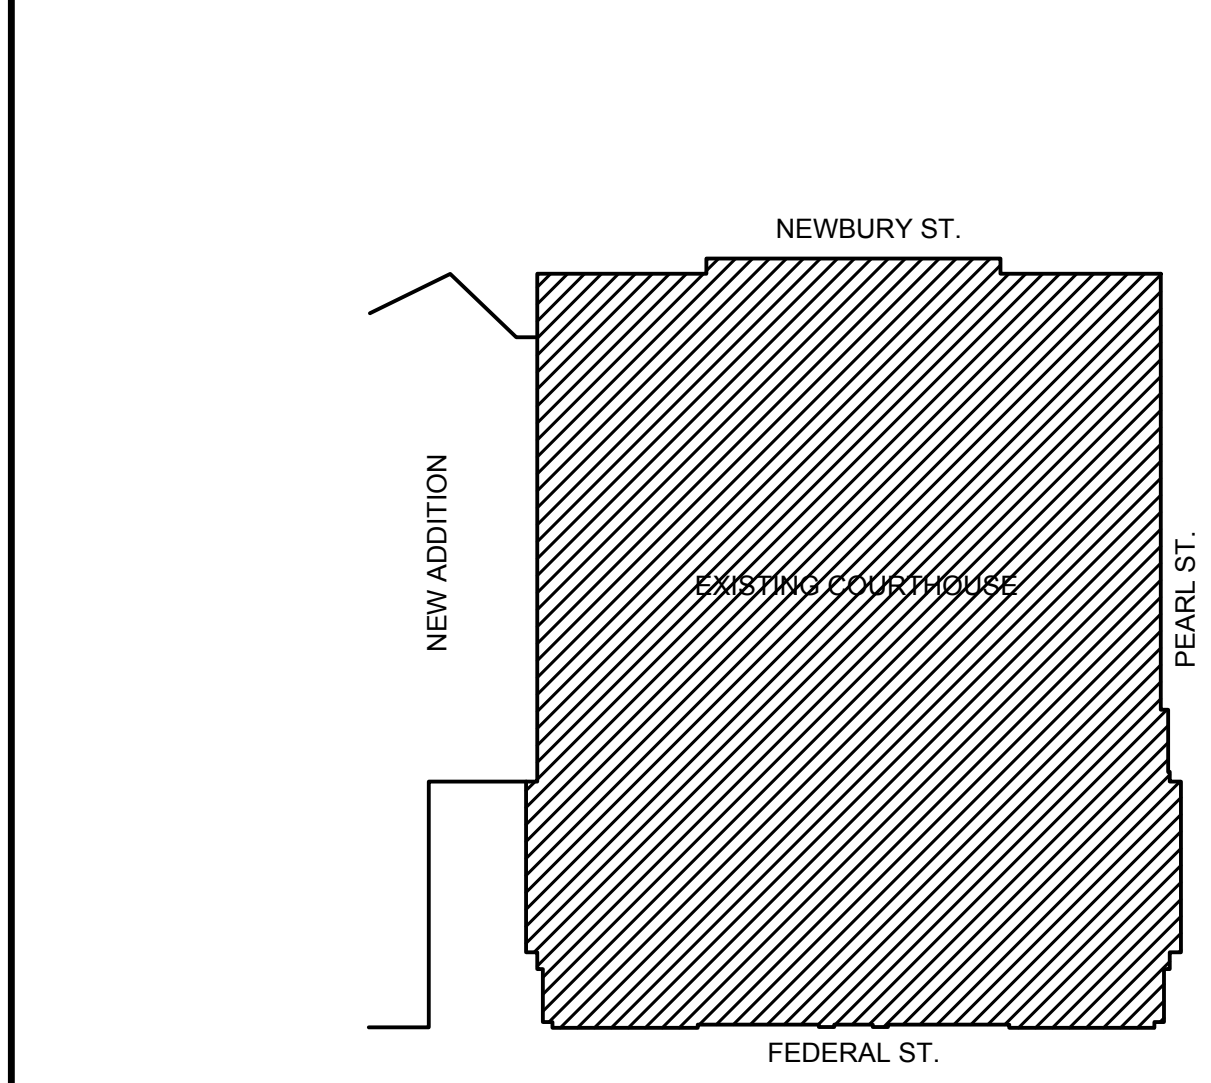


A4 KEY PLAN

A1 MECHANICAL ROOF PLAN

1/8" = 1'-0"

160 Veranda Street
 Portland, Maine 04103
 T: 207.221.2260
 F: 207.221.2266
 Web: www.allied-eng.com

Allied Engineering
 Structural Mechanical Electrical Commissioning

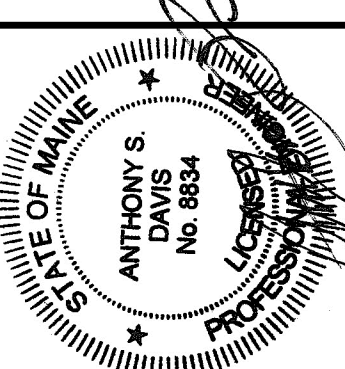

R E V I S I O N S	
NUMBER	DESCRIPTION

Date:	DECEMBER 22, 2017
Drawn By:	SCL
Checked By:	ASD
Project Mgr:	ASD
Project No.:	17051
Cad File:	17051M.DWG
Graphic Scale:	0 1"

MECHANICAL ROOF PLAN
 AIR CONDITIONING AND HEATING UPGRADES
 CUMBERLAND COUNTY COURTHOUSE
 142 FEDERAL STREET, PORTLAND, MAINE
 © COPYRIGHT 2017 ALLIED ENGINEERING, INC.

MH-103