


DETENTION AREA RENOVATIONS CUMBERLAND COUNTY COURTHOUSE PORTLAND, MAINE

ALLIED PROJECT No. 04084

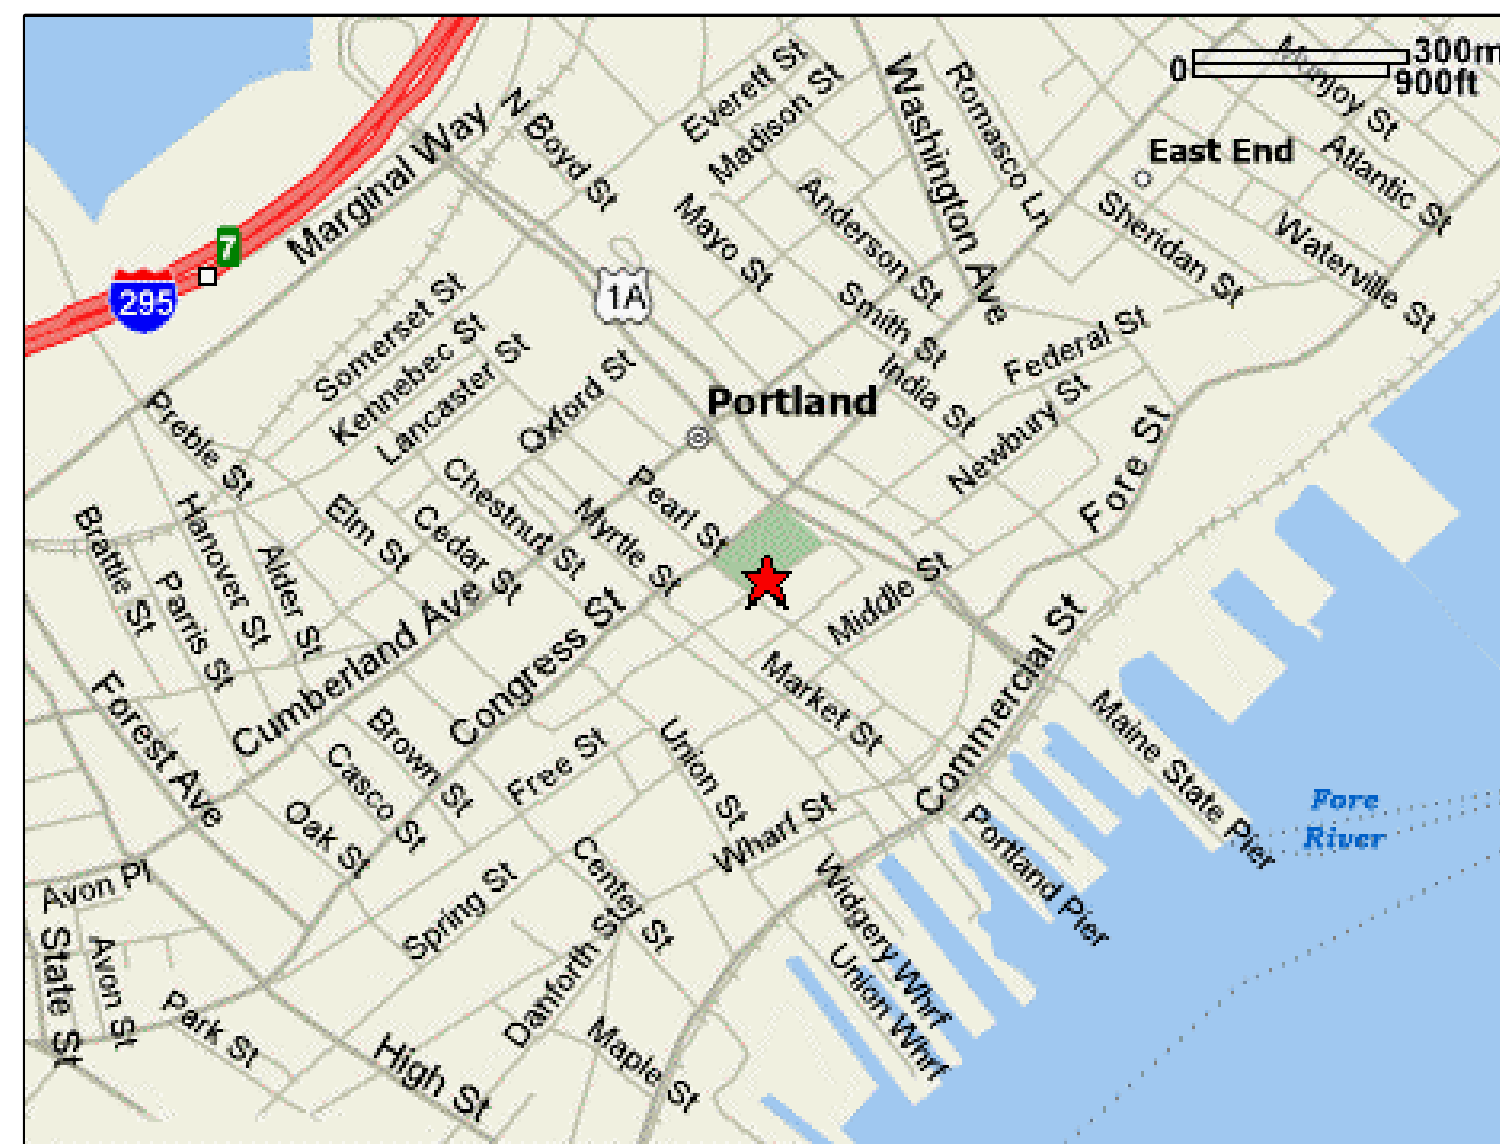

LOCATION MAP

**FOR CONSTRUCTION
04 OCTOBER 2005**

DRAWING LIST

DRAWINGS	
Sht No.	SHEET TITLE
A-100	FLOOR PLANS
A-101	REFLECTED CEILING PLAN
A-102	WALL SECTION AND ELEVATIONS
A-103	PARKING GARAGE FLOOR PLAN
SF-100	FLOOR SLAB PLAN, DETAILS AND NOTES
PL-000	PLUMBING AND HVAC NOTES, LEGEND AND ABBREVIATIONS
PL-100	PLUMBING DEMOLITION AND PLUMBING PLANS
PL-200	PLUMBING DETAILS
MH-100	MECHANICAL DEMOLITION AND MECHANICAL PLANS
MH-200	MECHANICAL DETAILS AND SCHEDULES
E-100	ELECTRICAL DEMOLITION AND ELECTRICAL PLANS



allied *engineering, inc.*
FULL SERVICE CONSULTING ENGINEERS

STRUCTURAL • MECHANICAL • ELECTRICAL • TECHNOLOGY
ENVIRONMENTAL SERVICES • CONSTRUCTION ADMINISTRATION

One Westbrook Common, Westbrook, Maine 04092-2804
Telephone No: 207-854-8126 • Fax No: 207-854-0603
E-Mail: info@allied-eng.com • www.allied-eng.com

Winton Scott Architects
Portland, ME

APPROVED FOR ---	APPROVED FOR ---
BY ---	BY ---
TITLE	TITLE
DATE	DATE
APPROVED FOR ---	APPROVED FOR ---
BY ---	BY ---
TITLE	TITLE
DATE	DATE

--	--	--	--	--